




PROPOSED FIRST FLOOR
PLAN 1:50 @ A1

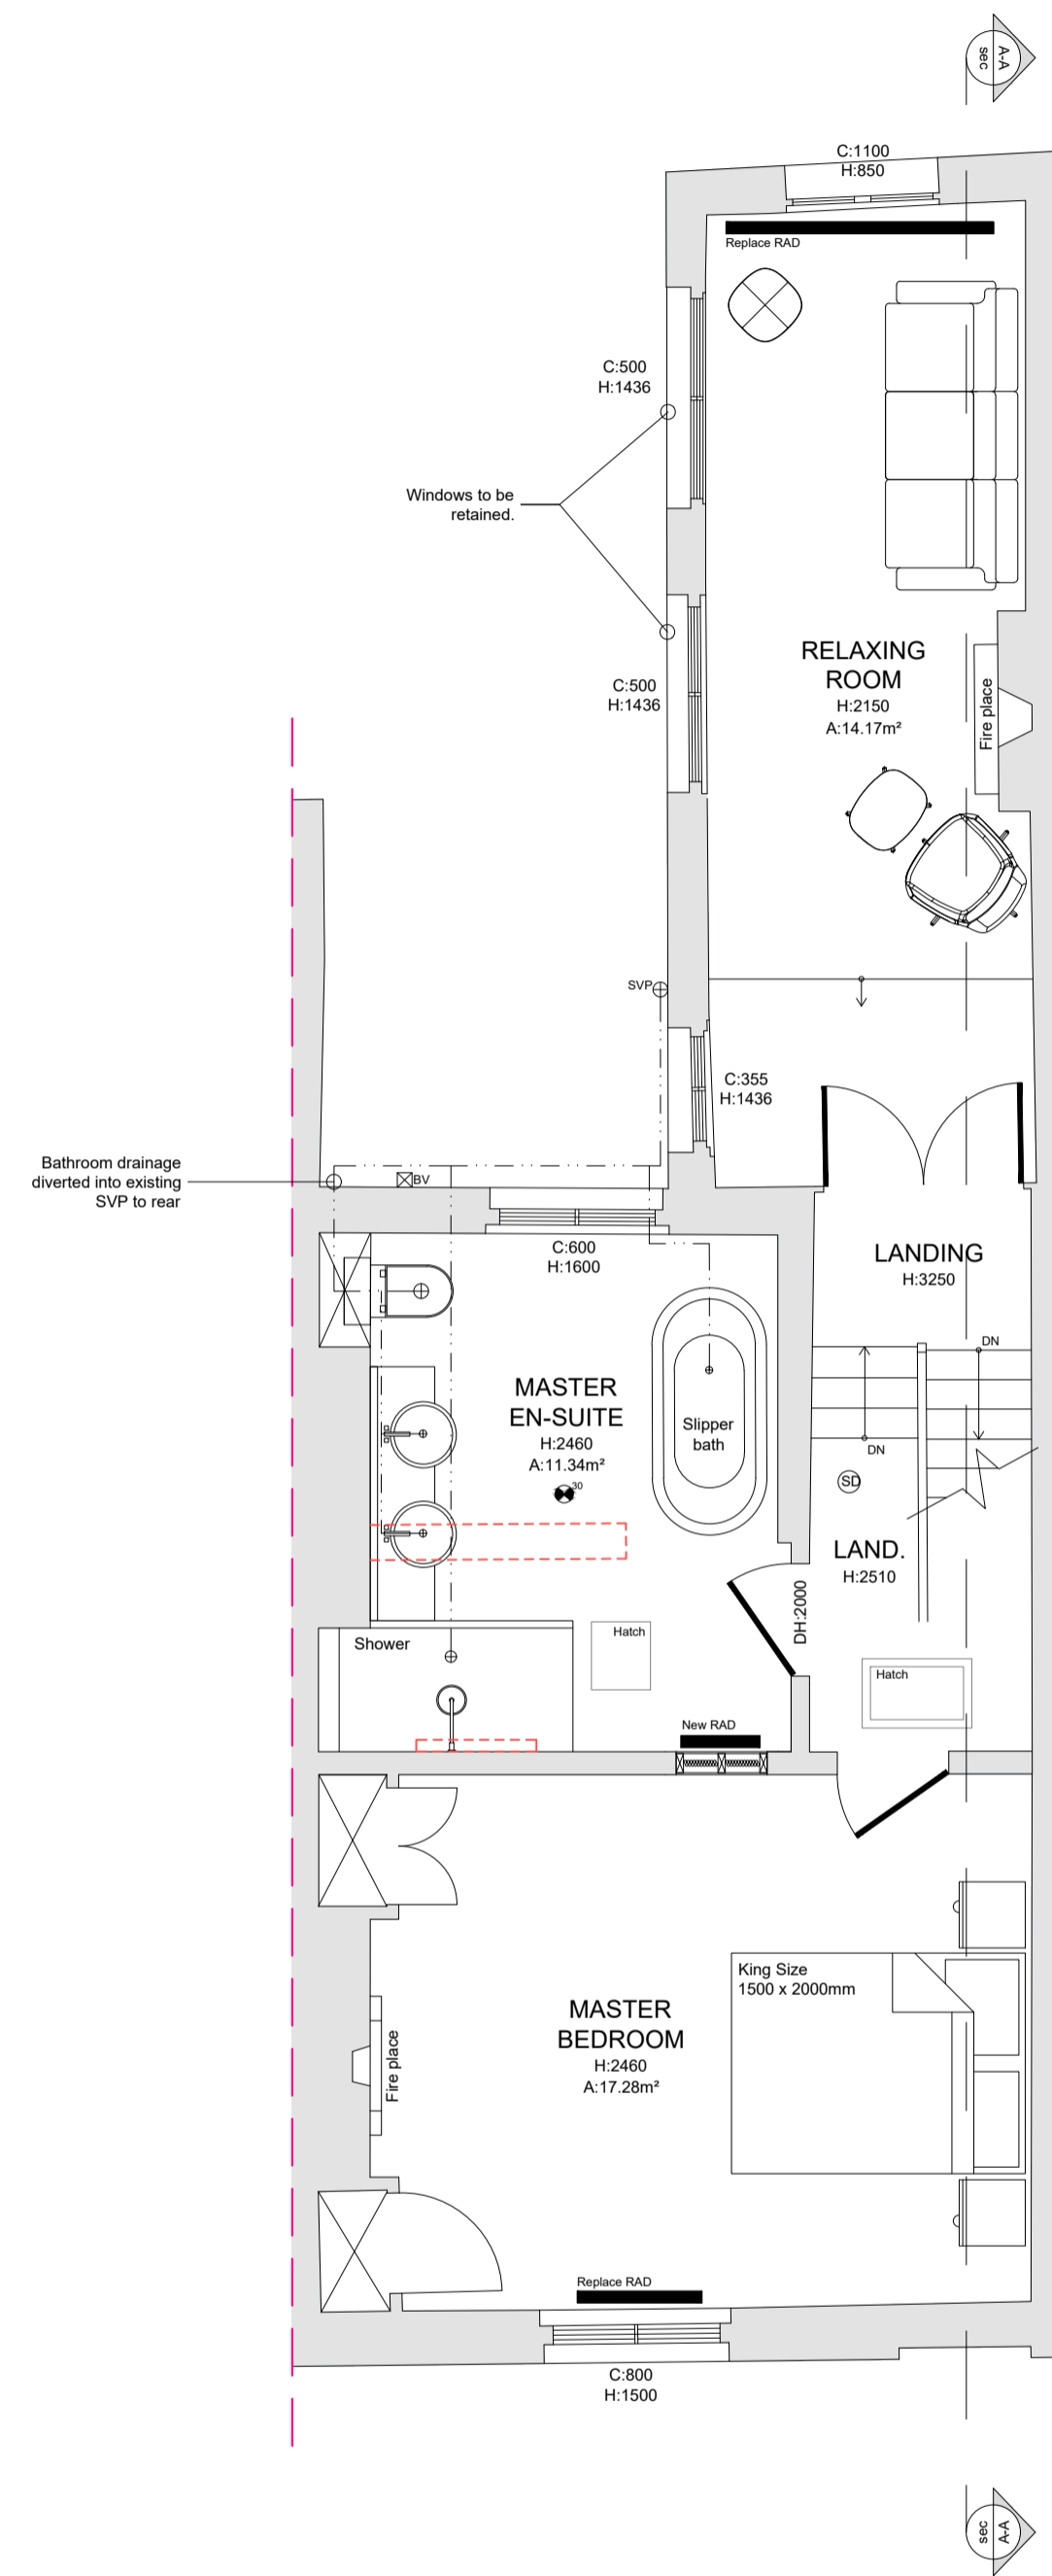

PROPOSED SECOND FLOOR
PLAN 1:50 @ A1

LEGEND

- GAS METERS
- ELECTRICAL METERS
- BOILER CONSUMER UNIT
- MEGAFLOW UNIT
- RADIATOR
- HEATED TOWEL RAIL
- DIRECTION OF ROOF FALL
- INSPECTION CHAMBER
- SOIL VENTILATION STACK
- STUB STACK
- RAINWATER PIPE
- GULLY
- WATER FEEDER TAPS
- PENDANT LIGHT FITTING
- WALL MOUNTED LIGHT FITTING
- SPOT/DOWN LIGHT FITTING
- UP LIGHT FITTING
- EXTERNAL LIGHT FITTING
- CEILING FAN
- 30MIN FIRE RATED DOOR
- SMOKE DETECTOR
- HEAT DETECTOR
- CARBON MONOXIDE DETECTOR
- TOUGHENED SAFETY GLASS
- OBSCURE GLAZING
- SOL'S MECHANICAL VENTILATION
- 60LS MECHANICAL VENTILATION
- BESPOKE MECHANICAL VENTILATION
- KITCHEN VENTILATION FLUE
- BATHROOM VENTILATION FLUE
- UTILITY ROOM VENTILATION FLUE
- BOILER VENTILATION FLUE
- TUMBLE DRYER VENTILATION

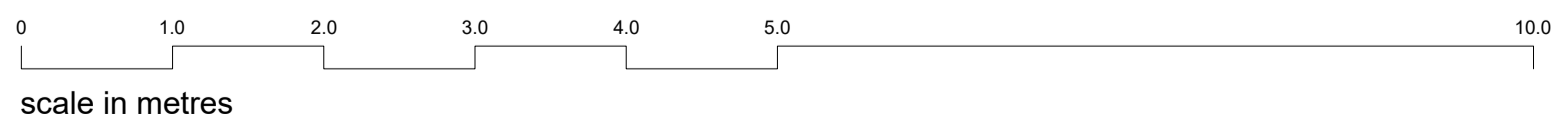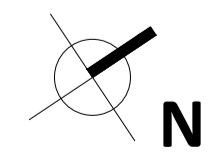

LIFE SIZE

01273 688 744
studio@lifesizearchitecture.co.uk
www.lifesizearchitecture.co.uk

description: date: revision:

PROPOSED FIRST & SECOND FLOOR PLANS

project no: 22025CP drawing no: 101

drawing status: **PLANNING**

client: MR & MRS HASSELL-HART
project: 11 CLIFTON PLACE, BRIGHTON
PROPOSED MINOR EXTERNAL AMENDS

date: 19.01.24 scale: 1:50 @ A1 drawn: RJB checked: RJB