


DRAINAGE NOTES

Pipes, bends and junctions: PVC-U to BS EN 13476 Kitemarked and fittings to BS EN 1401 and/or BS EN 4660 Kitemarked in 150 mm 5-14 mm granular surround with protection as necessary to BS EN 1610.

Inspection chambers - plastics: To BS 7158, BS EN 13598-1, BS EN 13598-2 or Agreement certified.

DRAINAGE KEY

- Existing FW drain
- 110 mm dia. replacement/ new FW drain laid to 1:40 fall
- 110 mm dia. new SW drain laid to 1:40 fall
- 450 mm dia. inspection chamber
- Back inlet gully
- Proprietary modular plastics soakaway units; capacity: 1.0 m3
- Vertical inlet hopper

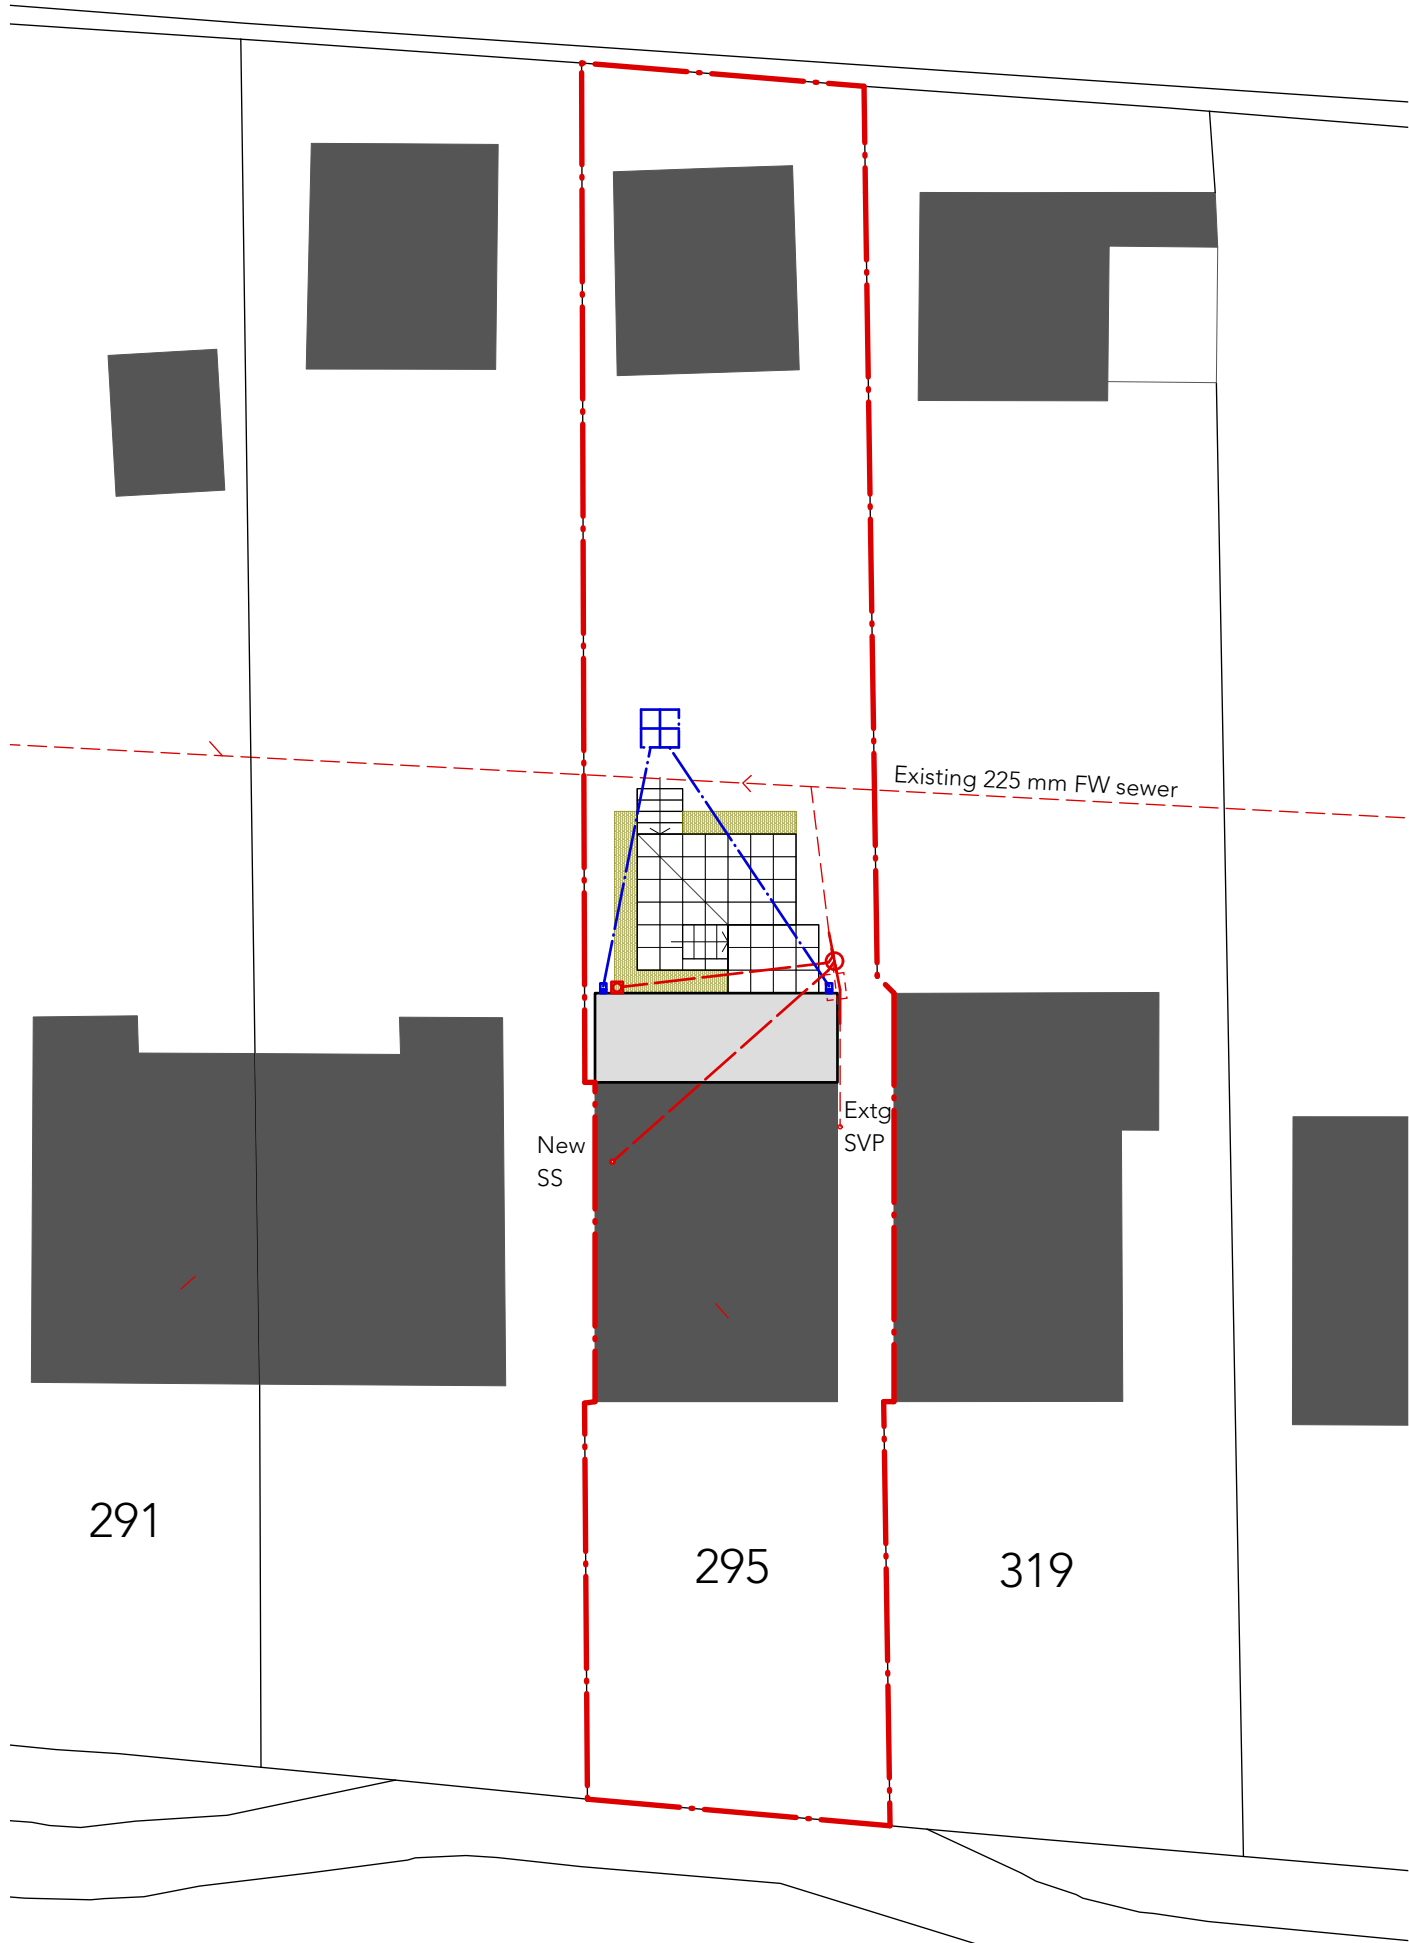

P2	08.03.24	New SS and FW drain added	AG	
P1	29.02.24	Initial issue	AG	
Rev	Date	Amendment	By	Chkd
0	1	2	3	metres

Proposed site plan

Proposed extension + alterations

295 Ware Road, Hertford SG13 7EL

Scale 1:200 @ A3 Date Feb 2024 Drawing no. 23_406 | L | 102_P2