



PROPOSED SOUTH ELEVATION
1:100



PROPOSED EAST ELEVATION
1:100


● Outdoor wall light Eyrin with motion detector from www.lights.com



PROPOSED NORTH ELEVATION
1:100




PROPOSED WEST ELEVATION
1:100

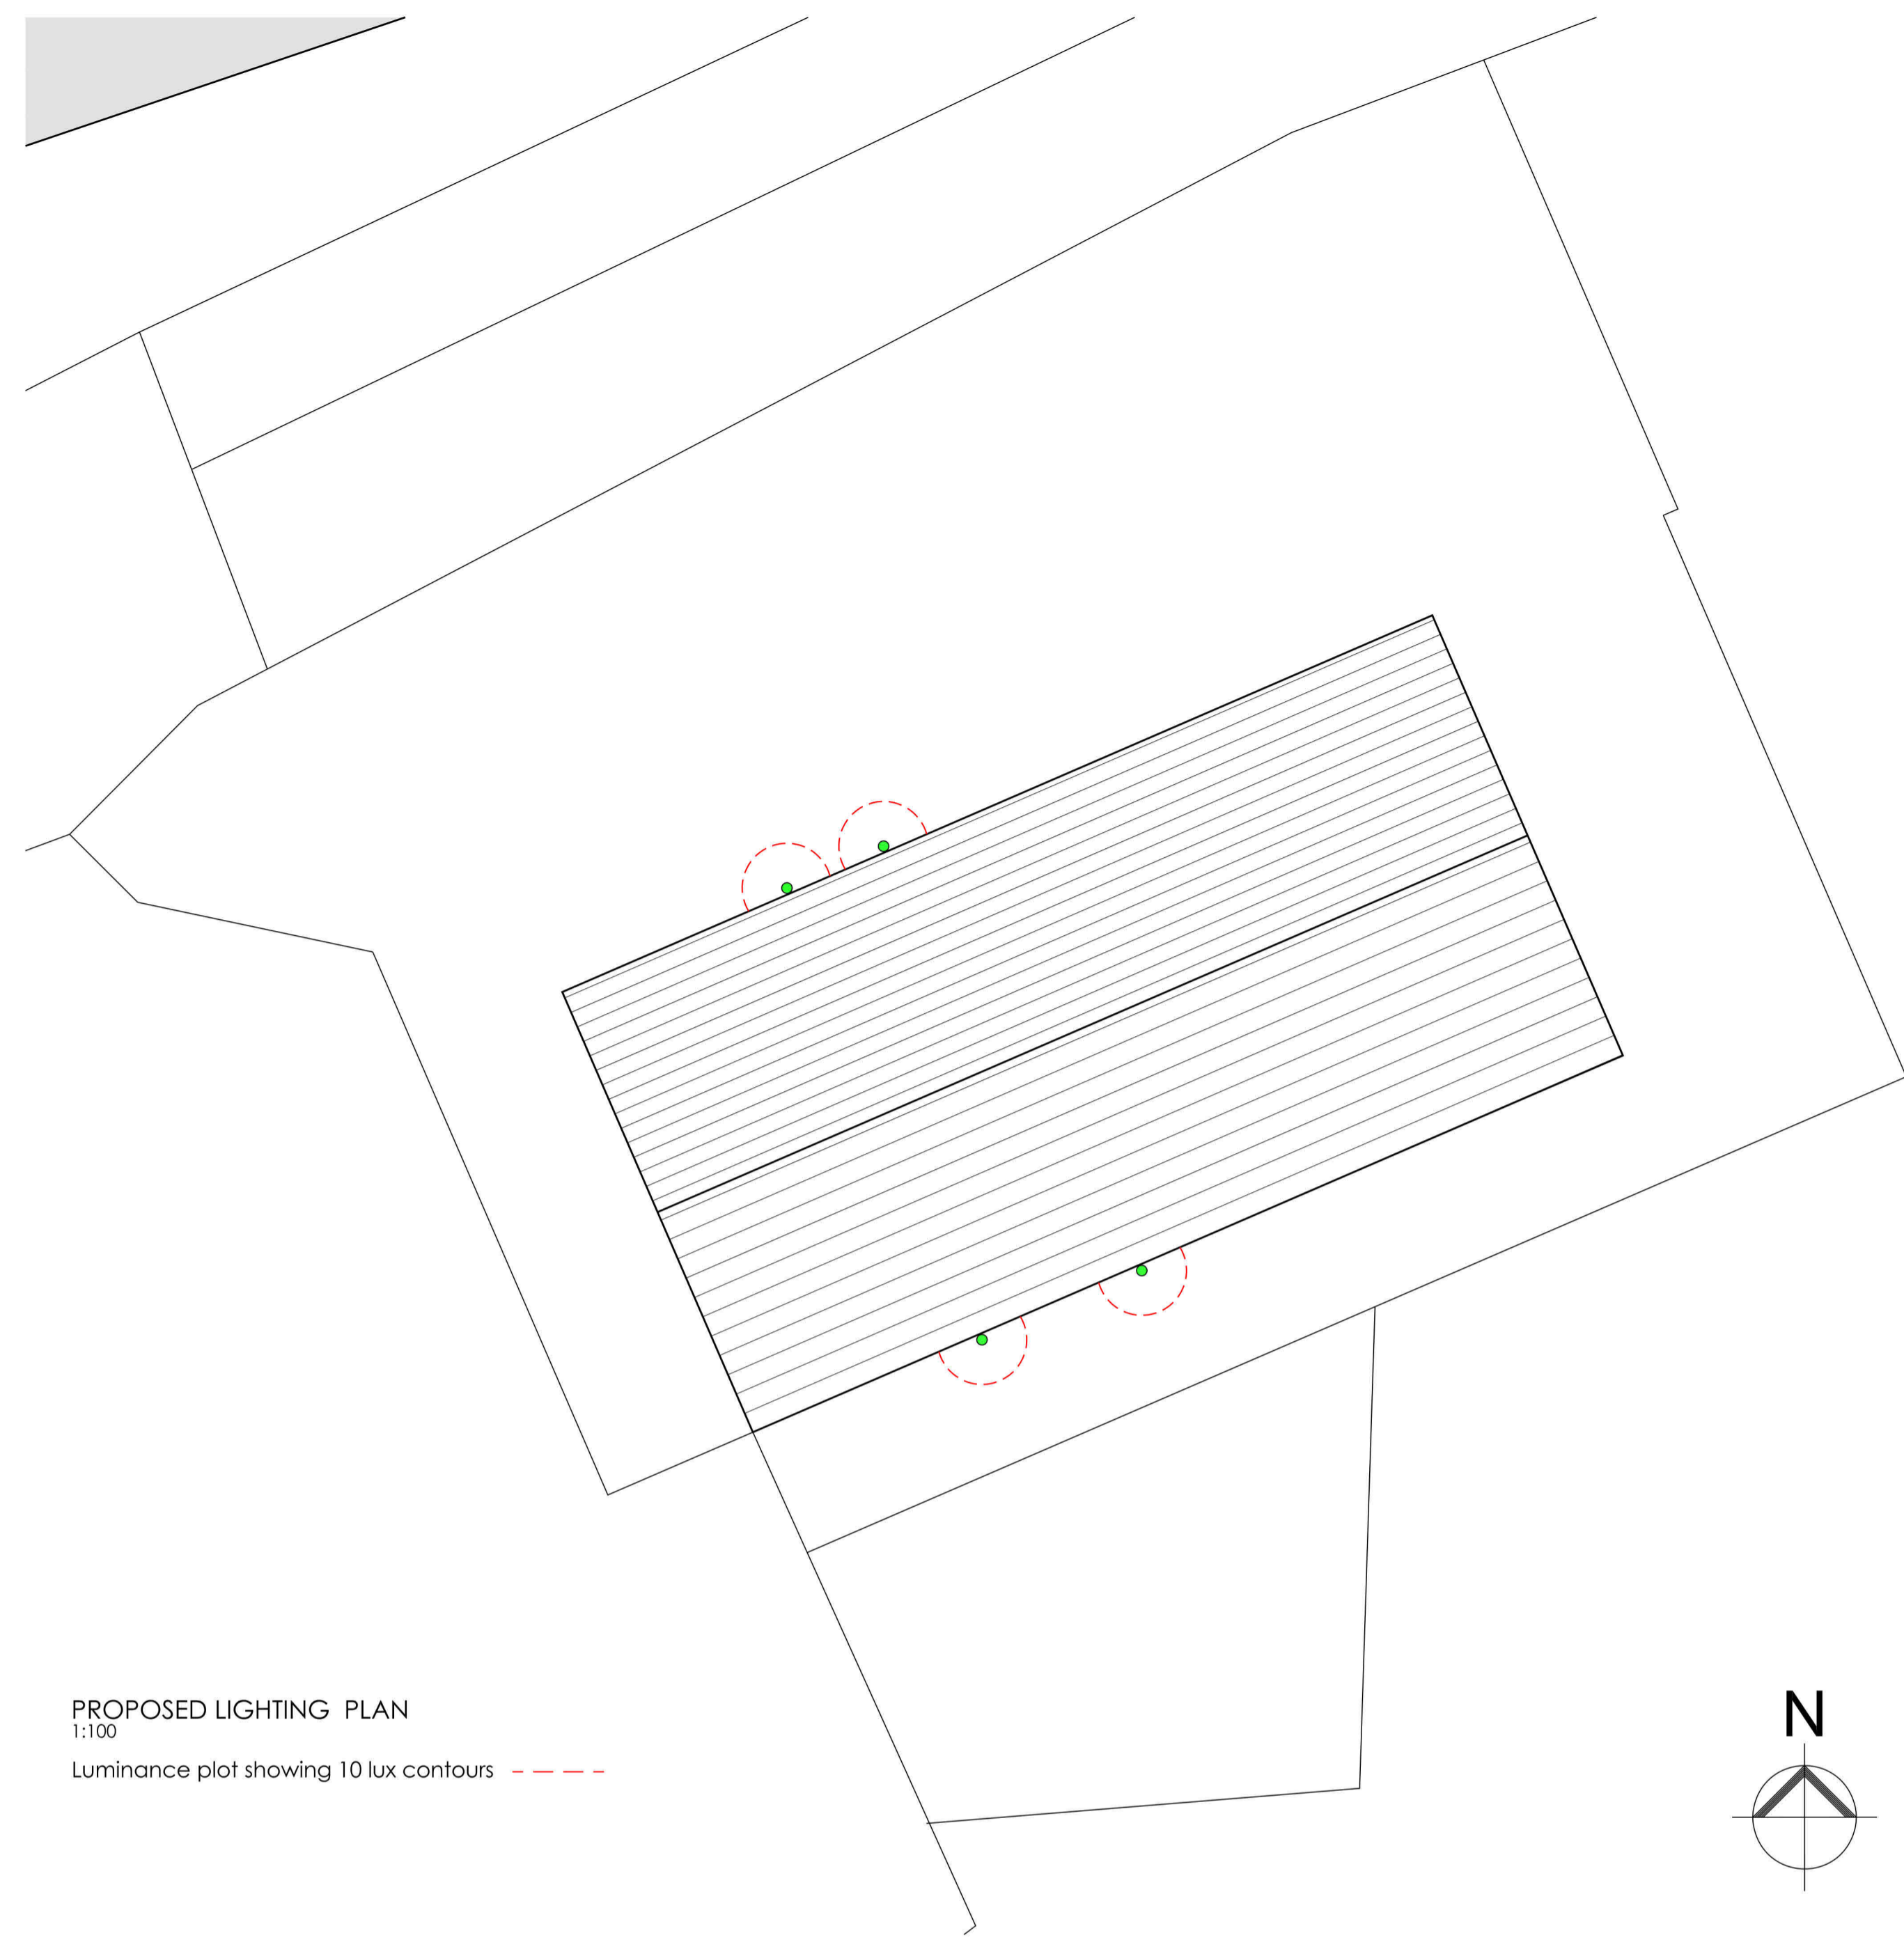

PROPOSED LIGHTING PLAN
1:100

Luminance plot showing 10 lux contours - - - - -

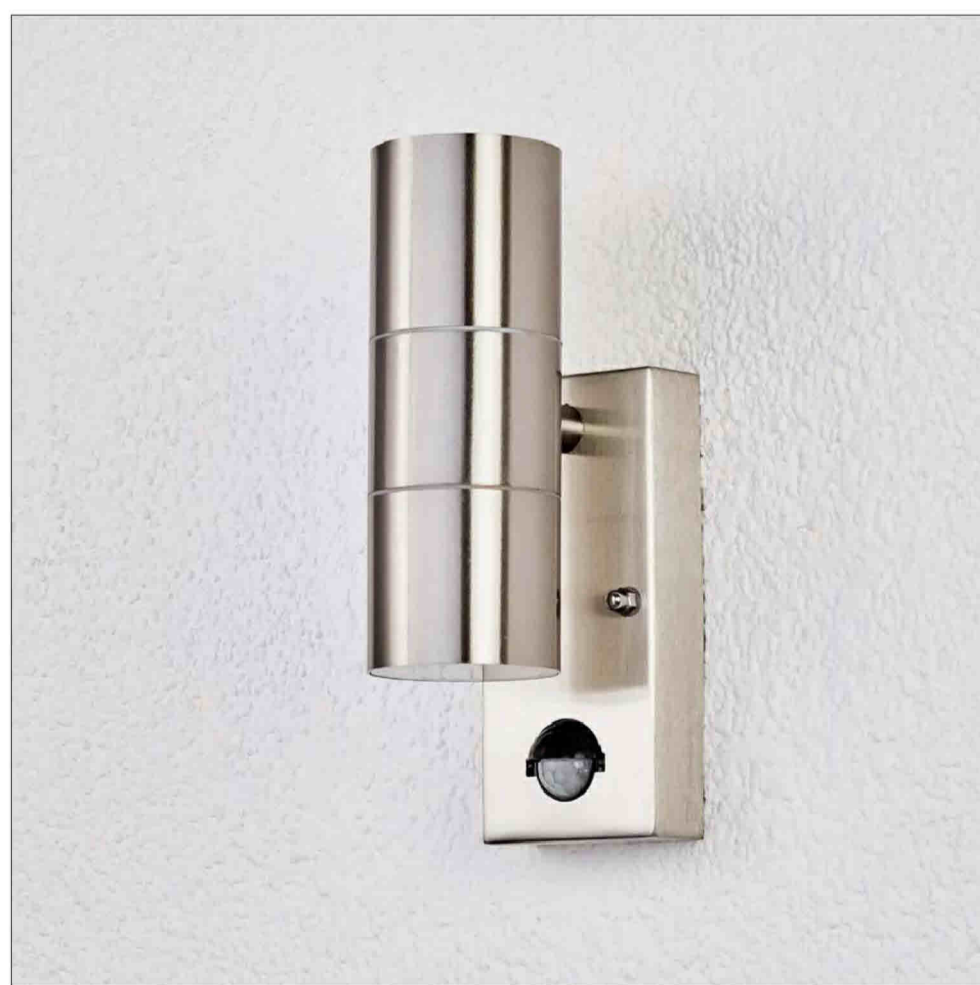

Eyrin outdoor wall light from www.lights.com

Copyright Notice:
This drawing is the copyright of Design Studio - North LLP (Architects) and shall not be reproduced without permission. © 2023
General Notes

No.	Revision / Issue	Date
A	lighting revised	03/2024

Issue Purpose	Condition Discharge
Client	Durkan Development
Project	Proposed External Works at Tithe Barn Lane Bardsey, Leeds LS17 9DX



Dwg. Title		Proposed External Lighting	
Dwg. No.	578-001-1002	Rev.	A
Scale	1:100 @ A1	Date	October 2023
Drawn by	GSB	Checked	DKW