



LEGEND	
○	Telephone Socket
□	Door Air Socket
□	TV Aerial Socket
□	Fire Alarm Break Glass
□	Fire Alarm Sounder
□	Fire Alarm Control Panel
□	Change in Floor Construction etc.
□	Handmade Fire Exit Sign
□	Single Supply Socket
□	Single Ganga Light Switch
□	Emergency Switch
□	Substituted
→	Key Symbol for Direction of Supply Control
→	Key Symbol - 18 Direction of Supply from etc.
○	Fire Sensor For Floor To Ceiling Height
○	Water A Sense Device
○	Hidden Device Under Stairs etc.
○	Overhead Stairs Hand Light etc.
○	Fire Alarm Test Unit
○	Height of window sill and window head from etc.
+	FFL 1.00
+	FFL 2.00

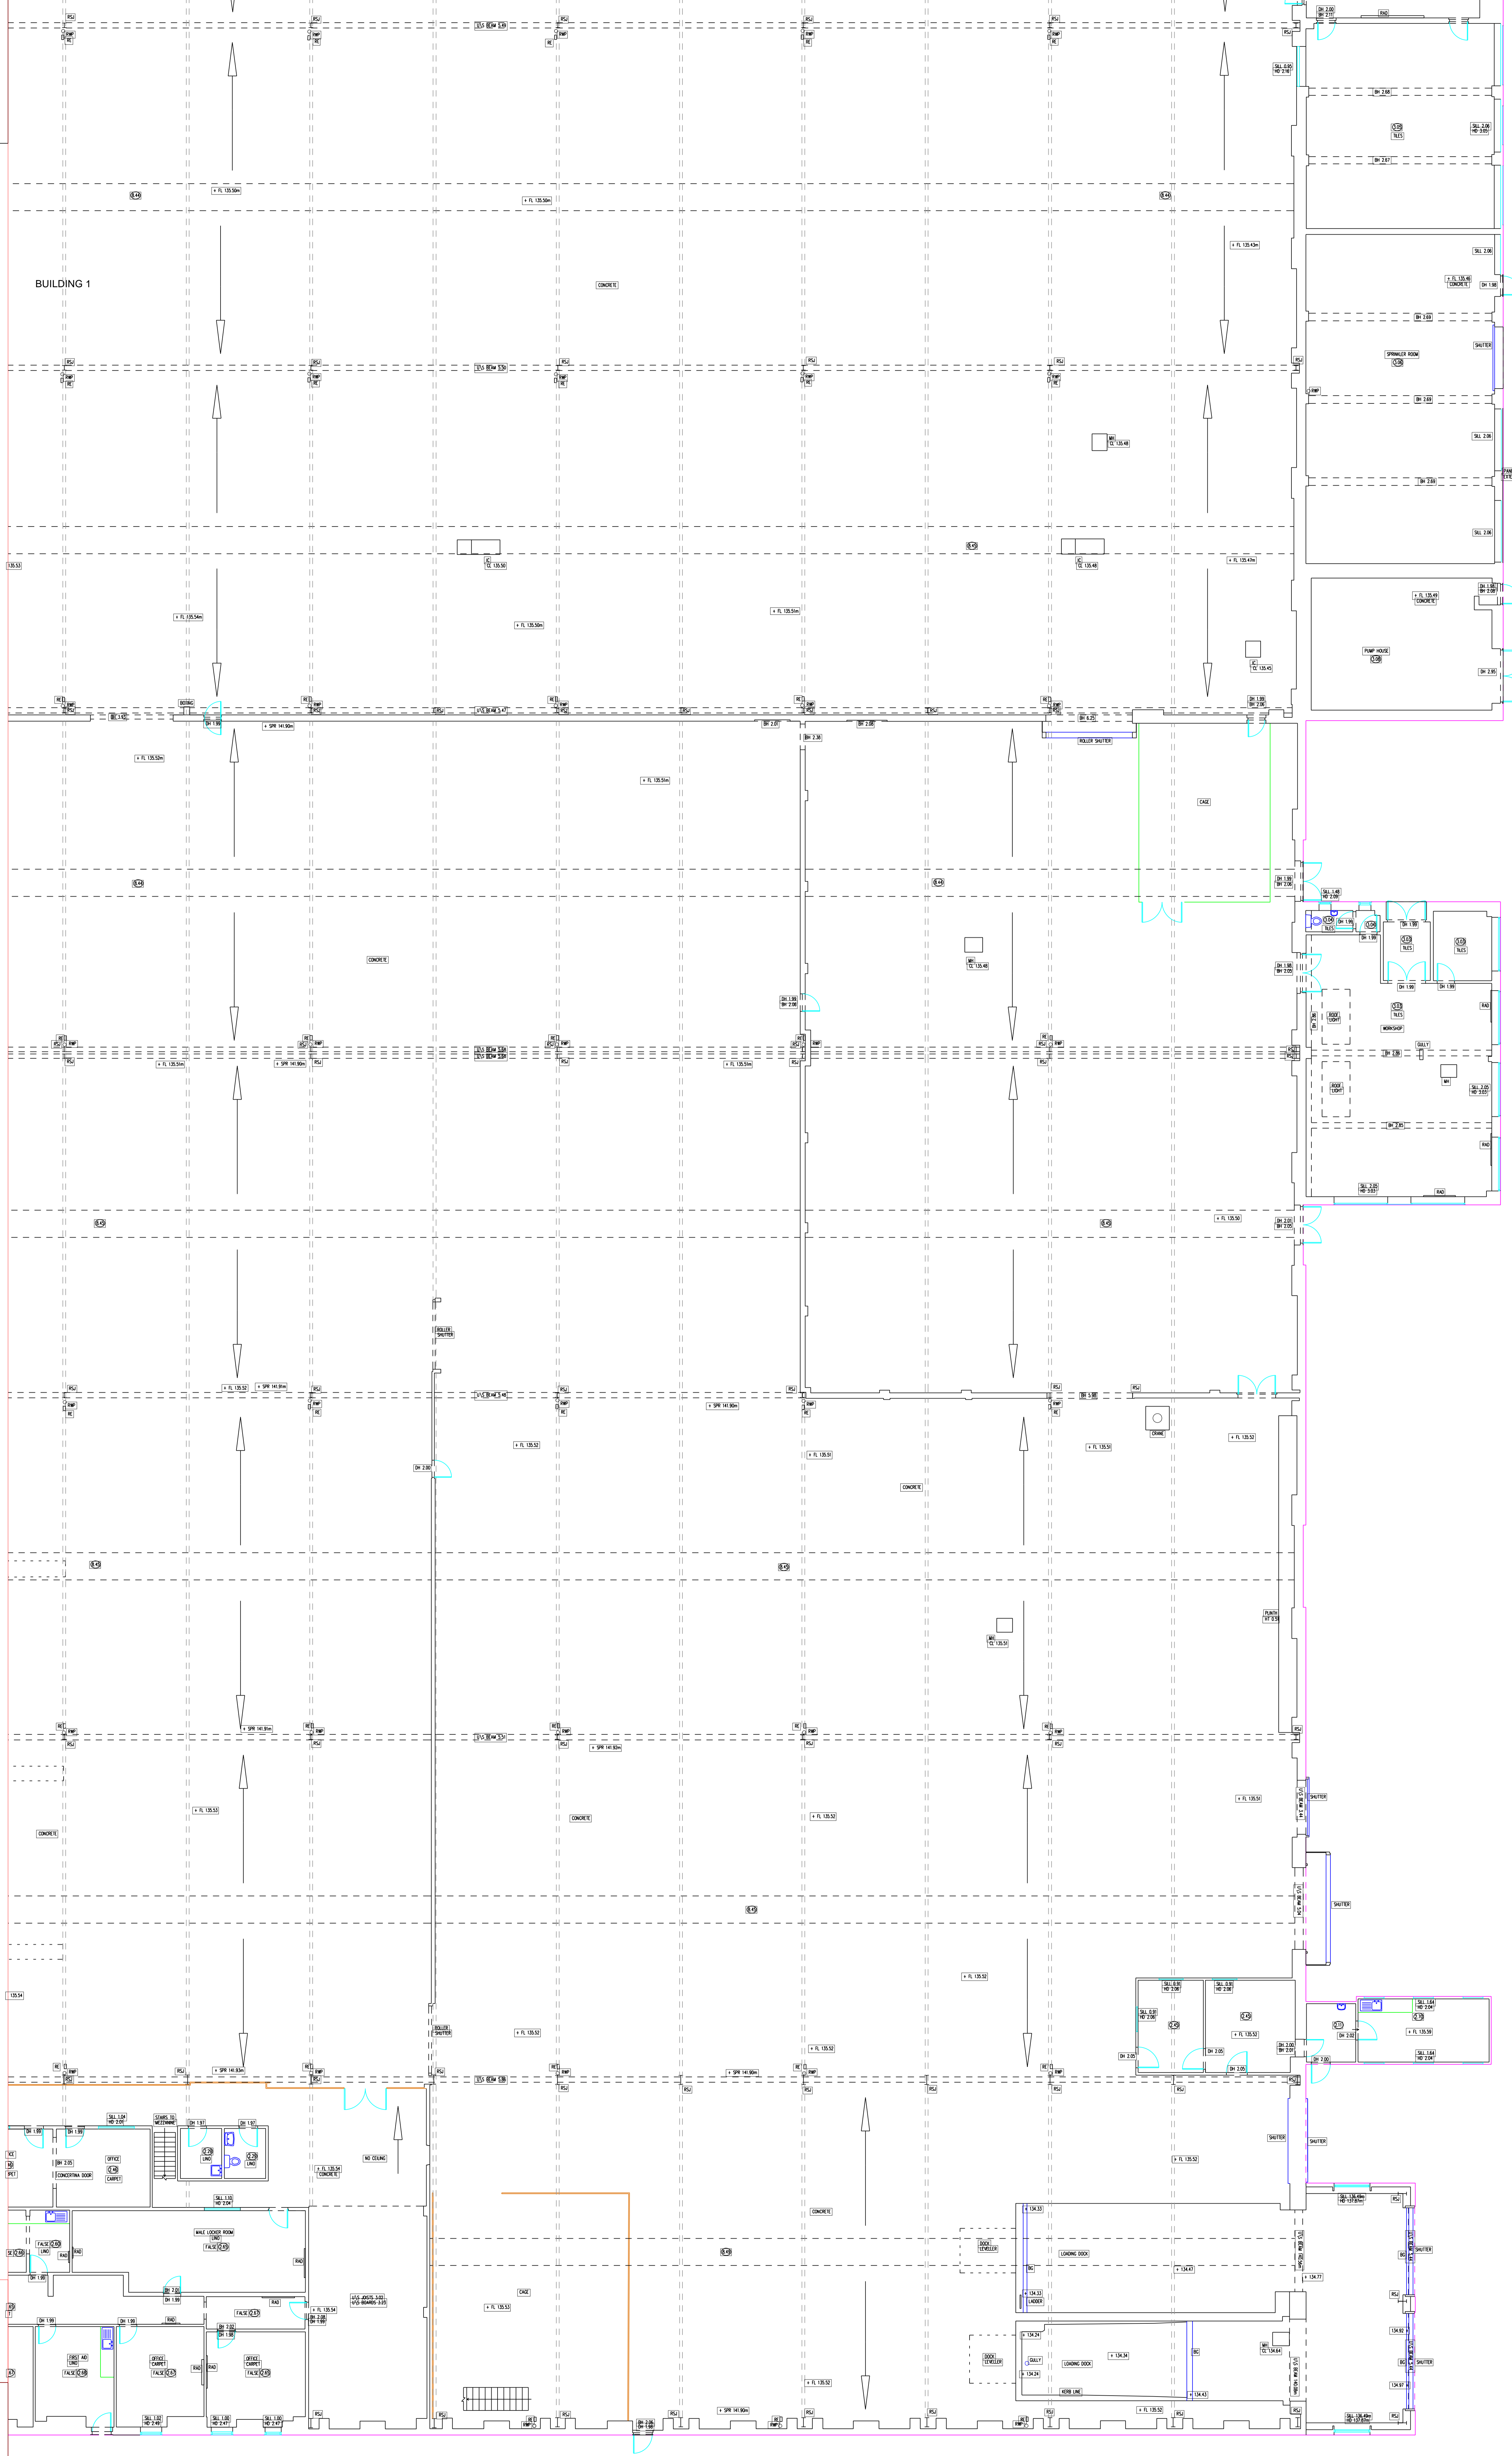

SHEET LAYOUT

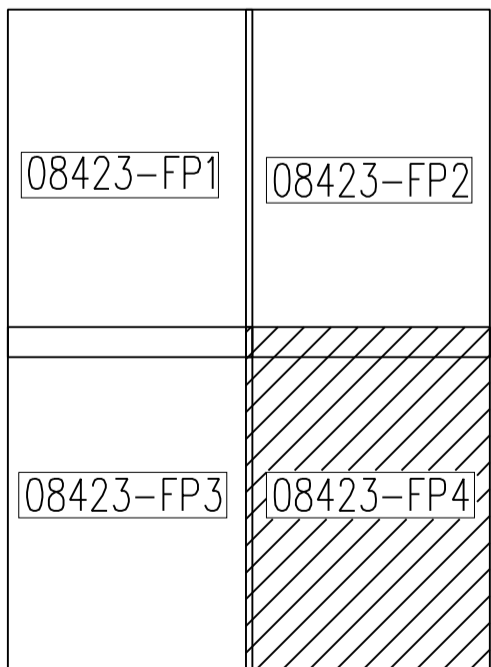

NOTES

SURVEY TIED INTO NATIONAL GRID DATUM AND ORGANIC DATUM FOR HEIGHT USING GPS EQUIPMENT UTILISING THE TRIMBLE VISO VIEW SYSTEM FOR REAL TIME KINEMATIC RTK CORRECTIONS NATIONAL GRID SCALE FACTOR HAS NOT BEEN APPLIED TO THE SURVEY UNLESS SPECIFIED

DRAINAGE AND SERVICE INFORMATION SHOWN ON THIS SURVEY HAS BEEN OBTAINED BY VISUAL INSPECTION ONLY. ALTHOUGH ALL POSSIBLE CARE HAS BEEN TAKEN TO ENSURE THAT DETAILS SHOWN ARE CORRECT, WE ARE UNABLE TO ACCEPT ANY RESPONSIBILITY FOR COSTS ARISING OUT OF ANY ERRORS OR OMISSIONS.

COPYRIGHT: THIS DRAWING MAY NOT BE REPRODUCED IN ANY FORM WHATSOEVER WITHOUT THE CONSENT OF C.J. SURVEYS LTD.

C.J. SURVEYS LTD
 LAND | BUILDING | ENGINEERING
 PROFESSIONAL MEASURED SURVEYS

DATE: AUG 2023 DRAWN: MK SHEET SIZE: SCALE: 1:100
 PROJECT: BUILDING 1 GROUND FLOOR PLAN
 DART PRODUCTS EUROPE LTD, BIRMINGHAM, B44 9RE DRAWING NO: 08423FP4