



LEGEND			
	Telephone Socket		Key symbol for Direction
	Enter Net Socket		Key symbol for Direction
	TV Aerial Socket		Key symbol for Direction
	Fire Alarm Break Glass		Key Symbol for Floor TO Ceiling heights
	Fire Alarm Sounder		Beam to Soffit
	Smoke Detector		Change in Floor Construction etc
	Illuminated Fire Exit Sign		Hidden Detail under Stairs etc
	Single Supply Socket		Overhead Beams, Roof Lights etc
	Double Supply Socket		Finished floor level etc
	Single Gang Light Switch		Height of window sill etc
	Pushbutton Switch		Height of window head etc
	Rotator		

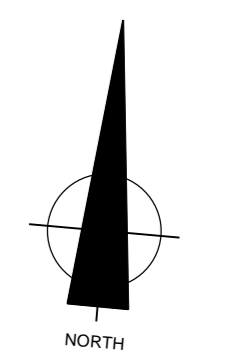

SHEET LAYOUT BUILDING 1 FIRST FLOOR

08423-FP7


08423-FP8

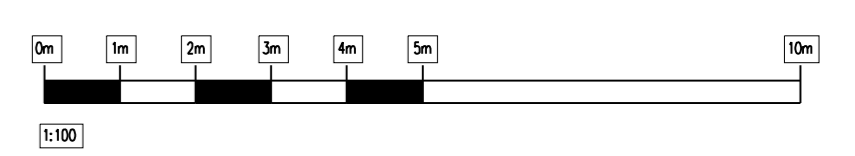

NOTES

SURVEY TIED INTO NATIONAL GRID OSGN22 AND OSGM22 DATUM FOR HEIGHT USING GPS EQUIPMENT UTILISING THE TRIMBLE VRS NOW SYSTEM FOR REAL TIME KINEMATIC (RTK) CORRECTIONS NATIONAL GRID SCALE FACTOR HAS NOT BEEN APPLIED TO THE SURVEY UNLESS SPECIFIED

DRAINAGE AND SERVICE INFORMATION SHOWN ON THIS SURVEY HAS BEEN OBTAINED BY VISUAL INSPECTION ONLY. ALTHOUGH ALL POSSIBLE CARE HAS BEEN TAKEN TO ENSURE THAT DETAILS SHOWN ARE CORRECT, WE ARE UNABLE TO ACCEPT ANY RESPONSIBILITY FOR COSTS ARISING OUT OF ANY ERRORS OR OMISSIONS. COPYRIGHT: THIS DRAWING MAY NOT BE REPRODUCED IN ANY FORM WHATSOEVER WITHOUT THE CONSENT OF C.J SURVEYS LTD.

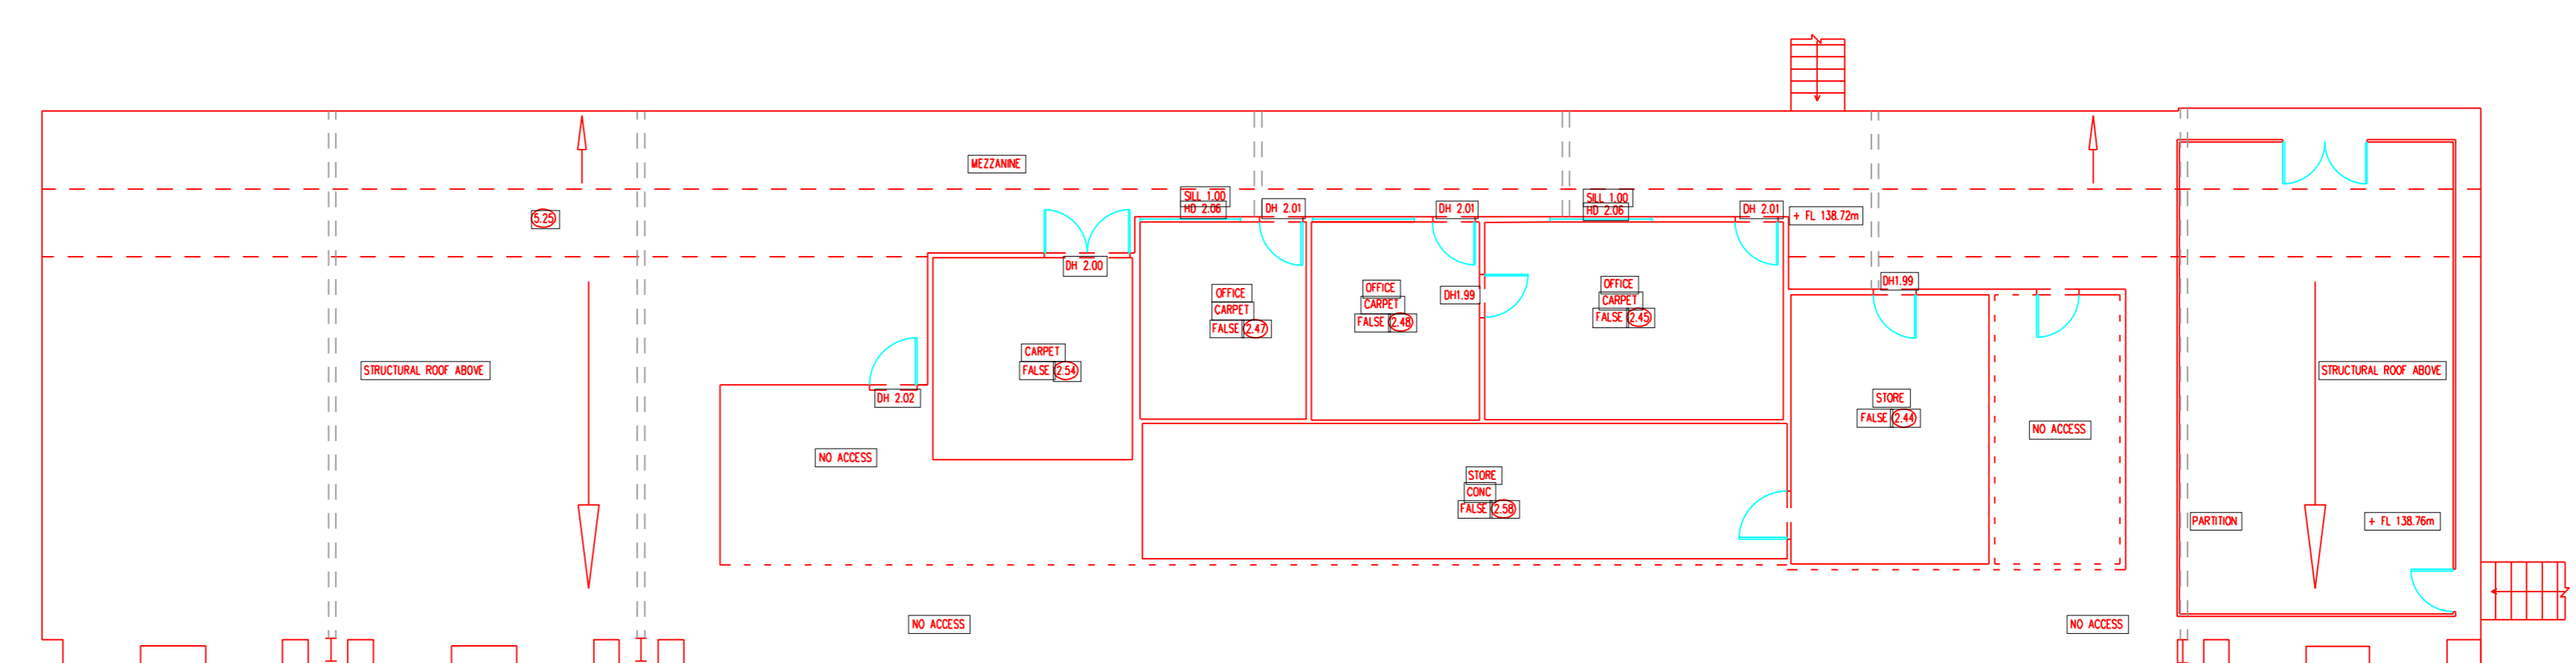

C J SURVEYS LTD LAND BUILDING ENGINEERING PROFESSIONAL MEASURED SURVEYS	CLIENT	[REDACTED]
	PROJECT BUILDING 1 MEZZANINE FLOOR PLAN DART PRODUCTS EUROPE LTD, BIRMINGHAM, B64 9RE	DATE AUG 2023 DRAWN GSC/J SHEET SIZE A0 SCALE 1:100