
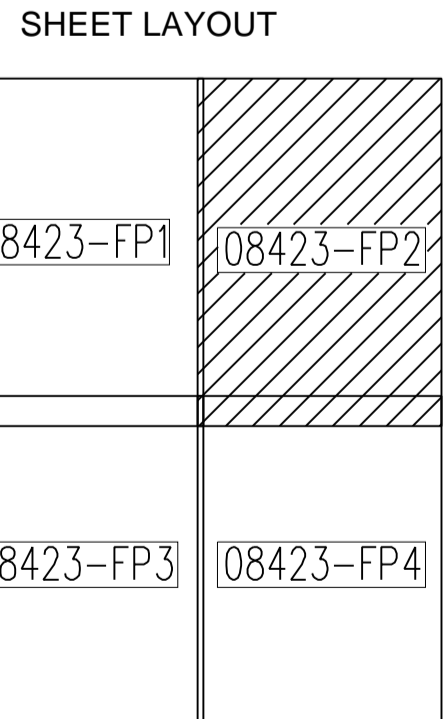


LEGEND	
⬇	Telephone Socket
⬆	Fire Alarm Socket
⬇	TV Aerial Socket
⬇	Fire Alarm Break Glass
⬆	Fire Alarm Sounder
⬆	Fire Alarm Detector
⬆	Handmanned Fire Call Sign
⬆	Single Supply Socket
⬆	Double Supply Socket
⬆	Single Gang Light Switch
⬆	Double Gang Light Switch
⬆	Substation
⬆	Key symbol for Direction of main conduit
⬆	Key symbol for Direction of main cable
⬆	Key symbol for Floor to Ceiling height
⬆	Key symbol for Floor to Floor height
⬆	Key symbol for Floor to Ceiling height
⬆	Change in Floor Construction etc.
⬆	Hidden Work under Stairs etc.
⬆	Overhead Service Post Light etc.
⬆	Finished Top level when
⬆	Height of window sill and window head when etc.

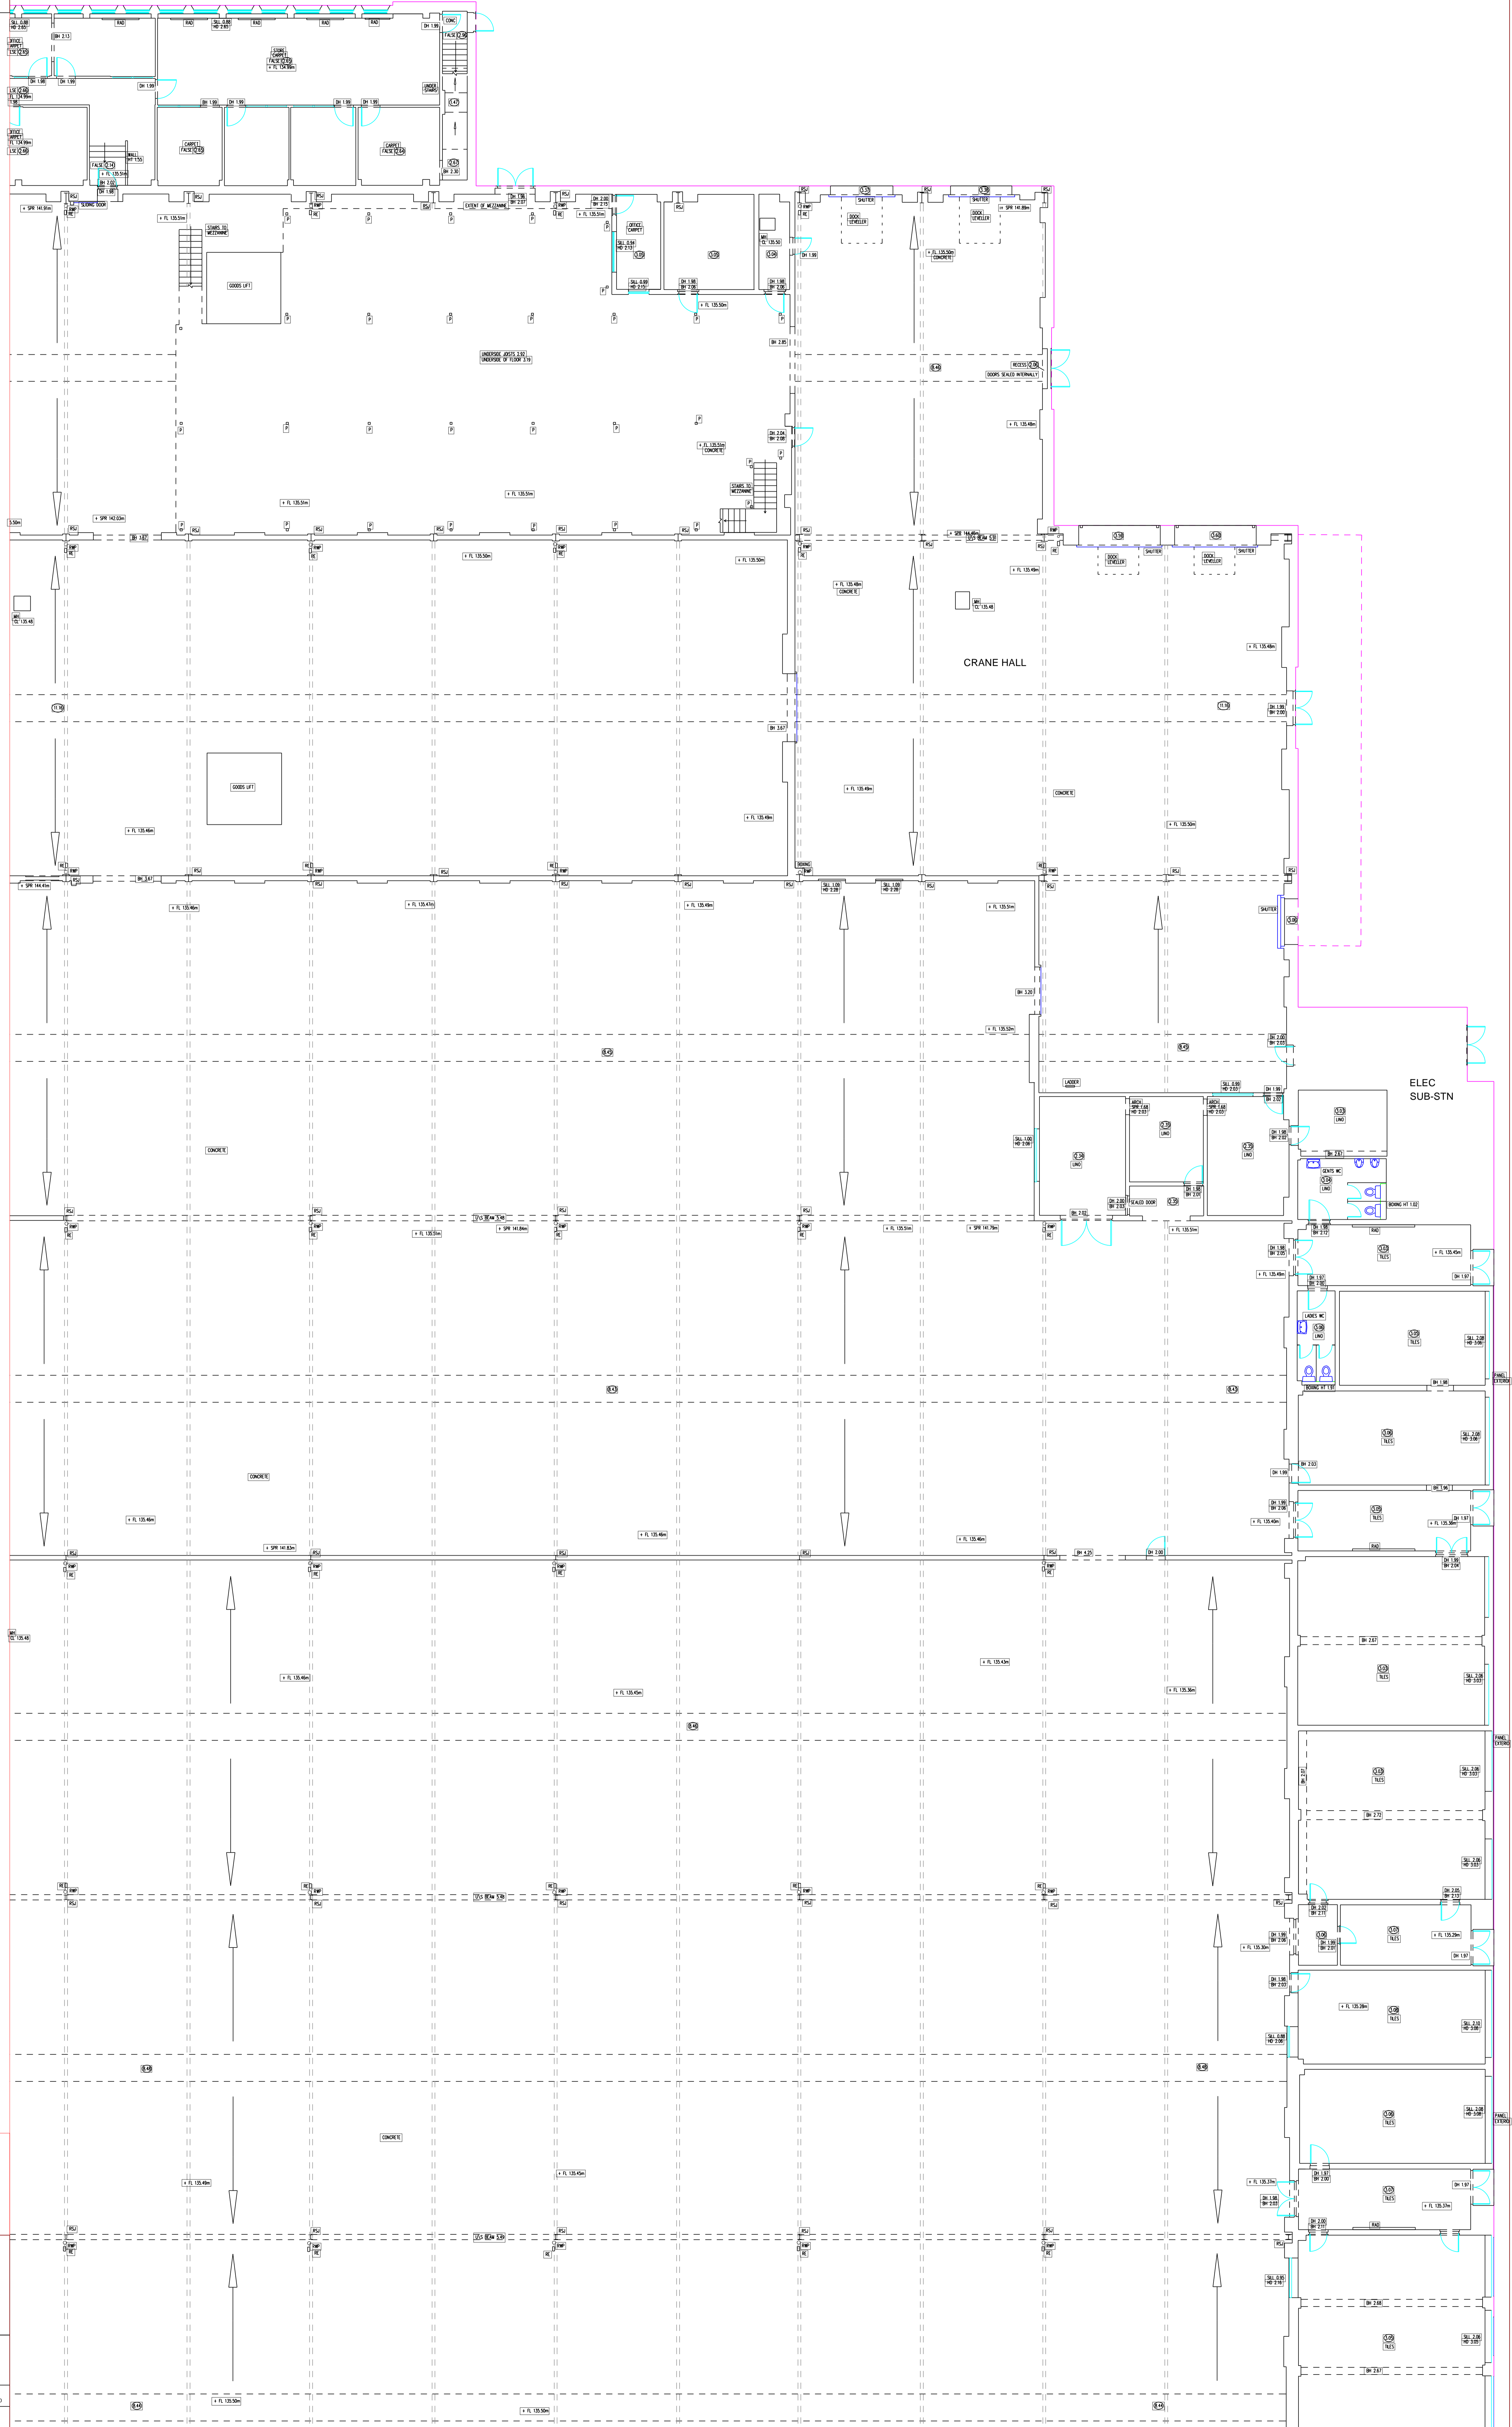

NOTES

SURVEY TIED INTO NATIONAL GRID DATUM AND OSNAD DATUM FOR HEIGHT USING GPS EQUIPMENT UTILISING THE TRIMBLE VISO VIEW SYSTEM FOR REAL TIME KINEMATIC RTK CORRECTIONS NATIONAL GRID SCALE FACTOR HAS NOT BEEN APPLIED TO THE SURVEY UNLESS SPECIFIED

DRAINAGE AND SERVICE INFORMATION SHOWN ON THIS SURVEY HAS BEEN OBTAINED BY VISUAL INSPECTION ONLY. ALTHOUGH ALL POSSIBLE CARE HAS BEEN TAKEN TO ENSURE THAT DETAILS SHOWN ARE CORRECT, WE ARE UNABLE TO ACCEPT ANY RESPONSIBILITY FOR COSTS ARISING OUT OF ANY ERRORS OR OMISSIONS.

COPYRIGHT: THIS DRAWING MAY NOT BE REPRODUCED IN ANY FORM WHATSOEVER WITHOUT THE CONSENT OF C.J. SURVEYS LTD.

C.J. SURVEYS LTD
LAND | BUILDING | ENGINEERING
PROFESSIONAL MEASURED SURVEYS

DATE: AUG 2023
DRAWN: MK
SHEET SIZE: A3
SCALE: 1:100

PROJECT: BUILDING 1 GROUND FLOOR PLAN
DART PRODUCTS EUROPE LTD, BIRMINGHAM, B44 9PE
DRAWING NO: 08423FP2