

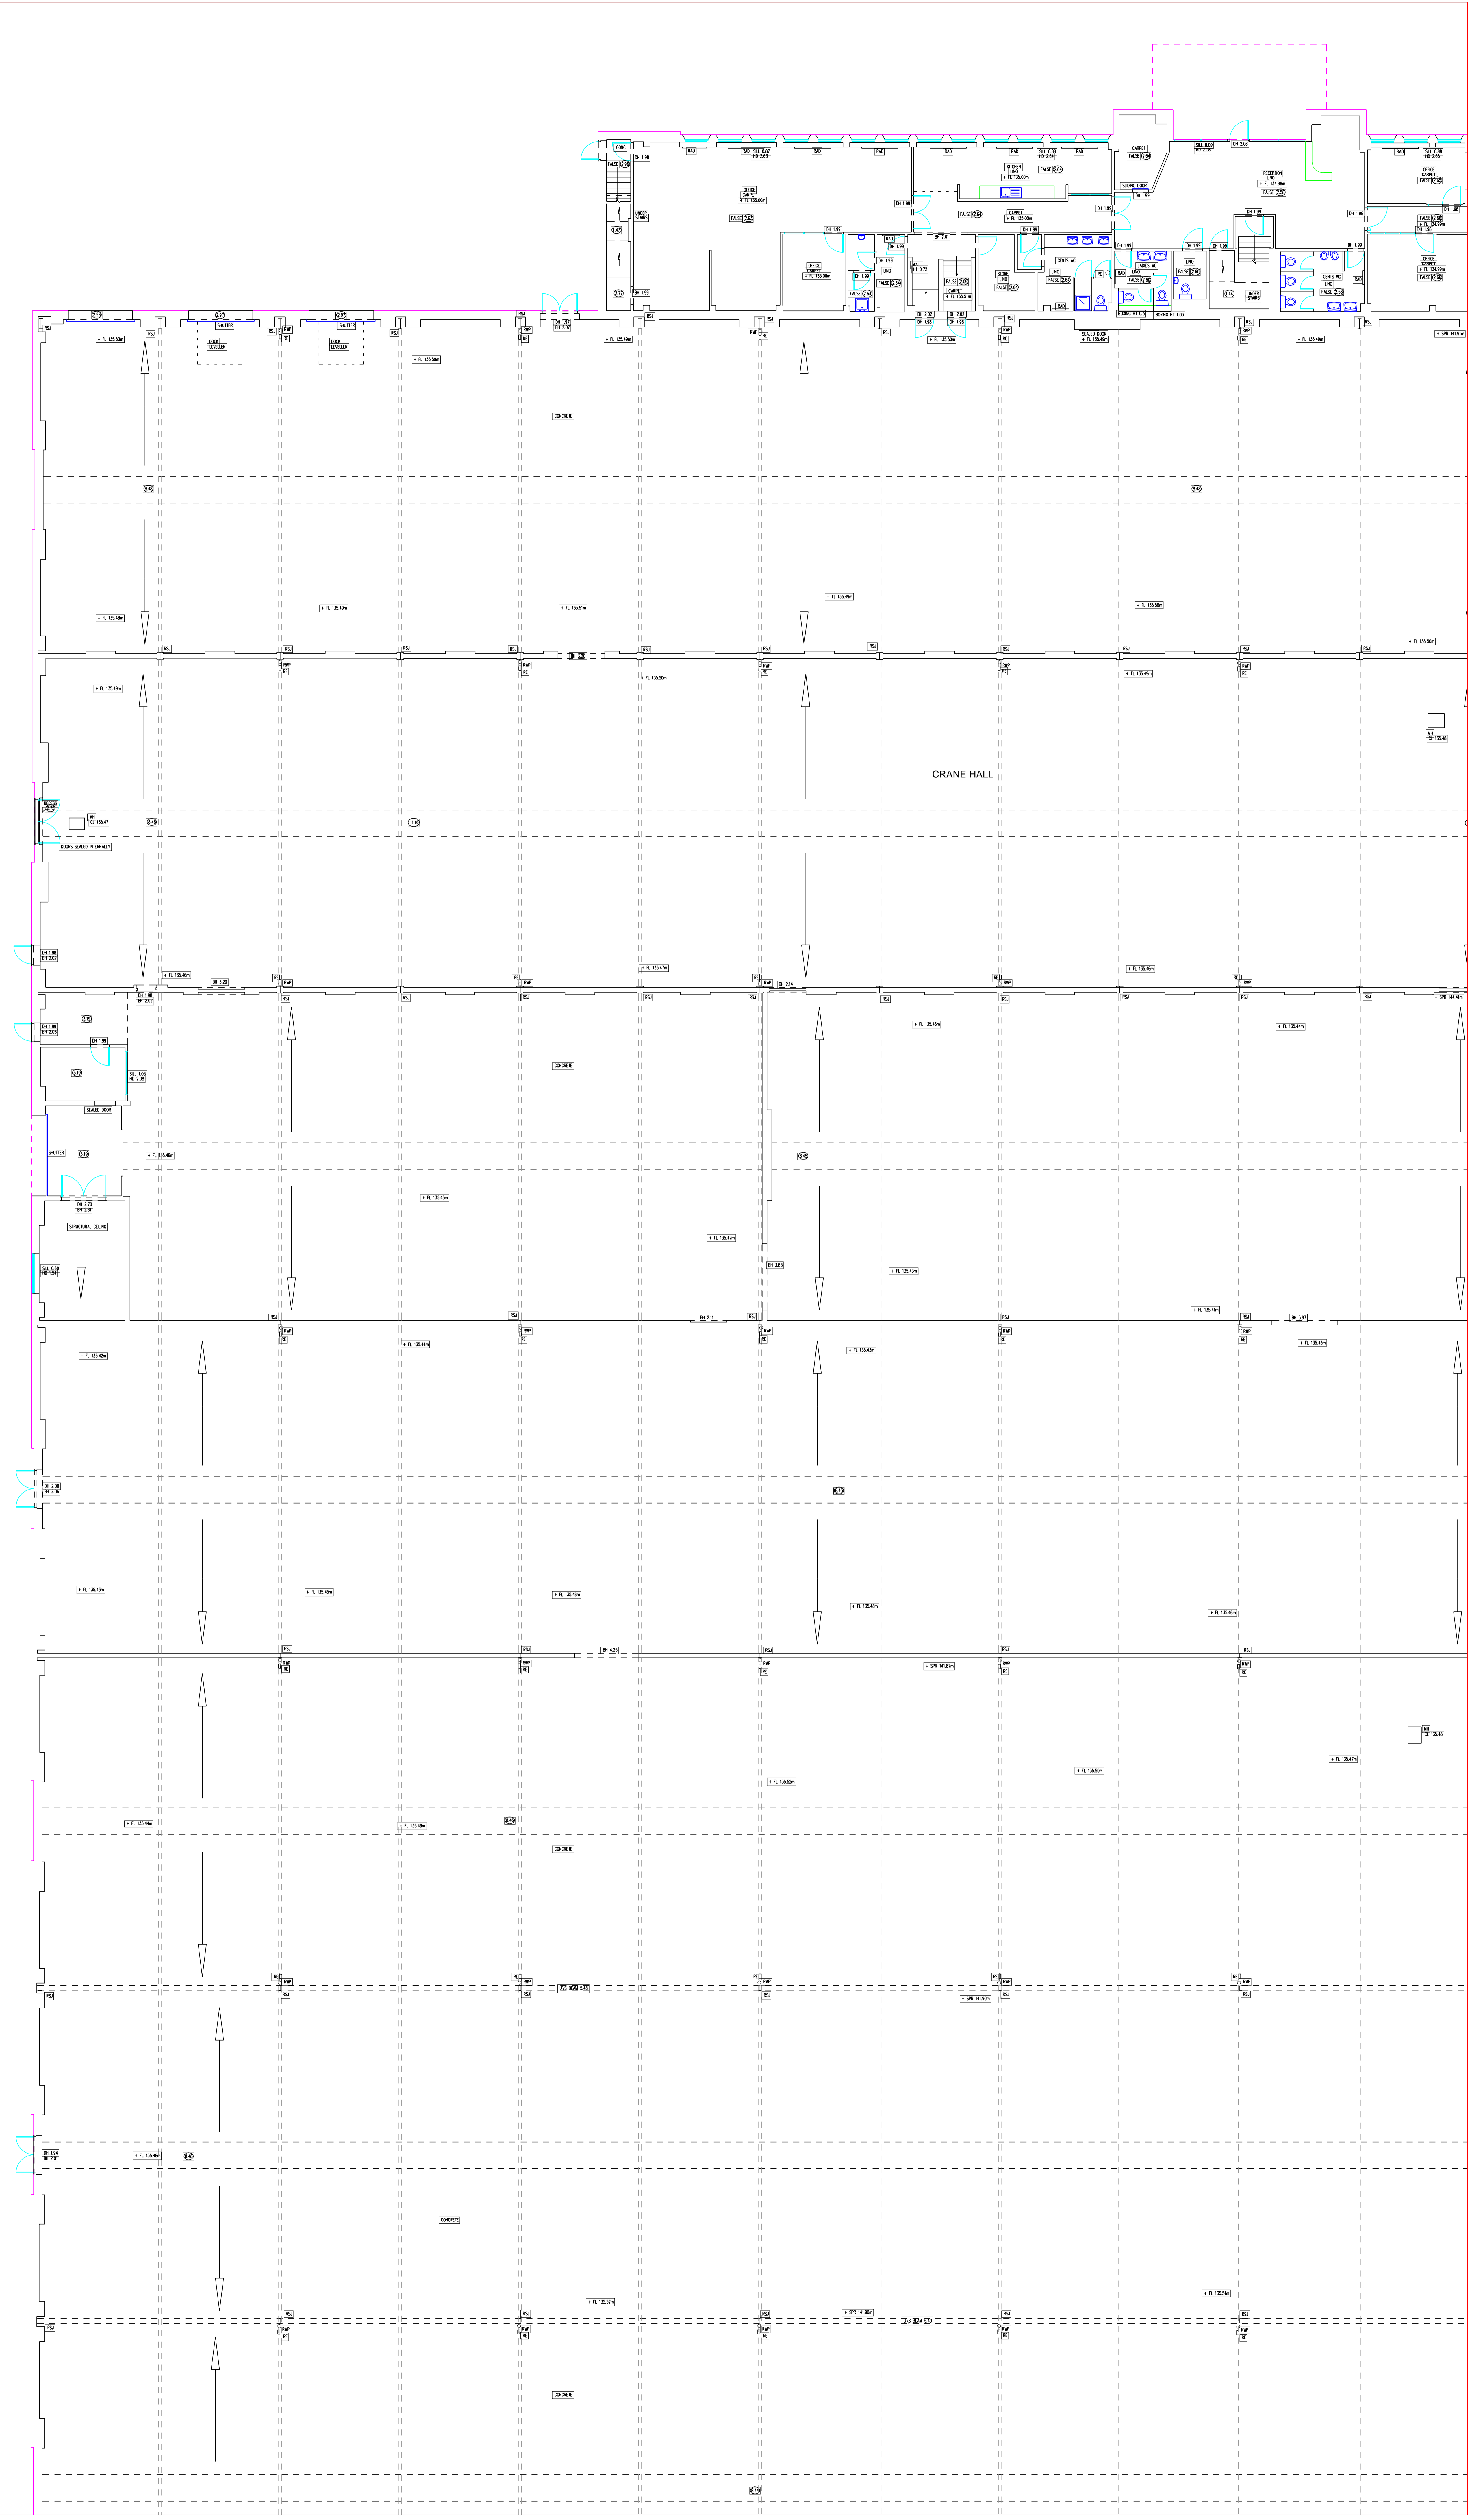
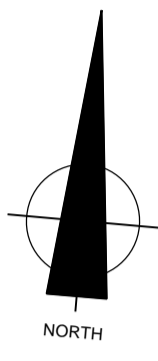


LEGEND			
○	Telephone Socket	→	Key Symbol For Direction
○	Fire Alarm Sounder	→	OF SIGHT CORNER
○	TV Area Socket	→	Key Symbol - IN DIRECTION
○	Fire Alarm Break Glass	→	OF SIGHT FROM END
○	Fire Alarm Sounder	→	Key Symbol For First 10 Ceiling Height
○	Change in Floor Construction etc	→	With A Safe Detail
○	Humourated Fire Exit Sign	→	"Hidden Detail" Under Stairs etc
○	Single Supply Socket	→	"Overhead" Signs, Post Signs etc
○	Double Supply Socket	→	Finished Top level when
○	Single Open Light Switch	→	Height of window sill and
○	Double Open Light Switch	→	finish level when
○	Substituted		

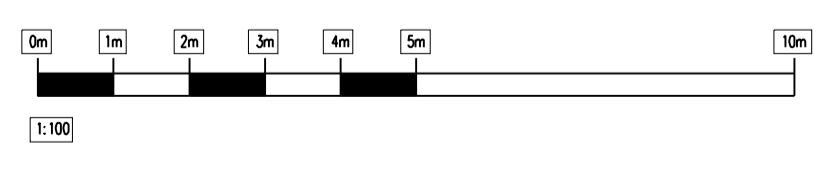

SHEET LAYOUT

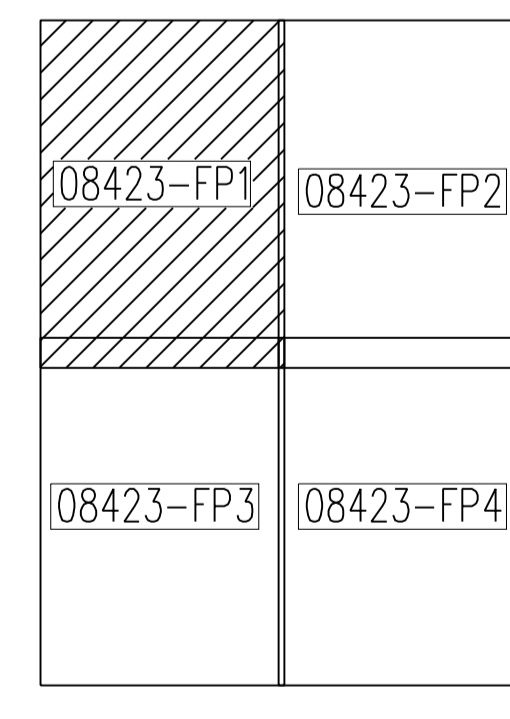

**NOTES**

SURVEY TIED INTO NATIONAL GRID DATUM AND OBTAINED FOR HEIGHT USING GPS EQUIPMENT UTILISING THE TRIMBLE VISO VIEW SYSTEM FOR REAL TIME KINEMATIC WITH CORRECTIONS NATIONAL GRID SCALE FACTOR HAS NOT BEEN APPLIED TO THE SURVEY UNLESS SPECIFIED

DRAINAGE AND SERVICE INFORMATION SHOWN ON THIS SURVEY HAS BEEN OBTAINED BY VISUAL INSPECTION ONLY. ALTHOUGH ALL POSSIBLE CARE HAS BEEN TAKEN TO ENSURE THAT DETAILS SHOWN ARE CORRECT, WE ARE UNABLE TO ACCEPT ANY RESPONSIBILITY FOR COSTS ARISING OUT OF ANY ERRORS OR OMISSIONS.

COPYRIGHT: THIS DRAWING MAY NOT BE REPRODUCED IN ANY FORM WHATSOEVER WITHOUT THE CONSENT OF C.J. SURVEYS LTD.

<b>C.J. SURVEYS LTD</b>		CLIENT: [REDACTED]	
LAND   BUILDINGS   ENGINEERING PROFESSIONAL MEASURED SURVEYS			
DATE	DRAWN	SHEET SIZE	SCALE
AUG 2023	MK	GS	1:100
PROJECT BUILDING 1 GROUND FLOOR PLAN		DRAWING NO. 08423FP1	
DART PRODUCTS EUROPE LTD, BIRMINGHAM, B44 9RE			