




Key
NTS

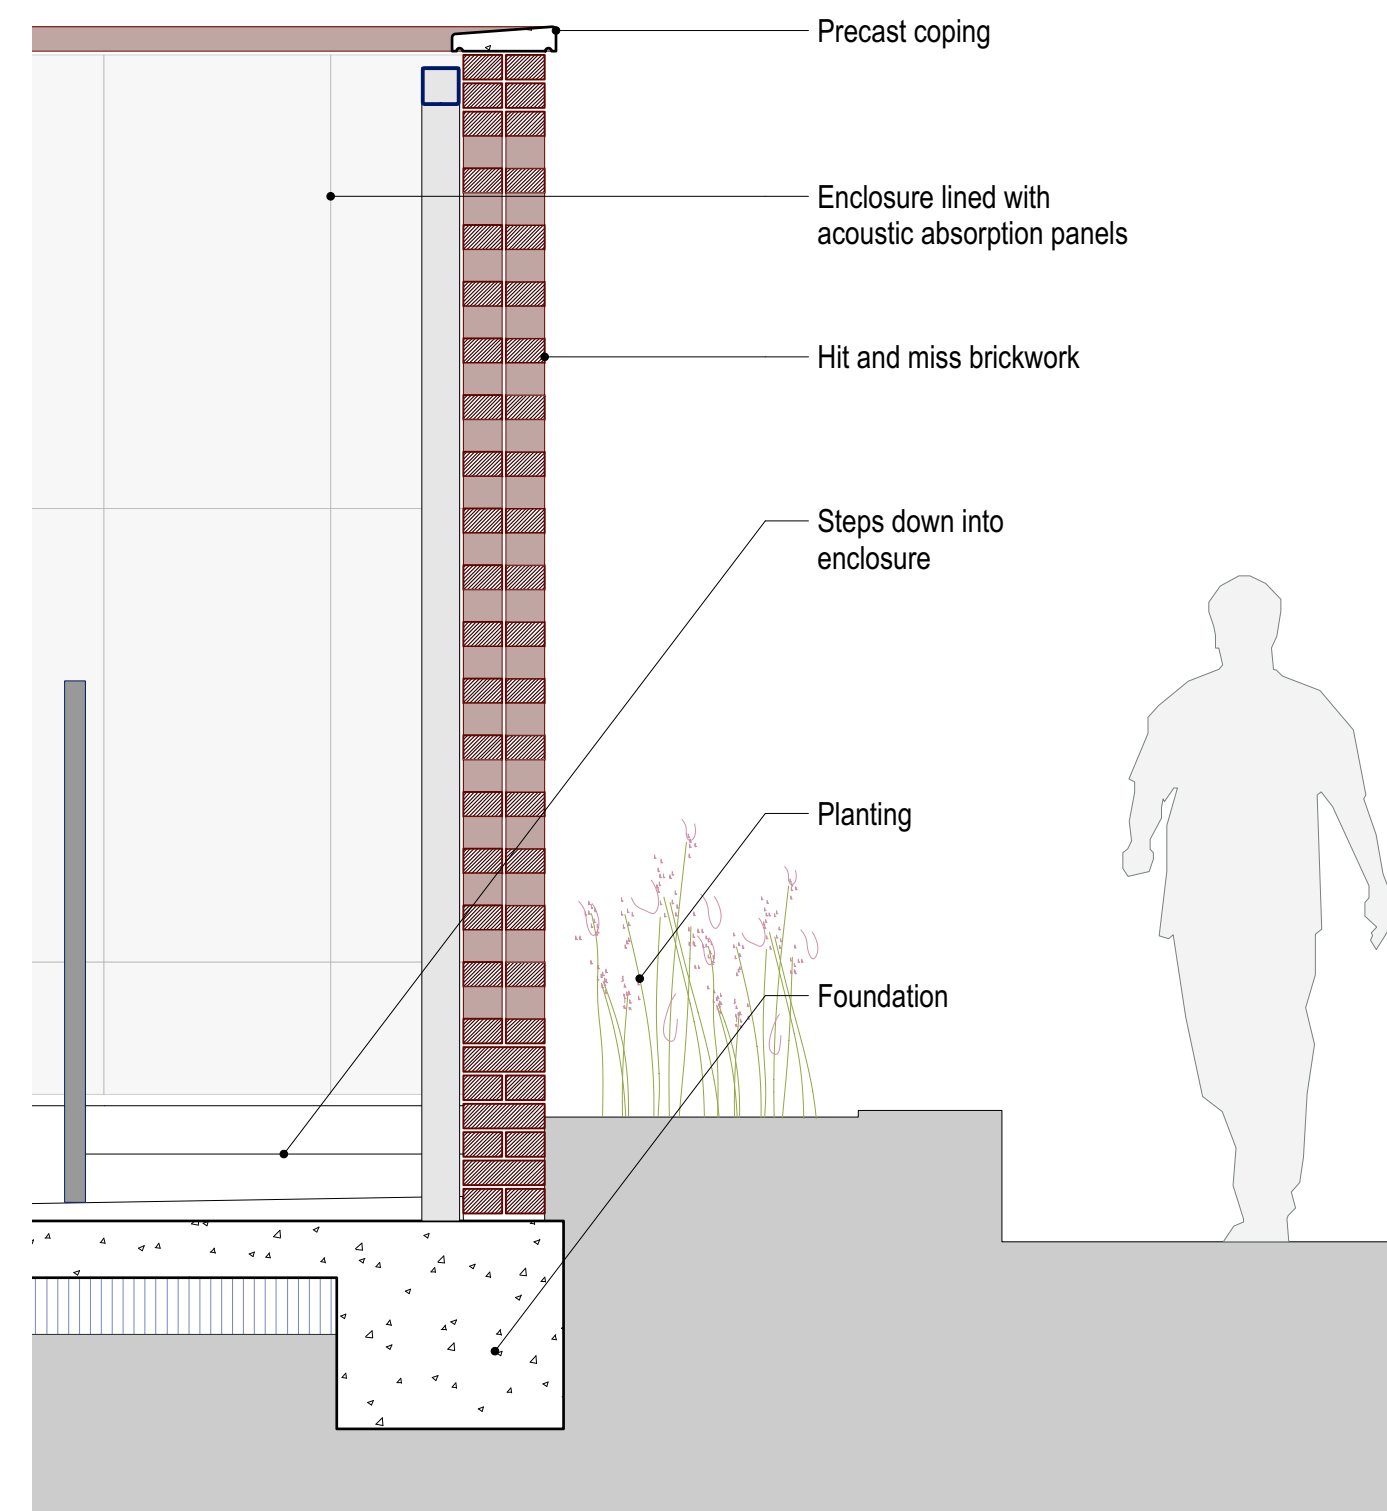


North Quad ASHP Enclosure
D01 - West Elevation Section
1:20 @ A1

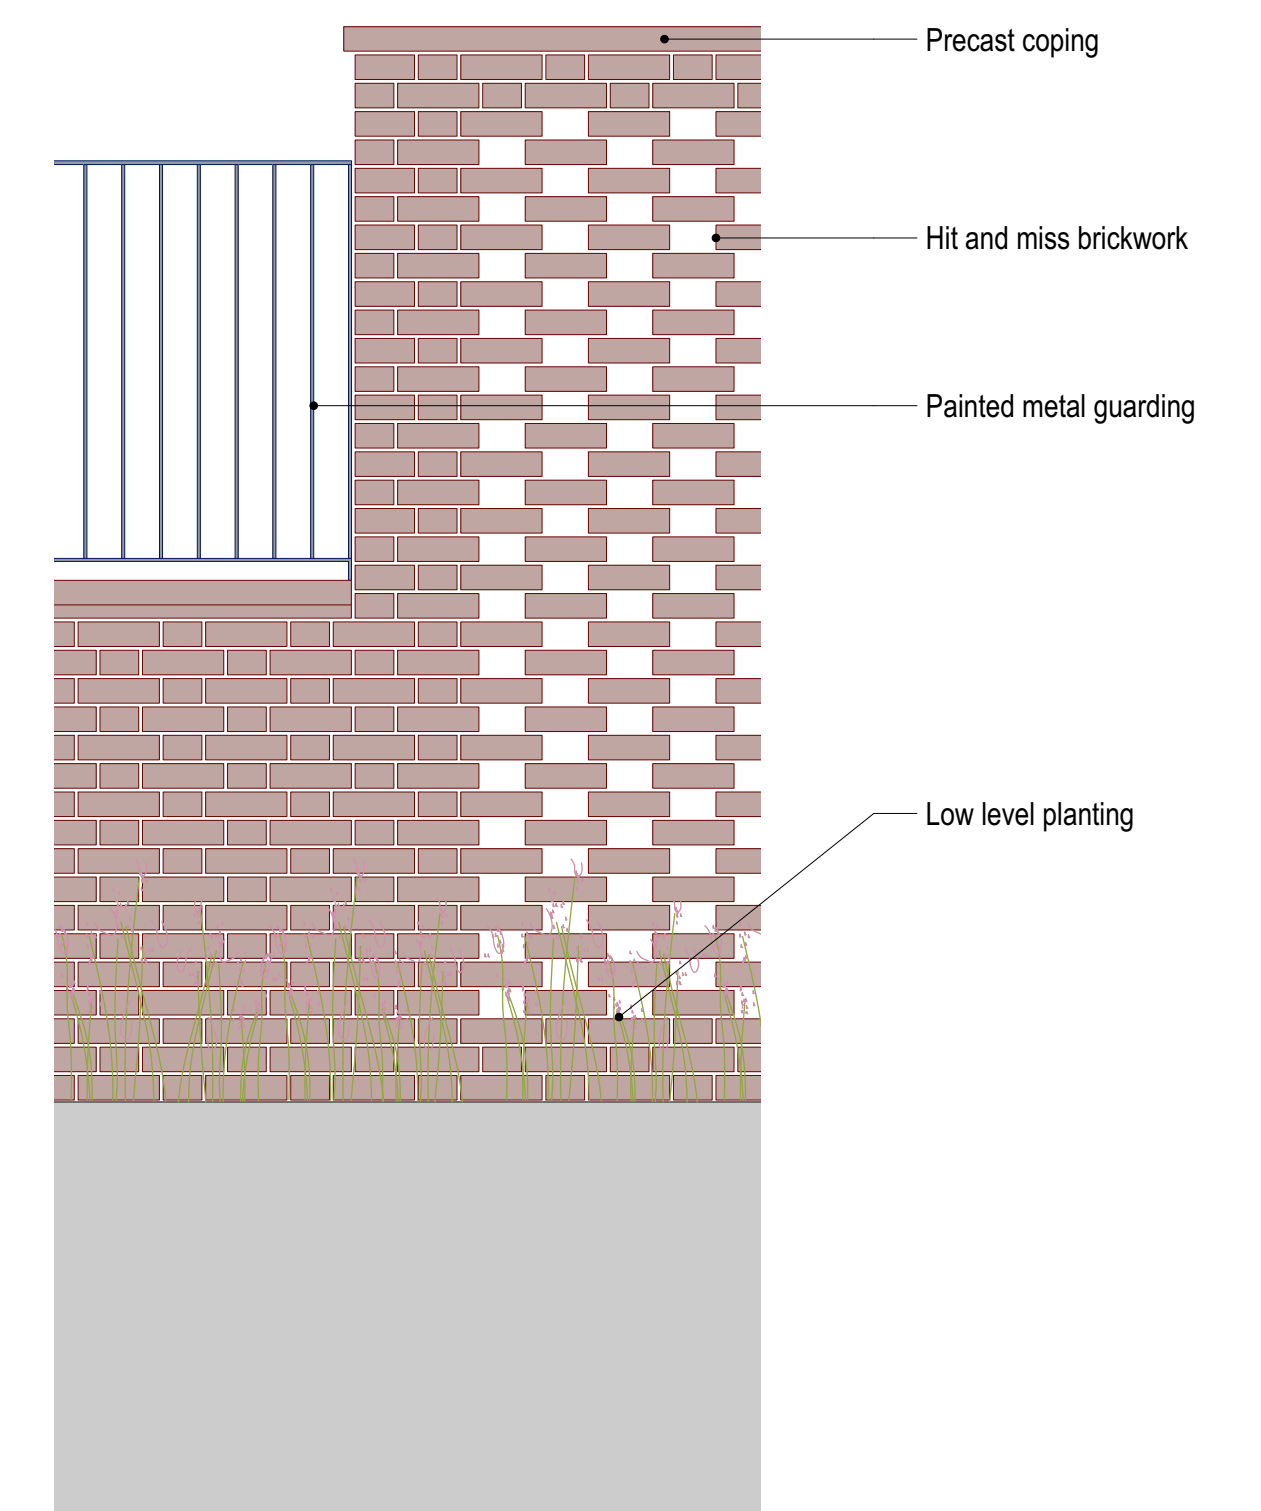

North Quad ASHP Enclosure
D02 - West Elevation Detail
1:20 @ A1

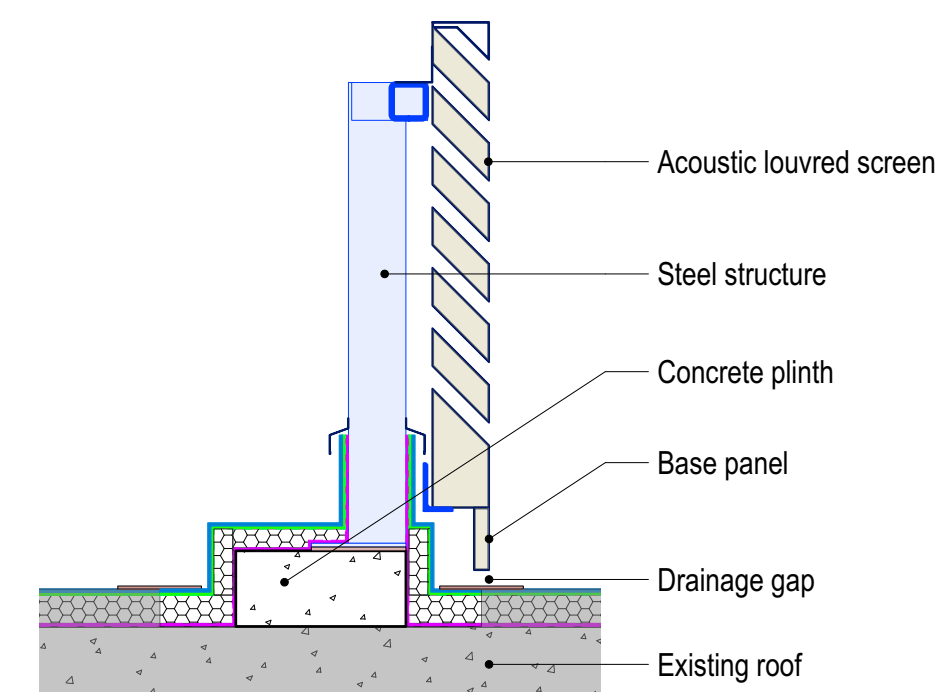

McGowin Library ASHP Enclosure
D03 - Typical Section
1:20 @ A1

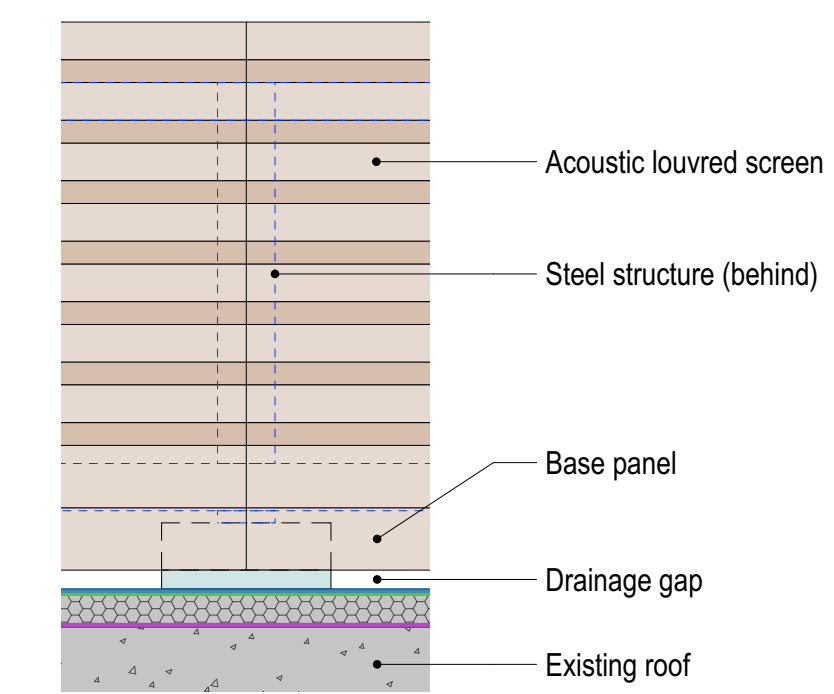

McGowin Library ASHP Enclosure
D04 - Typical Detailed Elevation
1:20 @ A1

PLANNING

Notes

Rev Date Amendment
-- 15.03.24 Issued for Planning

WALTERS
& COHEN
ARCHITECTS

2 Wilkin Street
London
NW5 3NL
Telephone 020 7428 9751
mail@waltersandcohen.com

Pembroke College - Old Quad

Air source heat pump enclosure details

Checked by TL	Scale 1:20 @A1	Date Drawn 04.12.23	Job No. 2313	Drawing No. PD-3010	Revision -
------------------	-------------------	------------------------	-----------------	------------------------	---------------

© This drawing is copyright. Check dimensions on site