 
 



# Site Plan for Heat Pump

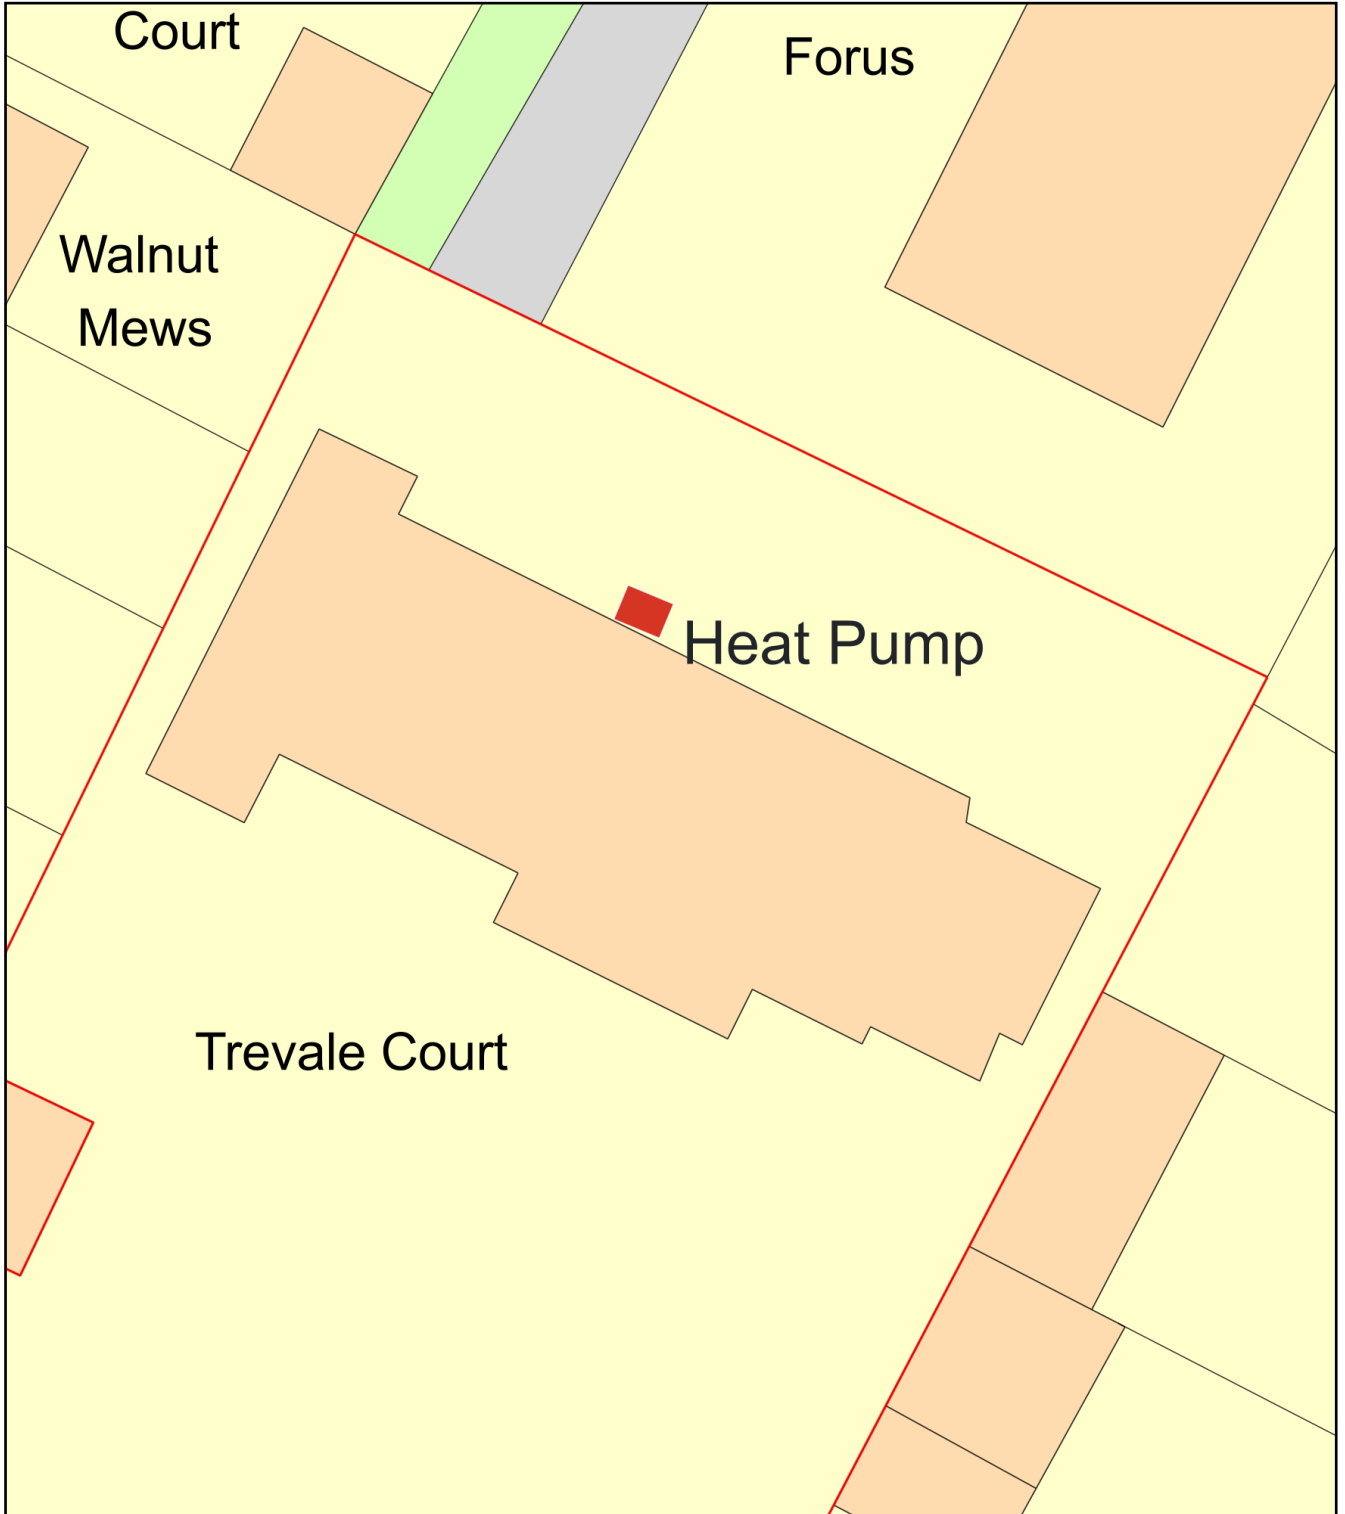

Plan Produced for: Thanet District Council

Date Produced: 21 Mar 2024

Plan Reference Number: TQRQM24081133824029

Scale: 1:200 @ A4