

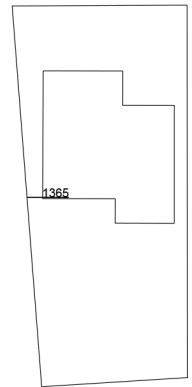


The use of this data by the recipient acts as an agreement of the following statements. Do not use this data if you do not agree with any of the following statements:-


Only scale for Planning purposes. Use figured dimensions in all cases. Check all dimensions on site. Report any discrepancies in writing to the author of this drawing before proceeding.

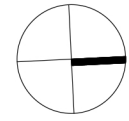

Glannel Hill View  
Site layout (not to scale)

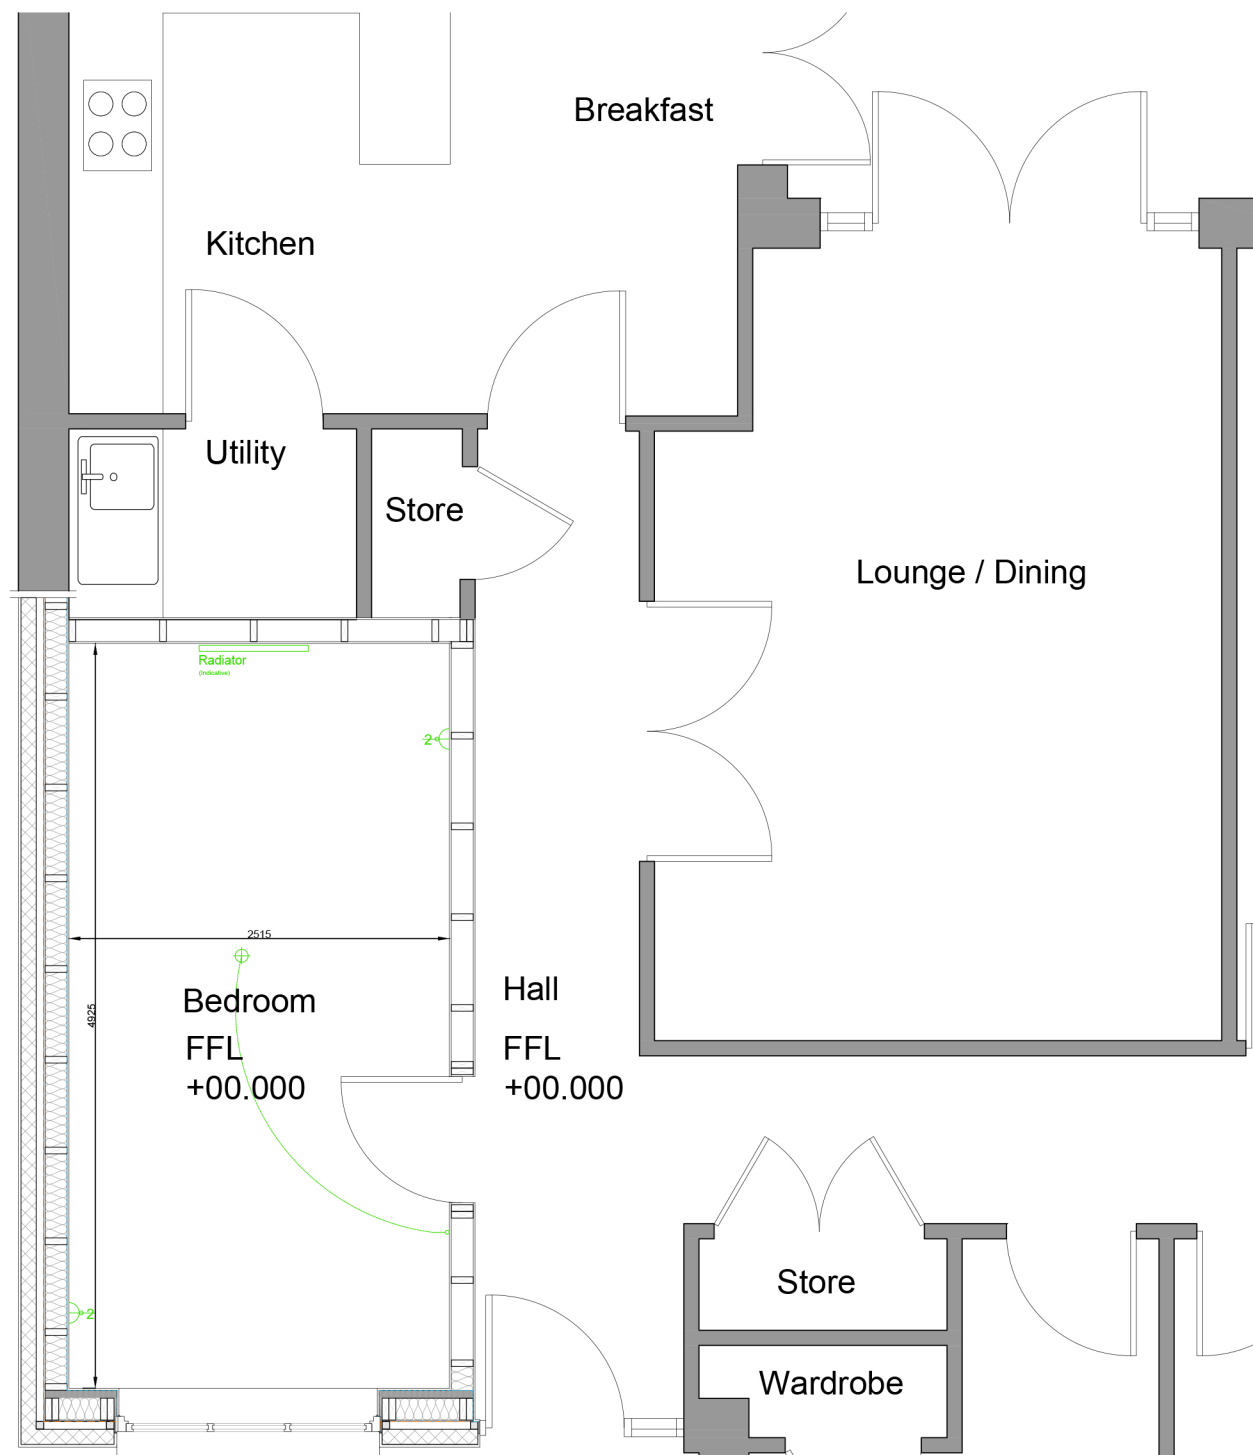

PROPOSED GROUND FLOOR PLAN

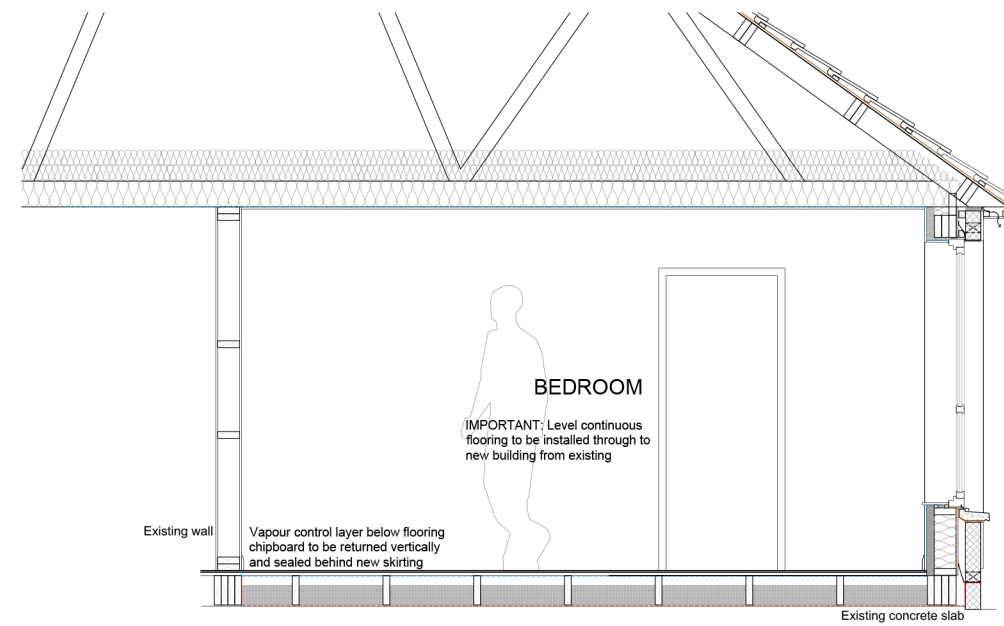

PROPOSED SECTION A-A



PROPOSED FRONT ELEVATION



PROPOSED FRONT ELEVATION (1:100)

**NOTE: ELECTRICAL LEGEND**

	SINGLE SWITCHED WALL SOCKET		TV AERIAL POINT
	DOUBLE SWITCHED WALL SOCKET		IMMERSION HEATER AND THERMOSTAT
	DOUBLE SWITCHED WALL SOCKET WITH USB		MECHANICAL EXTRACT FAN
	SINGLE SWITCHED WALL SOCKET 1200MM ABOVE FLOOR LEVEL		DOOR BELL PUSH
	DOUBLE SWITCHED WALL SOCKET 1200MM ABOVE FLOOR LEVEL		DOOR BELL CHIME
	DOUBLE SWITCHED WALL SOCKET WITH USB 1200MM ABOVE FLOOR LEVEL		THERMOSTAT
	SINGLE SWITCHED FUSE SPUR BELOW WORKTOP LEVEL		SECURITY ALARM
	FUSE SPUR		CONSUMER UNIT
	SINGLE SWITCHED FUSE SPUR AT HIGH LEVEL FOR EXTRACT FAN		TELEPHONE POINT
	1 GANG LIGHT SWITCH		WiFi POINT / DATA SOCKET
	2 GANG LIGHT SWITCH		COOKER SWITCH
	1GANG 2 WAY LIGHT SWITCH		MECHANICAL EXTRACT FAN COOKER HOB HOOD
	2 GANG 2 WAY LIGHT SWITCH		SMOKE DETECTOR AND FIRE ALARM SOUNDER
	1GANG 3 WAY LIGHT SWITCH		COMBINED SMOKE / HEAT DETECTOR AND FIRE ALARM SOUNDER
	2 GANG 3 WAY LIGHT SWITCH		CARBON MONOXIDE DETECTOR
	1 GANG PULL CORD LIGHT SWITCH		CARBON DIOXIDE DETECTOR
	EXTERNAL LIGHT - WITH PIR DETECTOR		
	EXTERNAL LIGHT - BULKHEAD TYPE		
	RECESSED DOWNLIGHTER		
	LIGHT POINT - PENDANT HOLDER		

**NOTE: RADIATOR SIZES AND LAYOUT TO BE CONFIRMED BY HEATING CONTRACTOR / AND APPROVED BY ARCHITECT AND CLIENT, RADIATOR SPEC / APPEARANCE TO BE APPROVED BY CLIENT**

Amendment  
Status  
**PLANNING**  
Project  
**41 Gannel Hill View**

Drawing  
**Proposed Drawings**

Drawing No.	Originator	Level	Type	Role	Number
Project ID					<b>PL_003</b>
Project	Scale at A3	Drawn By	Status	Revision	
<b>099</b>	<b>1:50</b>	<b>JL</b>			