


This drawing is copyright and may not be copied or reproduced without the written consent of JRM Architectural.

The contractor is responsible for all setting-out and must check all dimensions and levels prior to work being put in hand.

The drawing should not be scaled, Only written dimensions are to be taken for this project.


The designer is to be immediately notified of any suspect omissions or discrepancies.

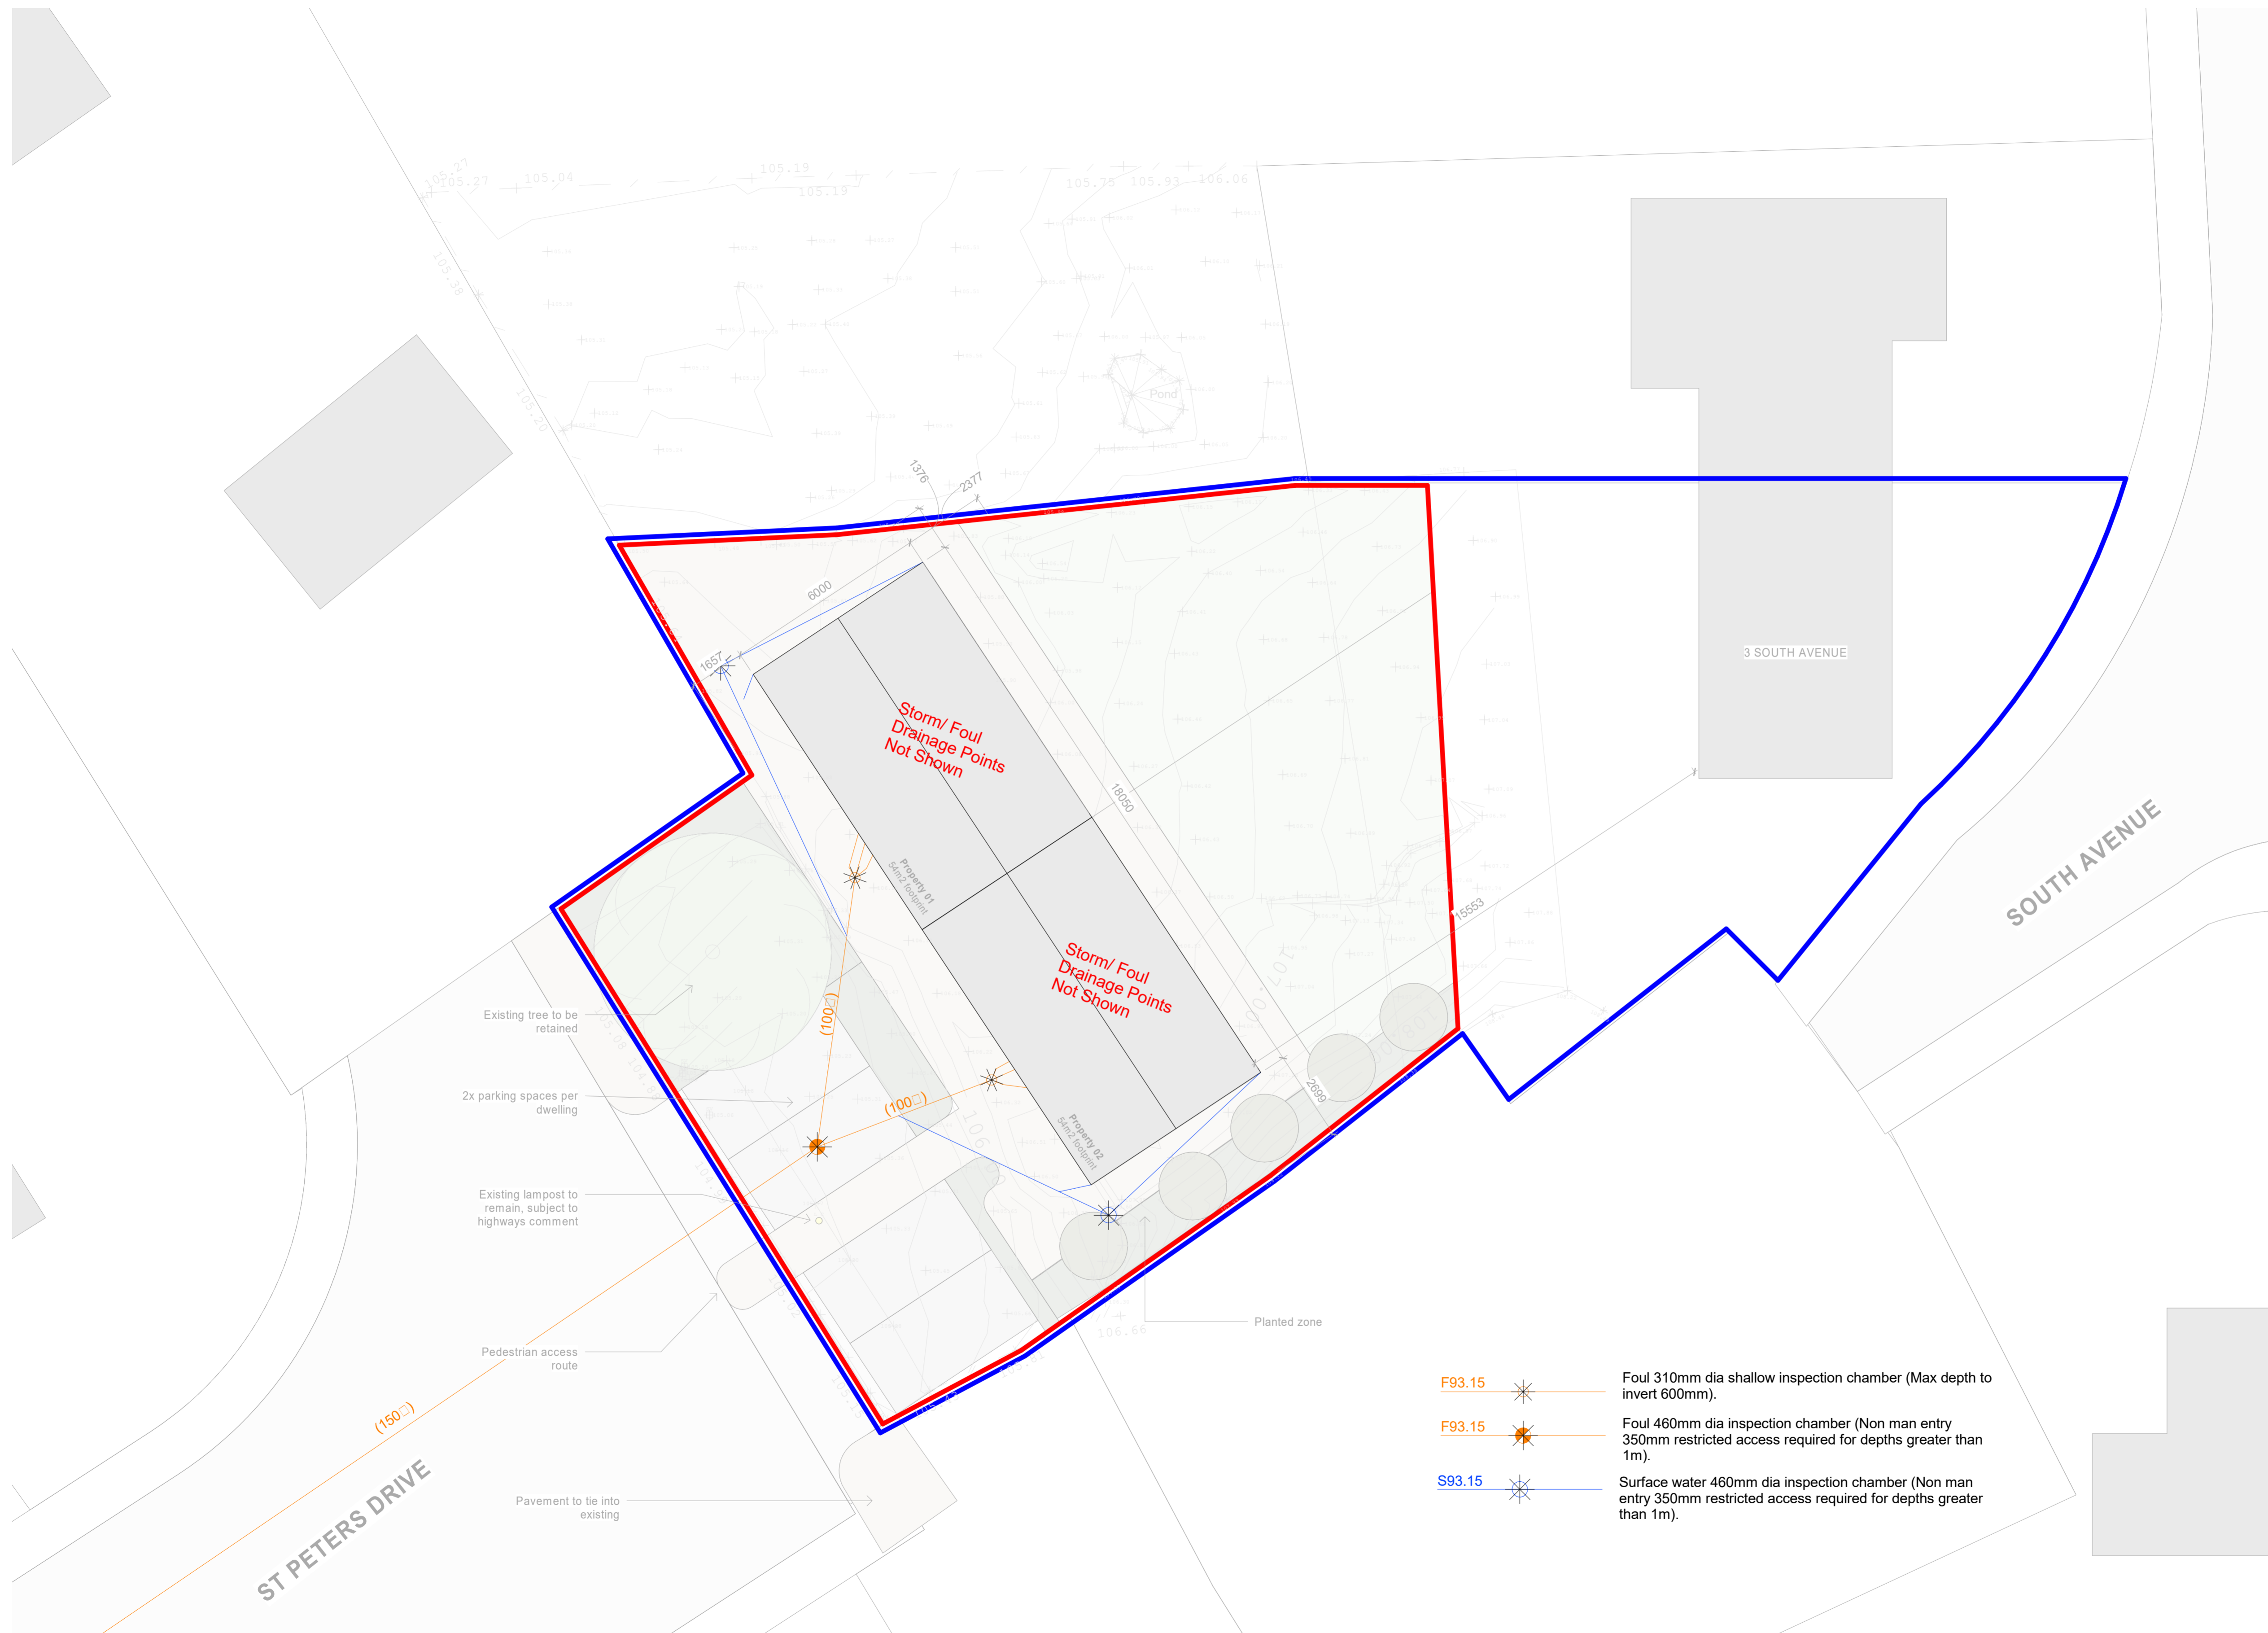

- F93.15 ✖ Foul 310mm dia shallow inspection chamber (Max depth to invert 600mm).
- F93.15 ✖ Foul 460mm dia inspection chamber (Non man entry 350mm restricted access required for depths greater than 1m).
- S93.15 ✖ Surface water 460mm dia inspection chamber (Non man entry 350mm restricted access required for depths greater than 1m).

1 Proposed Drainage Layout
1 : 100

SCALE 1:100

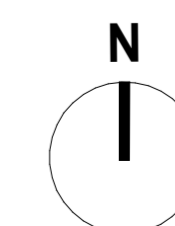

Rev	Description	Date
1	Preliminary issue of planning drawings	03/03/24
2	Blue line boundary added in addition to red line as requested by planners	06/04/24

JRM JRM Architectural
JRMarchitectural@outlook.com

PROJECT
3 South Avenue

TITLE
Proposed Drainage Layout

STATUS
PLANNING

DRAWN BY JM	CHECKED BY SC	DATE 03/03/2024
SCALE (@ A1) As indicated		PROJECT NUMBER 0014
DRAWING NUMBER 0014-JRM-A-XX-DR-A-70-100		REV 2