
 



# HEATH ROAD

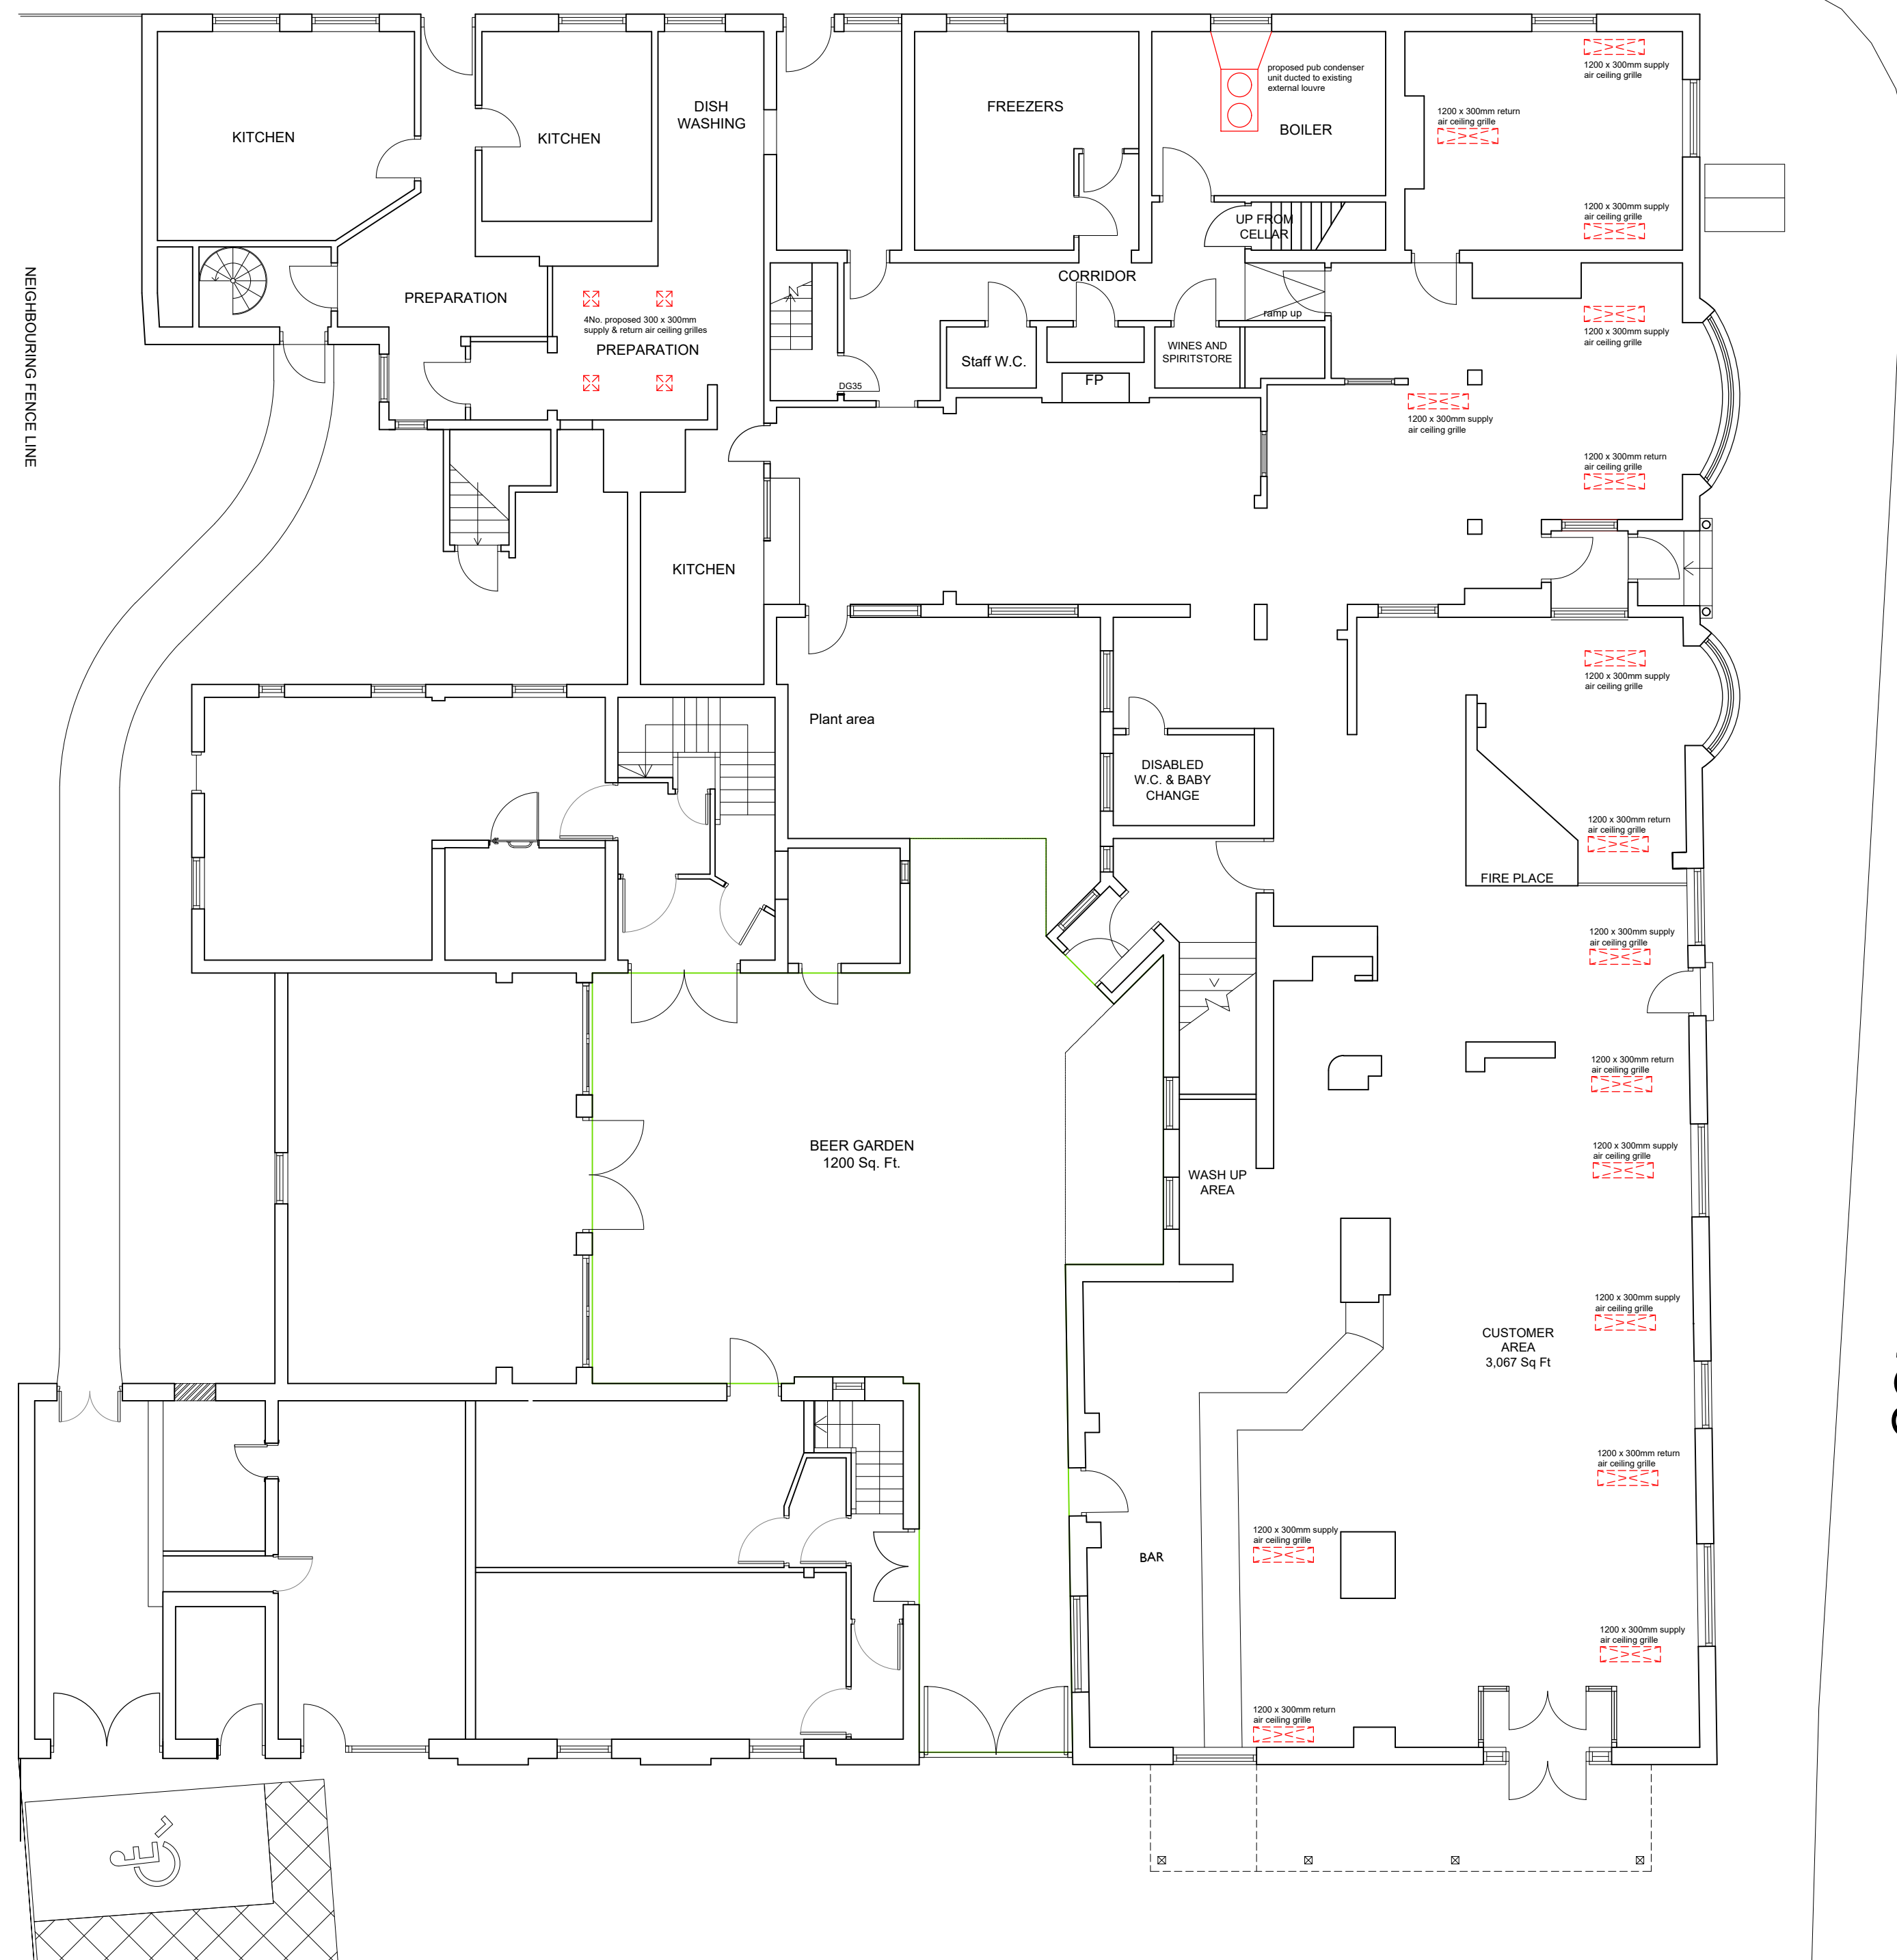

Proposed Ground Floor plan



Existing side elevation (to Heath Road)

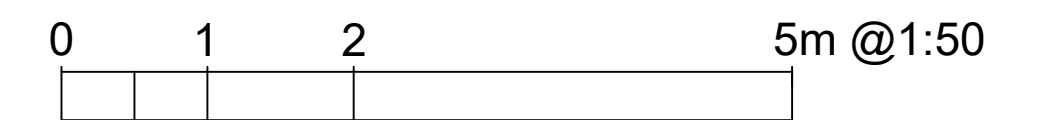

COLLEGE STREET

- Notes re proposed aircon works to existing ground floor-
- All refrigerant pipework to be run above first floor structure.
  - All ductwork & fan coils to be above first floor structure.
  - All supply & return air grilles to be mounted between floor joists.
  - All grilles to be 300 x 1200mm Linear Bar Grille type, 4900 Series, as manufactured by Advanced Air
  - Fresh air ductwork to be run above above first floor with VAM unit.

**rjd**  
 Architectural Design & Project Management  
 info@rjd.eu.com

project  
**RED LION, 3 COLLEGE STREET  
 PETERSFIELD, HAMPSHIRE  
 GU31 4AE**

client  
**J D WETHERSPOON PLC** Pub No. **6232**

drawing  
**PROPOSED AIRCON ALTERATIONS-  
 GF PLAN & SIDE ELEVATION**

date scale drawing no. rev  
 Mar 24 1:100 @A1 6232/402 -