


SURFACE WATER SEWER LONG SECTIONS PIPE RUN 1.000 (WEST INLET)
 (SCALE: Horizontal 1:500, Vertical 1:100)

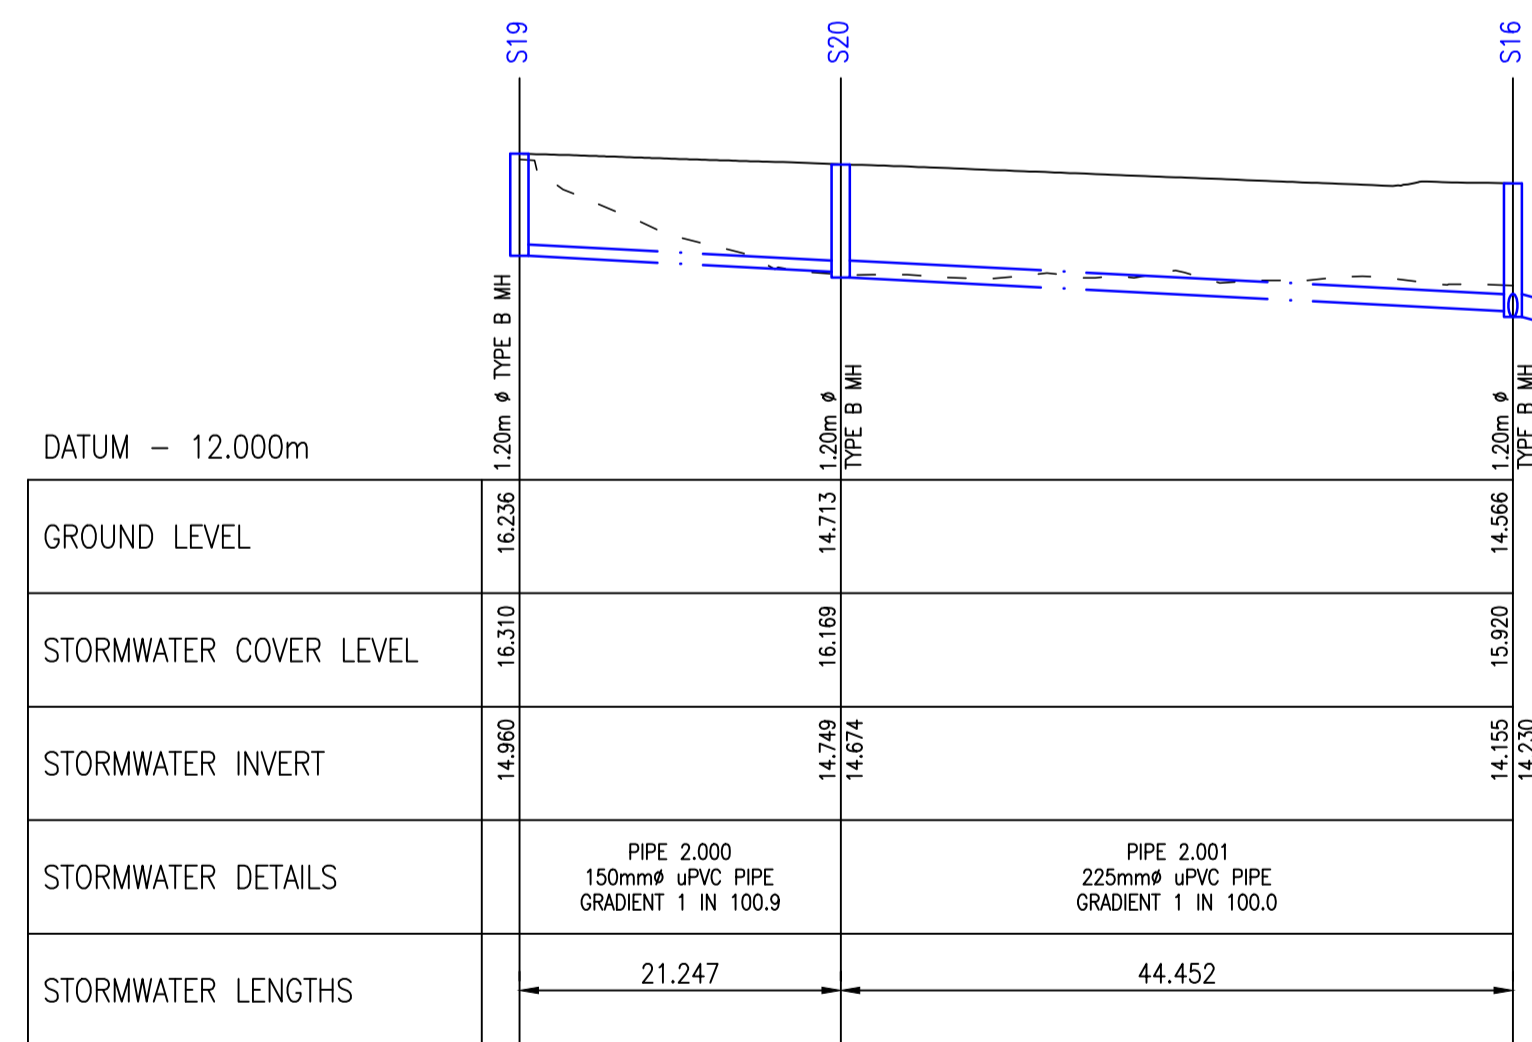

SURFACE WATER SEWER LONG SECTIONS PIPE RUN 2.000 (WEST INLET)
 (SCALE: Horizontal 1:500, Vertical 1:100)

Do not scale from this drawing.

SAFETY HEALTH AND ENVIRONMENTAL INFORMATION

IN ADDITION TO THE HAZARD/RISKS NORMALLY ASSOCIATED WITH THE TYPES OF WORK DETAILED ON THIS DRAWING, NOTE THE FOLLOWING RISKS AND INFORMATION.

RISKS LISTED HERE ARE NOT EXHAUSTIVE. REFER TO DESIGN ASSESSMENT FORM NO.

CONSTRUCTION
 250mm \varnothing SCOTTISH WATER ASBESTOS CEMENT WATER MAIN ADJACENT TO NORTH EAST SITE BOUNDARY. INUNDATION OF CANAL WATER TO CONSTRUCTION SITE DUE TO CANAL LOCK FAILURE.

DEMOLITION
 NONE THAT COULD NOT BE FORESEEN BY A COMPETENT CONTRACTOR.

FOR INFORMATION RELATING TO USE, CLEANING AND MAINTENANCE SEE THE HEALTH AND SAFETY FILE

IT IS ASSUMED THAT ALL WORKS WILL BE CARRIED OUT BY A COMPETENT CONTRACTOR WORKING, WHERE APPROPRIATE, TO AN APPROVED METHOD STATEMENT.

- Notes:
- DO NOT SCALE FROM THIS DRAWING
 - ALL DIMENSIONS ARE IN METRES UNLESS SPECIFIED OTHERWISE
 - REFER TO FAIRHURST DRAWING 149592/2200 & 2201 FOR DRAINAGE LAYOUT PLAN SHEETS 1 & 2.
 - REFER TO FAIRHURST DRAWING 149592/2202 FOR SURFACE WATER LONGITUDINAL SECTIONS SHEET 1.
 - REFER TO FAIRHURST DRAWINGS 149592/2203 & 2204 FOR FOUL WATER LONGITUDINAL SECTIONS SHEETS 1 & 2.

- LEGEND:
- PROPOSED ROAD LEVEL
 - - - EXISTING GROUND LEVEL
 - PROPOSED CONCRETE PROTECTION

Rev.	Date	Description	Drawn	Chkd.	Appd.

FAIRHURST
 Elm House
 Beechwood Business Park
 INVERNESS
 KZ 3BW
 Tel: 01463 724 544
 Fax: 0844 381 4412

The Highland Council
 Comhairle na Gàidhealtachd

Project Title:
NEW HOUSING TORVEAN NORTH

Drawing Title:
SURFACE WATER LONGITUDINAL SECTIONS (WEST INLET) SHEET 2 OF 2 PHASE 1

Scale of A1:	Status:
AS SHOWN	For Approval
Drawn: SWM	Checked: RMS
Date: 11/03/24	Date: 13/03/24
Approved: JP	Date: 15/03/24

Drawing No.: 149592/2212 Revision: -