


© Copyright of this document is reserved by
Dougall Baillie Associates Ltd.
DO NOT scale from this drawing

- Notes:
1. ALL CONSTRUCTION DETAILS TO COMPLY WITH SOUTH LANARKSHIRE COUNCIL DESIGN GUIDE FOR NEW RESIDENTIAL AREAS THE DESIGN MANUAL FOR ROADS AND BRIDGES.
 2. THE SPECIFICATION FOR THIS PROJECT IS THE SPECIFICATION FOR HIGHWAY WORKS.
 3. ALL DRAINAGE TO COMPLY WITH "SEWERS FOR SCOTLAND 4".

LEGEND

	EXISTING ADOPTED COUNCIL ROADS DRAIN
	PROPOSED ADOPTABLE ROADS DRAIN

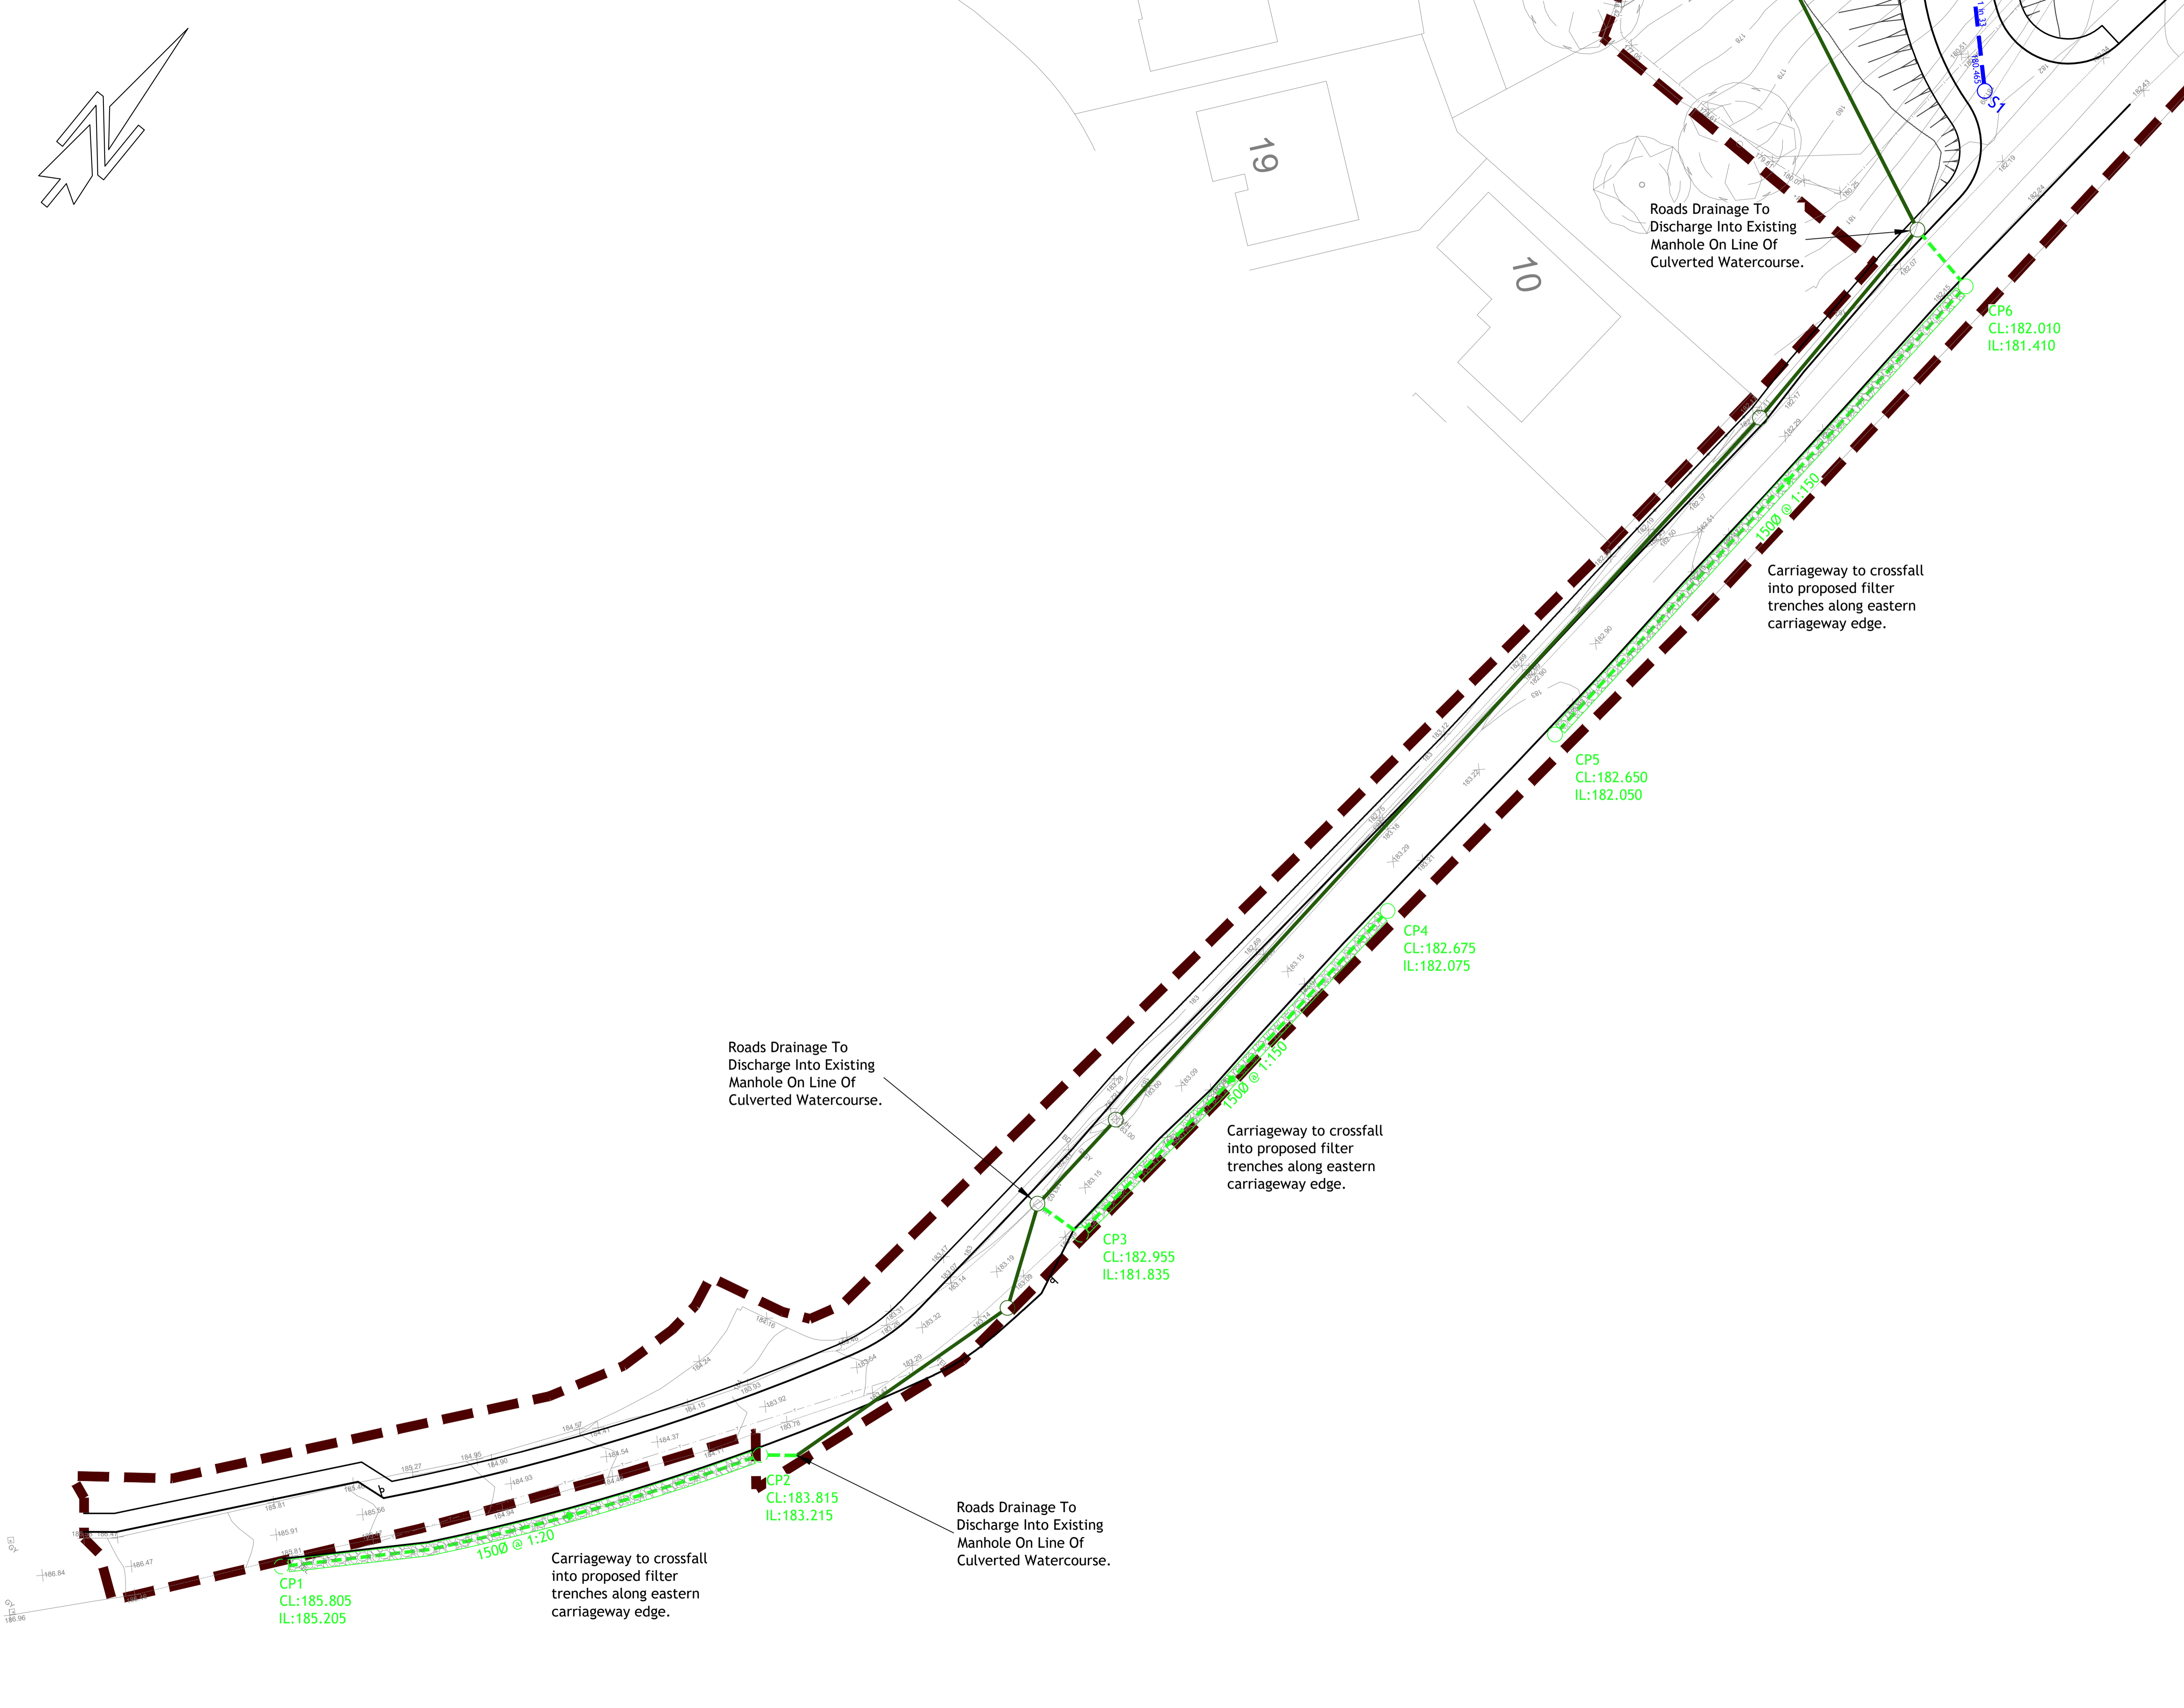

Rev	Revision details	By	Checked
		Date	Date

Client:
LGRP DESIGN & BUILD LTD

Project:
BELLEFIELD, LANARK

Drawing Title:
BELLEFIELD ROAD
DRAINAGE LAYOUT

Drawn: S.McD.	Checked: I.R.
Date: 06.12.22	Date: 06.12.22
Scale: 1:250	Dwg No: 18243-500-101
Dwg Status: APPROVAL	Print: COLOUR

Dougall Baillie Associates
3 Glenfield Road, Kelvin
East Kilbride G75 0RA
t: 01355 266480
f: 01355 221991
e: enquiries@dougallbaillie.com
w: www.dougallbaillie.com

Civil, structural, transportation, water management.