

 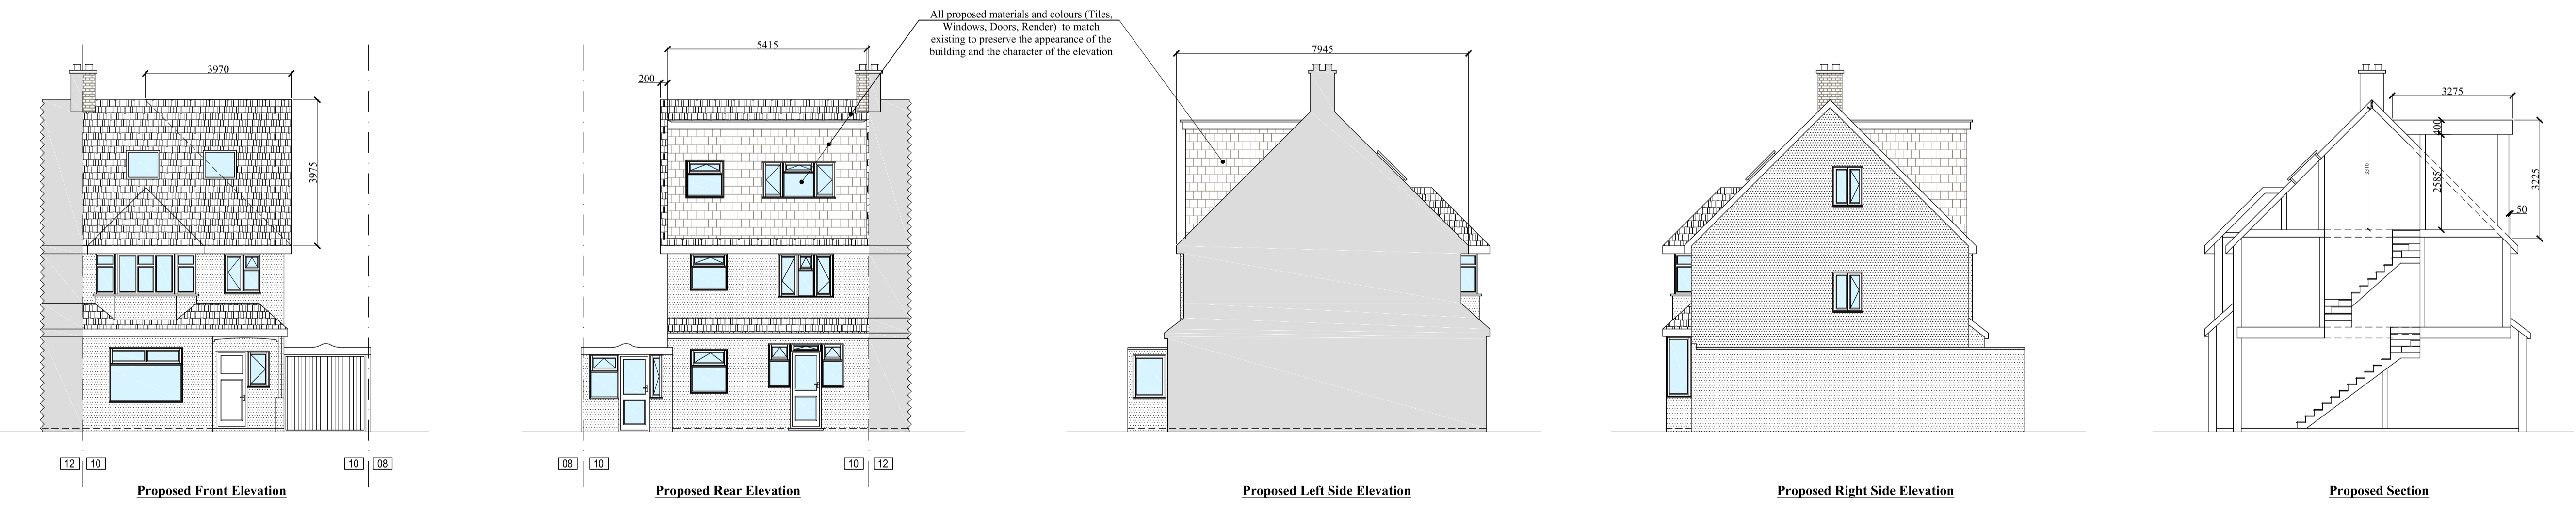


LEGEND
 SD Smoke Detector, alarm fitting
 HD Heat Detector / alarm fitting
 CD Carbon Detector, alarm fitting
 All alarms to be wired and interconnected

28.4m² - Total additional area. No CIL liable

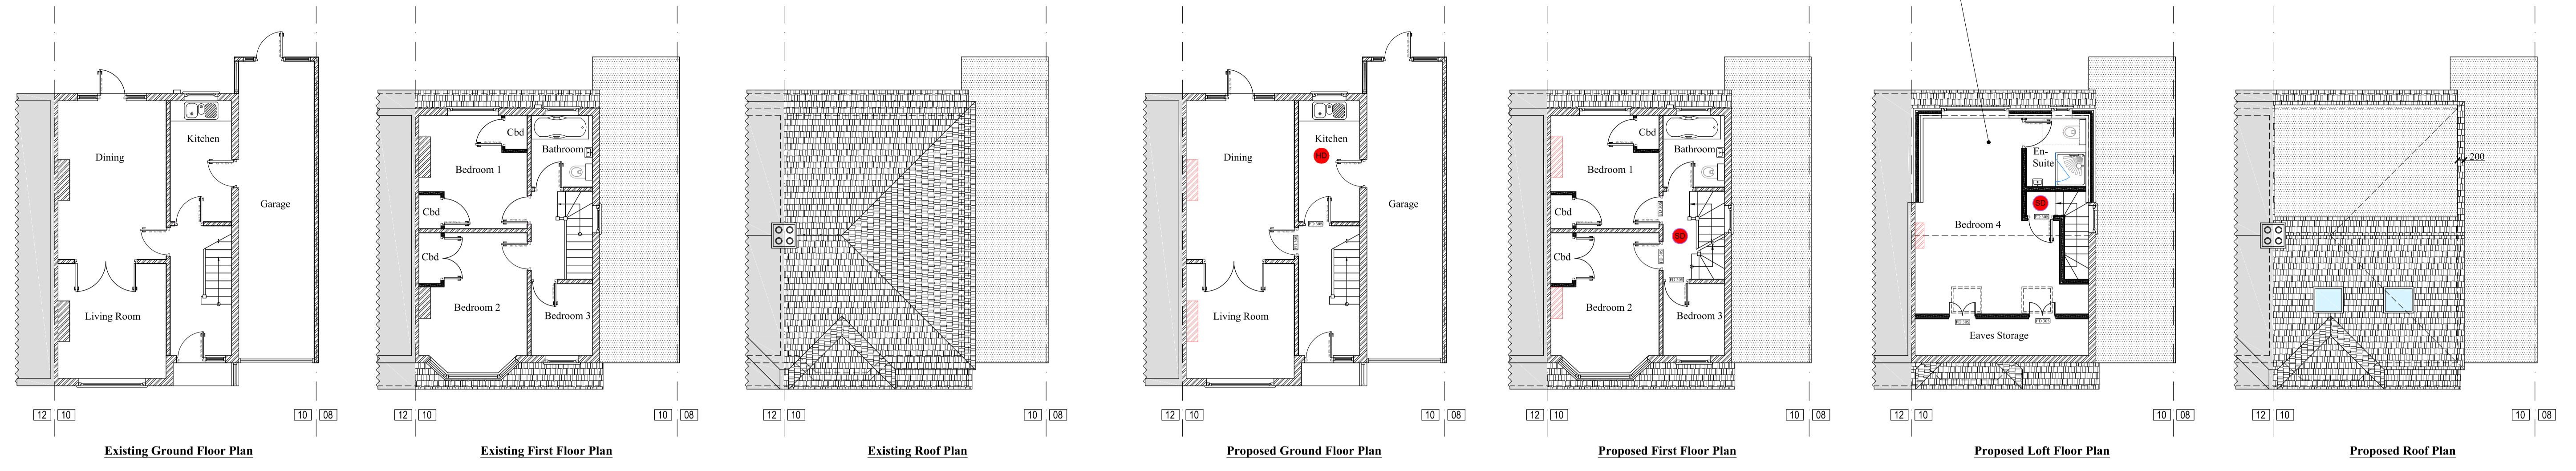

Volume(Vd) = $\frac{1}{2} \times 3.225 \times 3.275 \times 5.415$
 = 28.60 Cu.m
 Volume(Vg) = $\frac{1}{2} \times 3 \times 3.973 \times 7.945$
 = 20.90 Cu.m
 Volume(Vd+Vg) = 28.60 + 20.90
 = 48.50 Cu.m



| Rev | Date | Description |
|-----|------|-------------|
| - | - | - |
| - | - | - |
| - | - | - |
| - | - | - |

Client **Dimitar P.**
 Project **Loft conversion, Hip to gable, Rear dormer, Two roof lights**
 Address **10 Fieldsend Road, Cheam, Sutton, SM3 8NR**
 Drwg. title **Existing / Proposed floor plans and Elevations**

Scale @ A1 1:100
 Drawn by **IS**
 Checked by **AS**
 Date **15/04/24**

Job No. **D000460** Drawing No. **A-8** Rev **00**
 Status of drawing **Planning** Design Stage **3**
 Application