


This drawing is the property of Simon Middlecote Architecture Ltd. Copyright is reserved by them and the drawing is issued on the condition that it is not copied, reproduced, retained or disclosed to any unauthorised person, wholly or in part without the written consent of Simon Middlecote Architecture Ltd. All dimensions to be verified on site, do not scale drawing.


Key to abbreviations

- IC Inspection chamber
- SP/AAV Soil and vent pipe with air admittance valve
- SVP Soil and vent pipe
- WP Waste pipe
- RWP Rainwater pipe
- Gu Gully
- GM Gas Meter
- EM Electric Meter
- Dis. Board Distribution board
- AP Alarm Panel


- Below ground drainage**
- - - Private combined
 - - - Shared combined
 - (Assumed. TBC by survey by others)

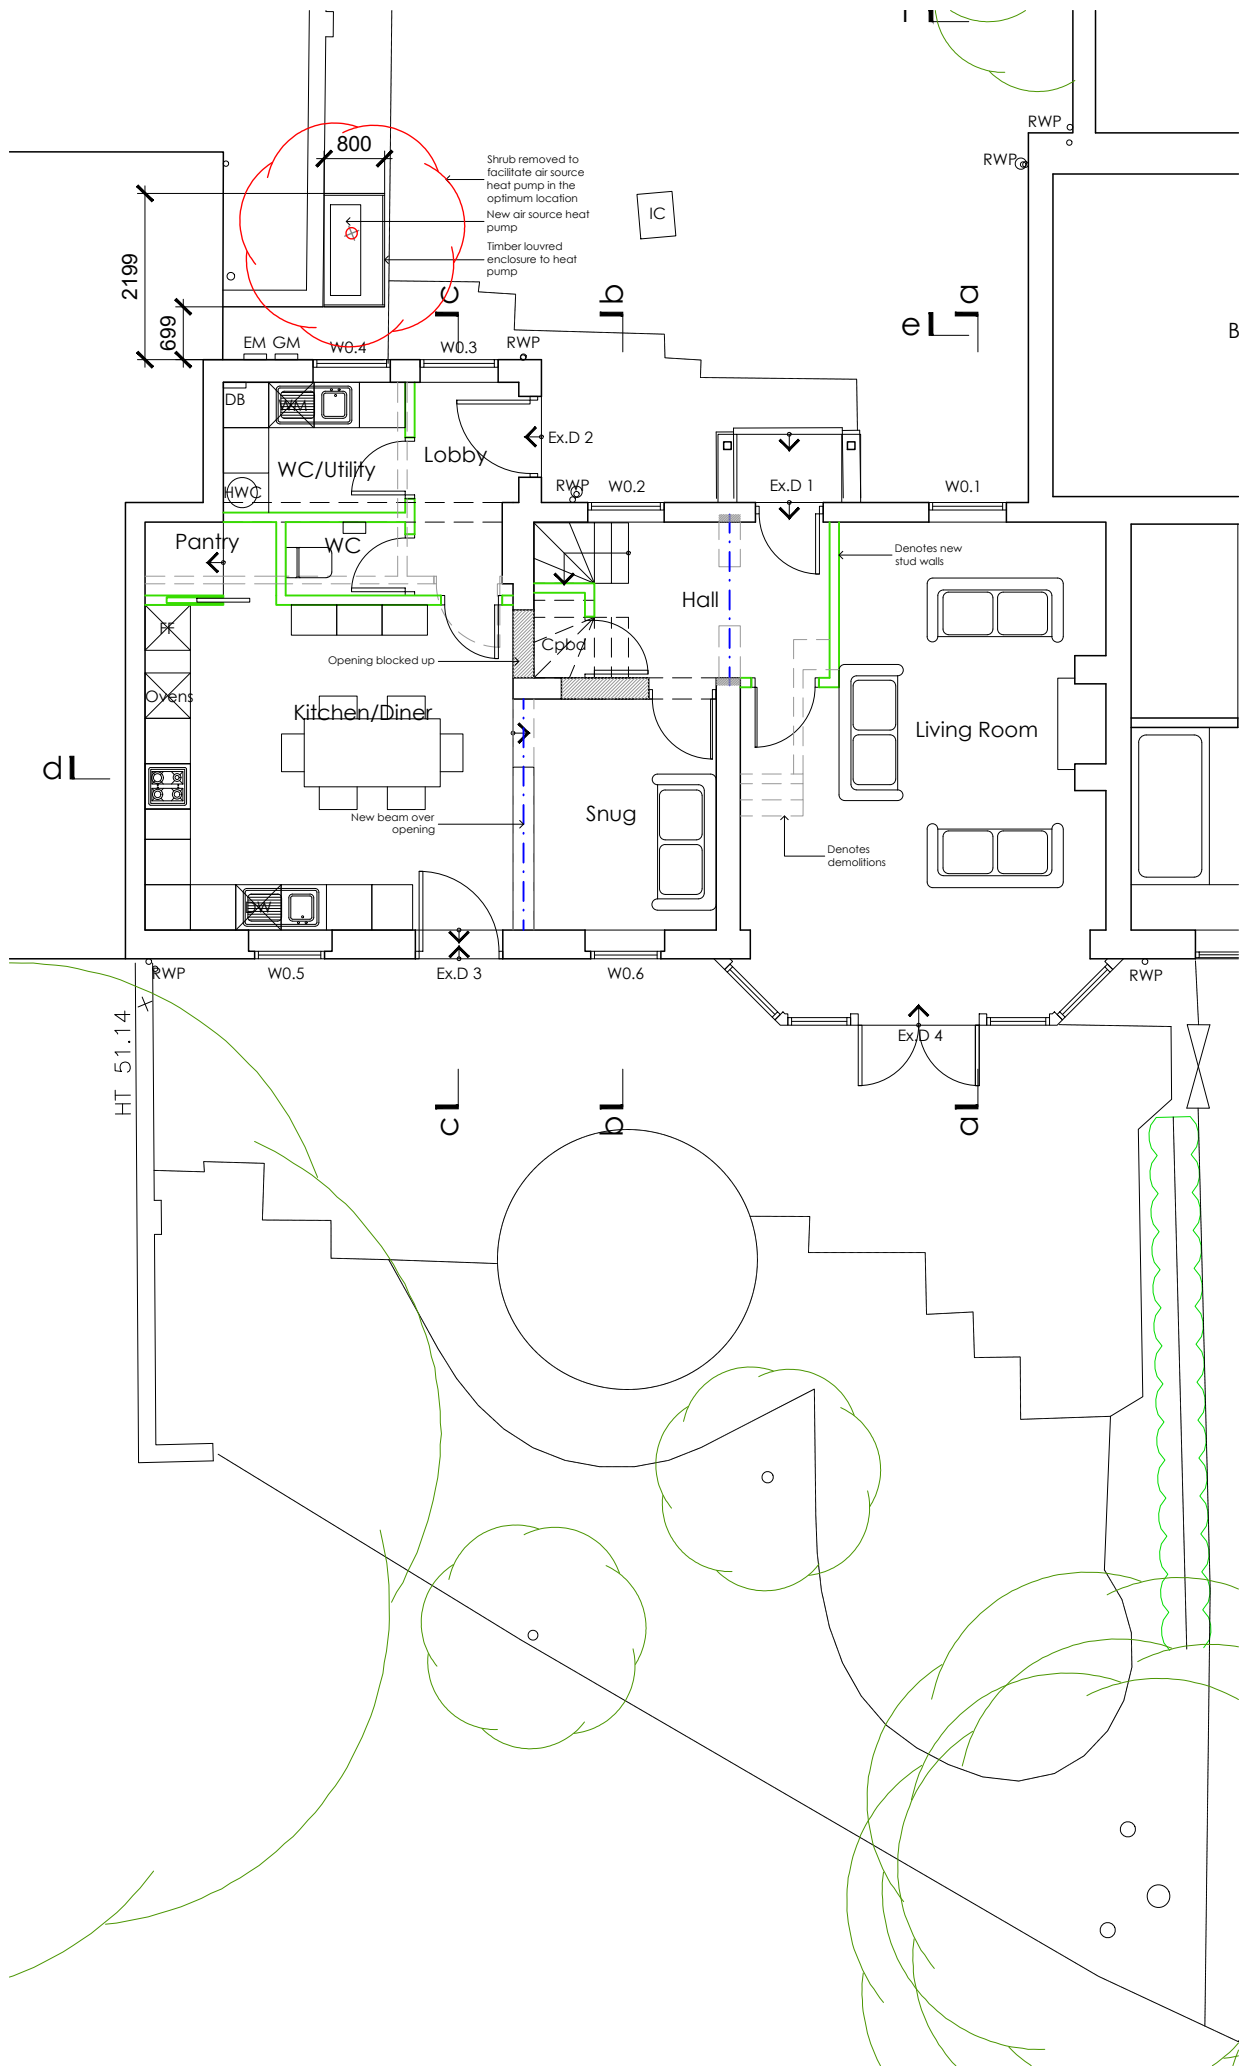

Ground Floor Plan

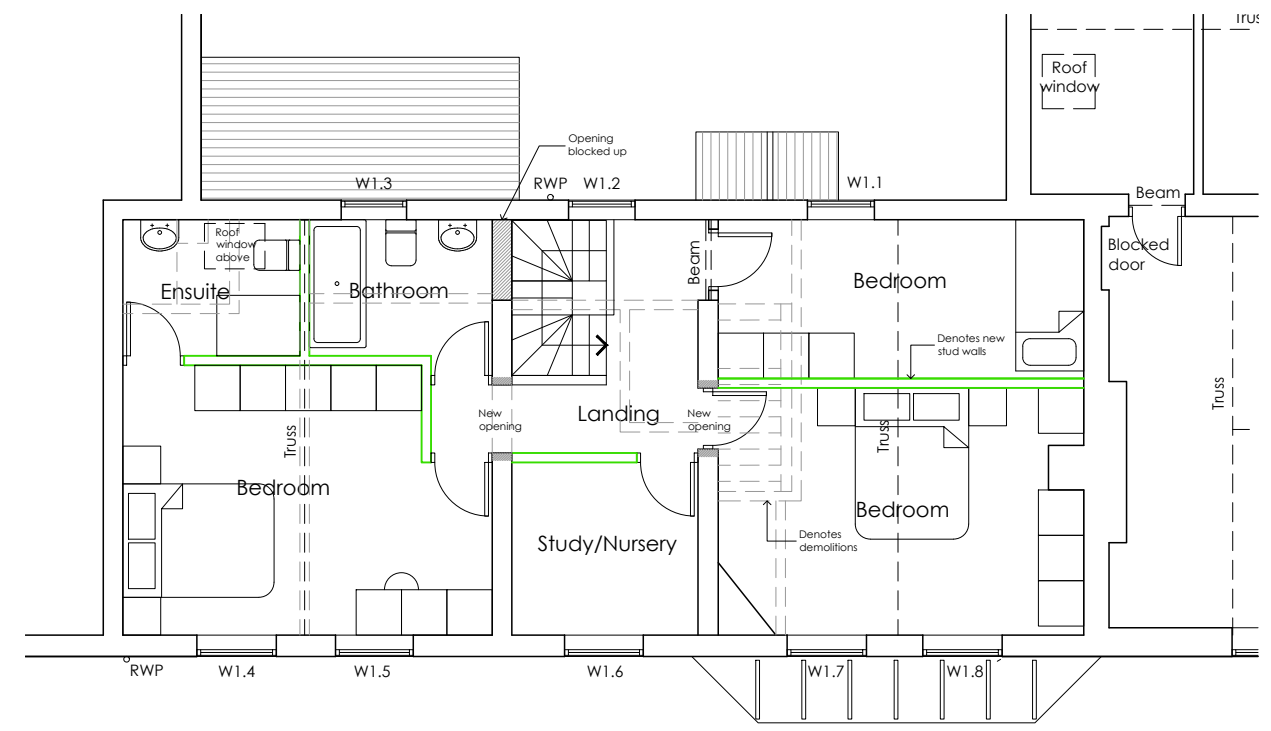

First Floor Plan

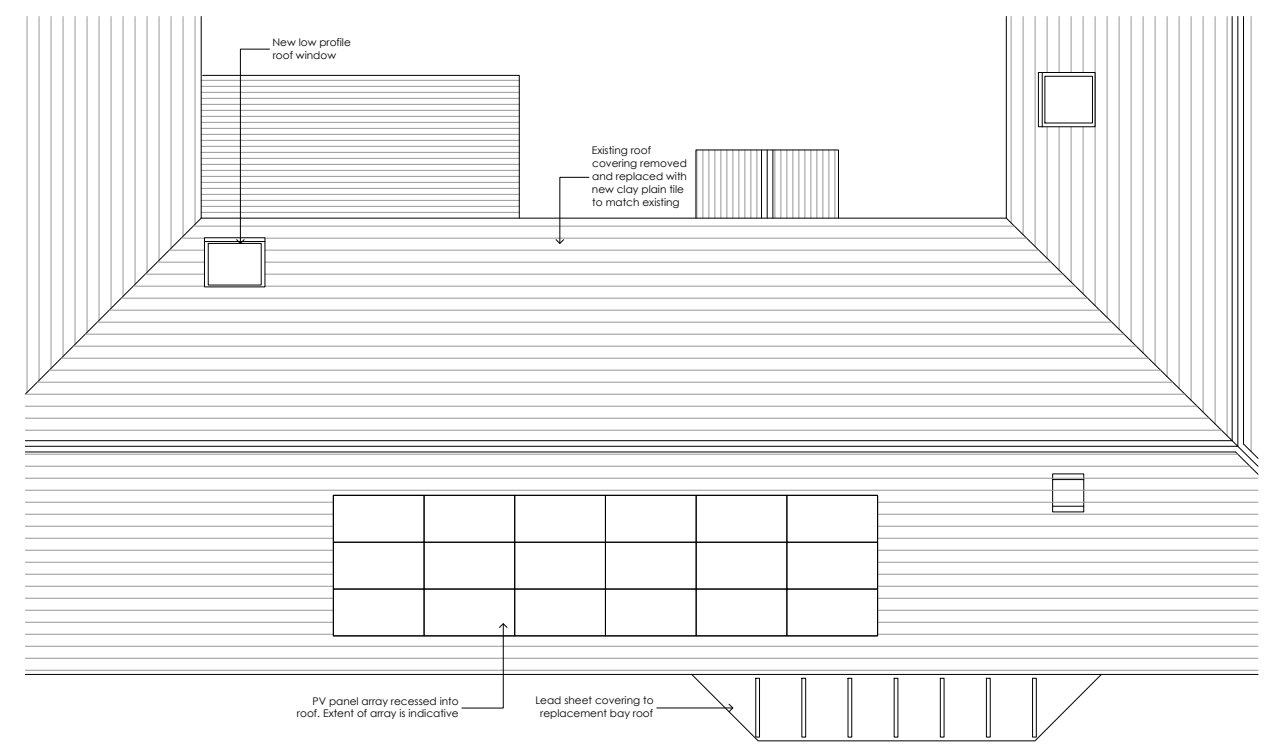

Roof Plan

Rev	Date	Description	By
B	15.04.2024	Information added as requested by planners	SM
A	14.03.2024	Updated following client comment	SM

Simon Middlecote Architecture Ltd
 7 Mountsorrel Drive
 West Bridgford
 Nottingham
 NG2 6LJ
 T - 07742 301320
 E - info@simonmiddlecote.co.uk

Client:			
Project Title: 10B Kneeton Road East Bridgford			
Drawing Title: Plans as proposed			
Project No: 23017	Dwg No: (08)02	Revision: B	Scale: 1:100
Drawn: SM	Date: 29.01.2024	Status: SCHEME DESIGN	