

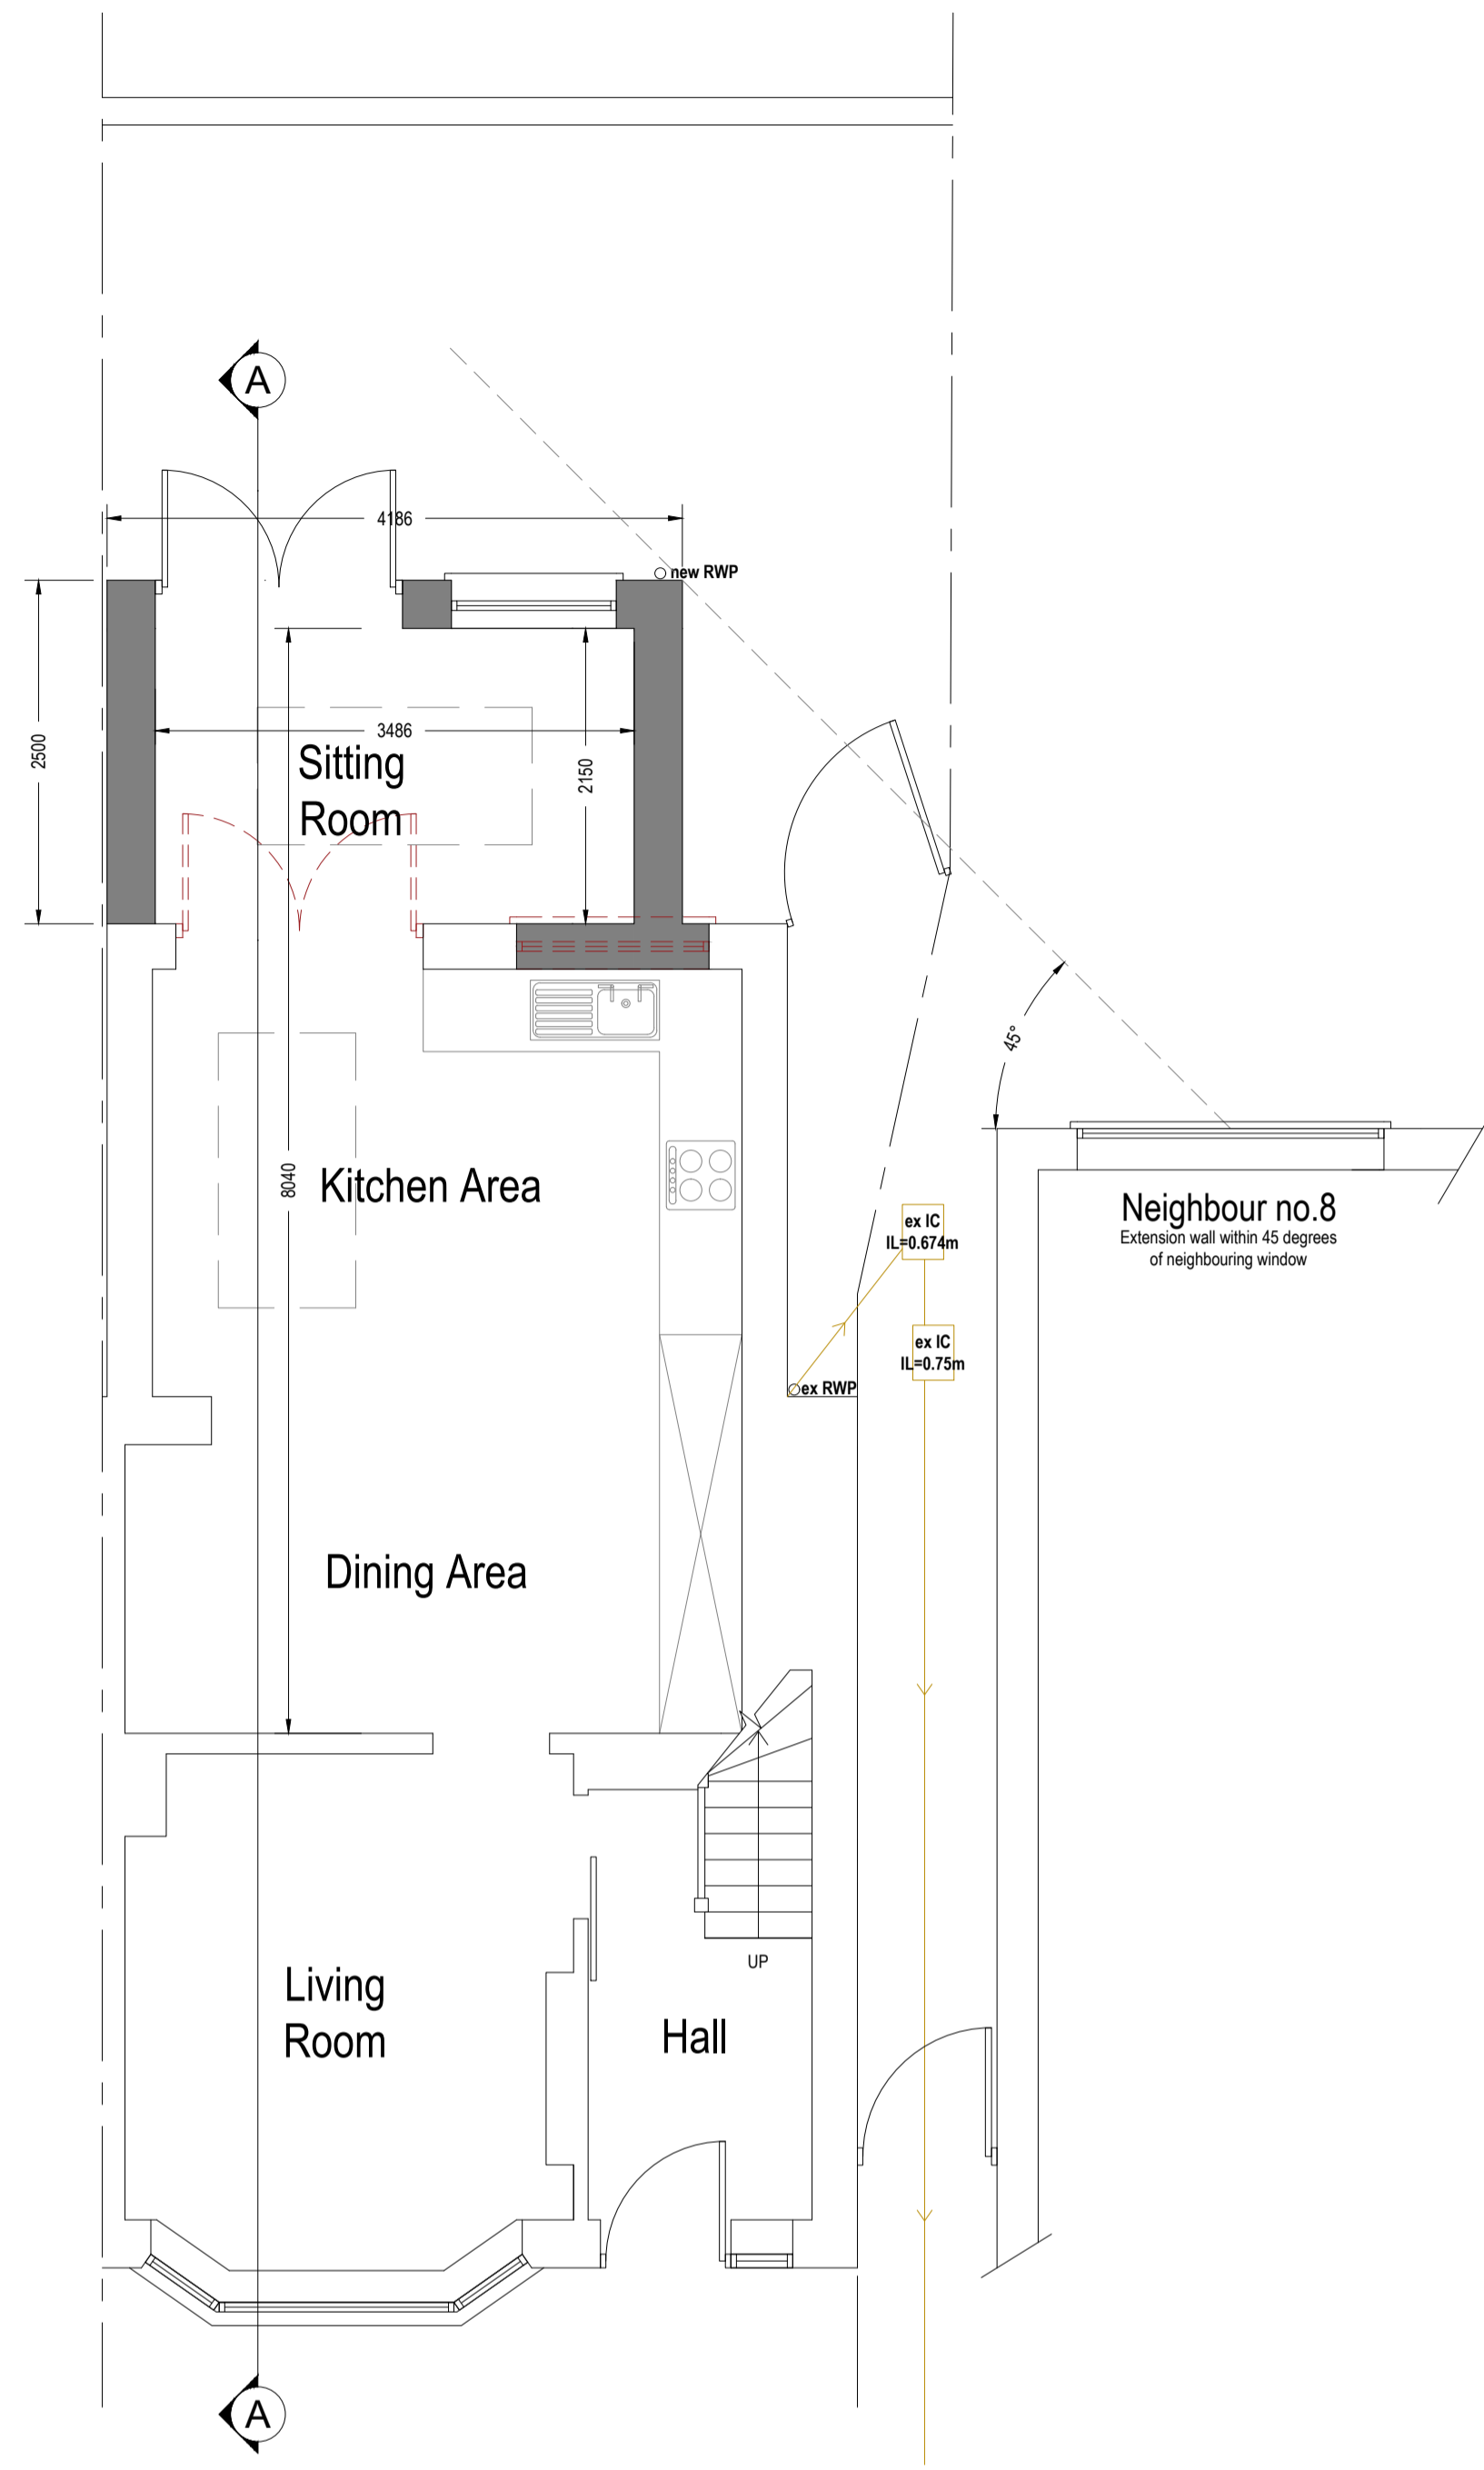



PROPOSED

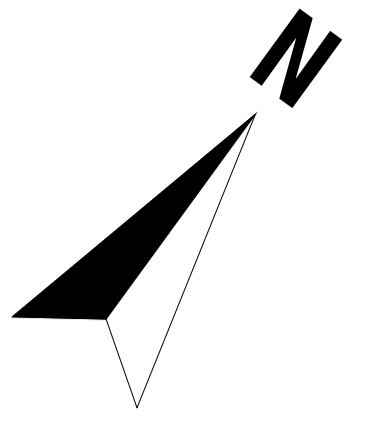

Ground Floor Plan
 Area ca. 51.39 m²
 Additional Area: 8.64 m²

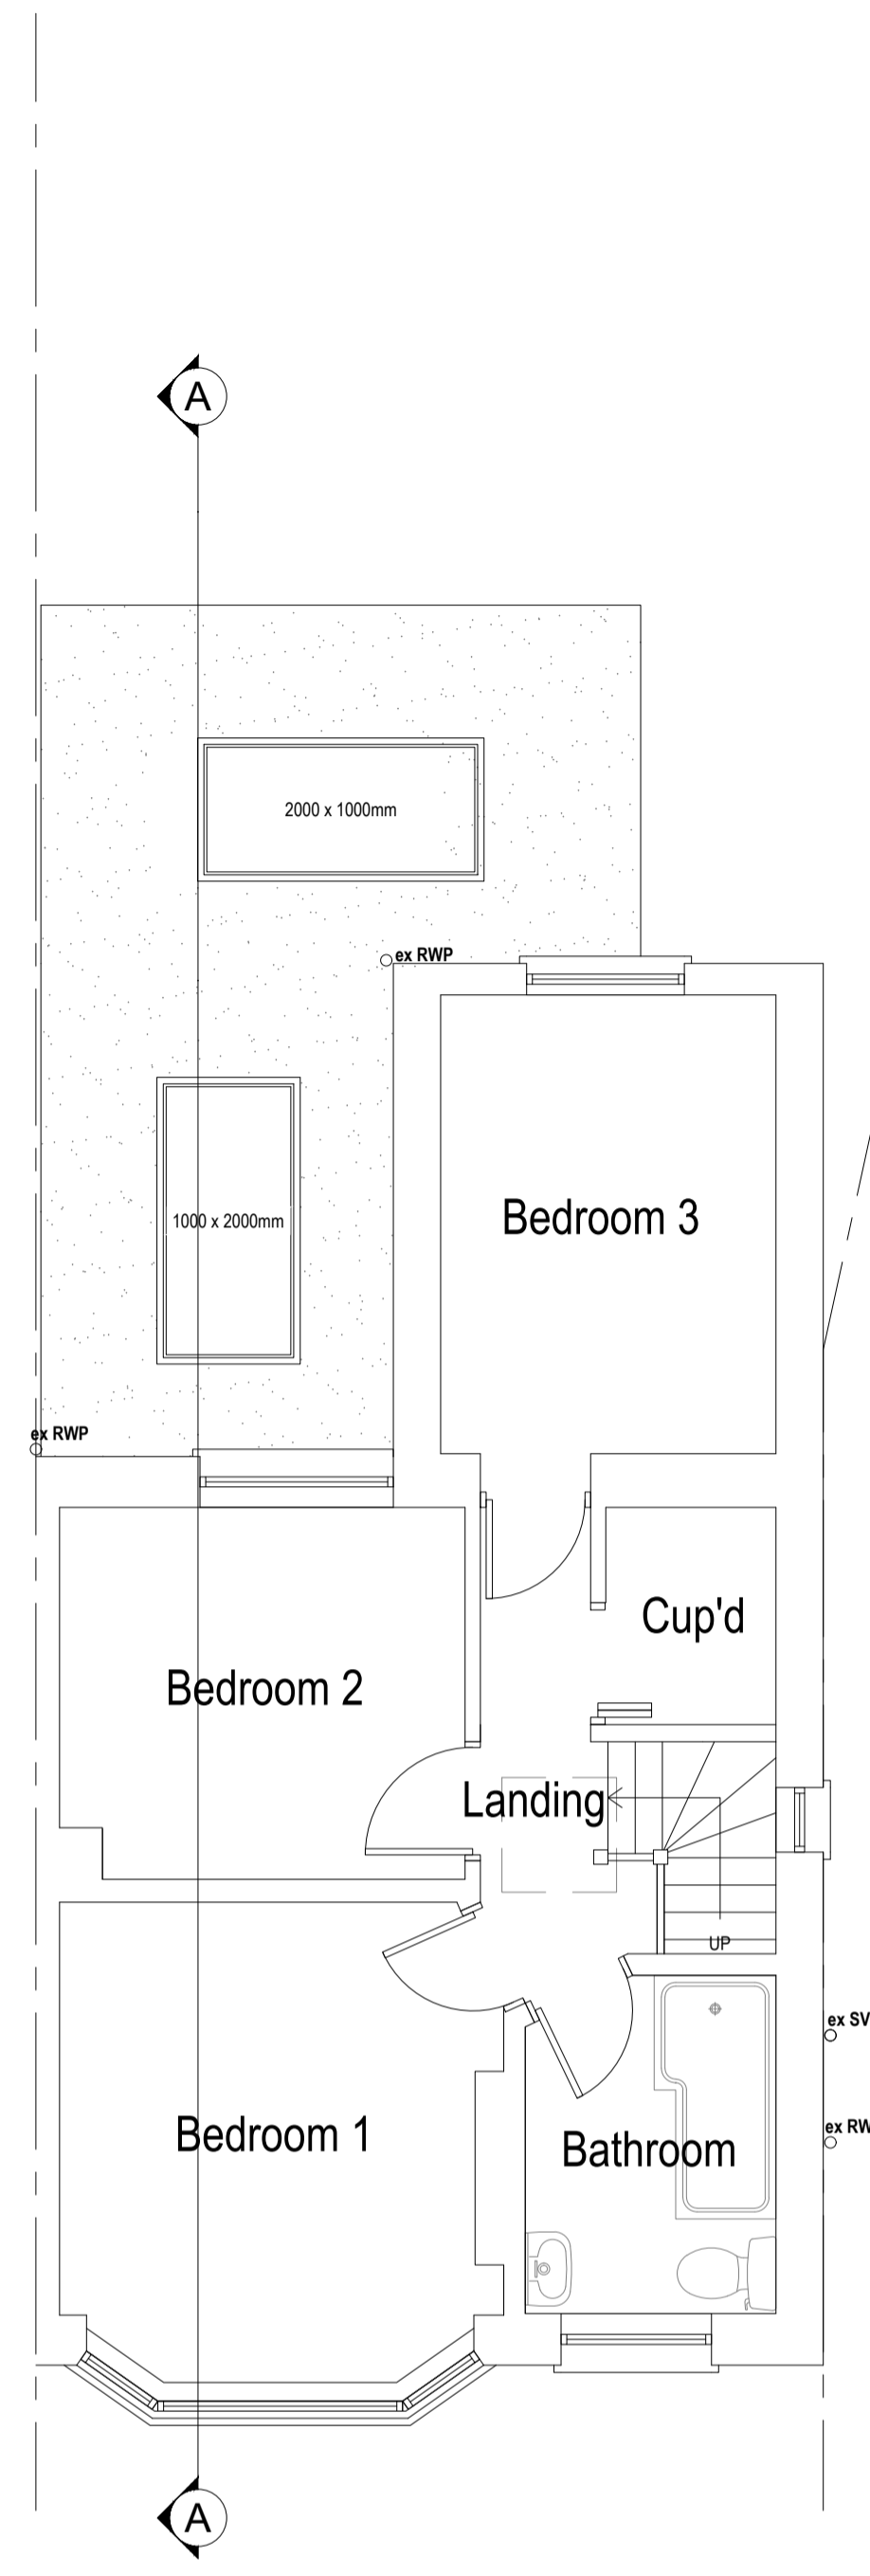

First Floor Plan
 Area ca. 37.59 m²

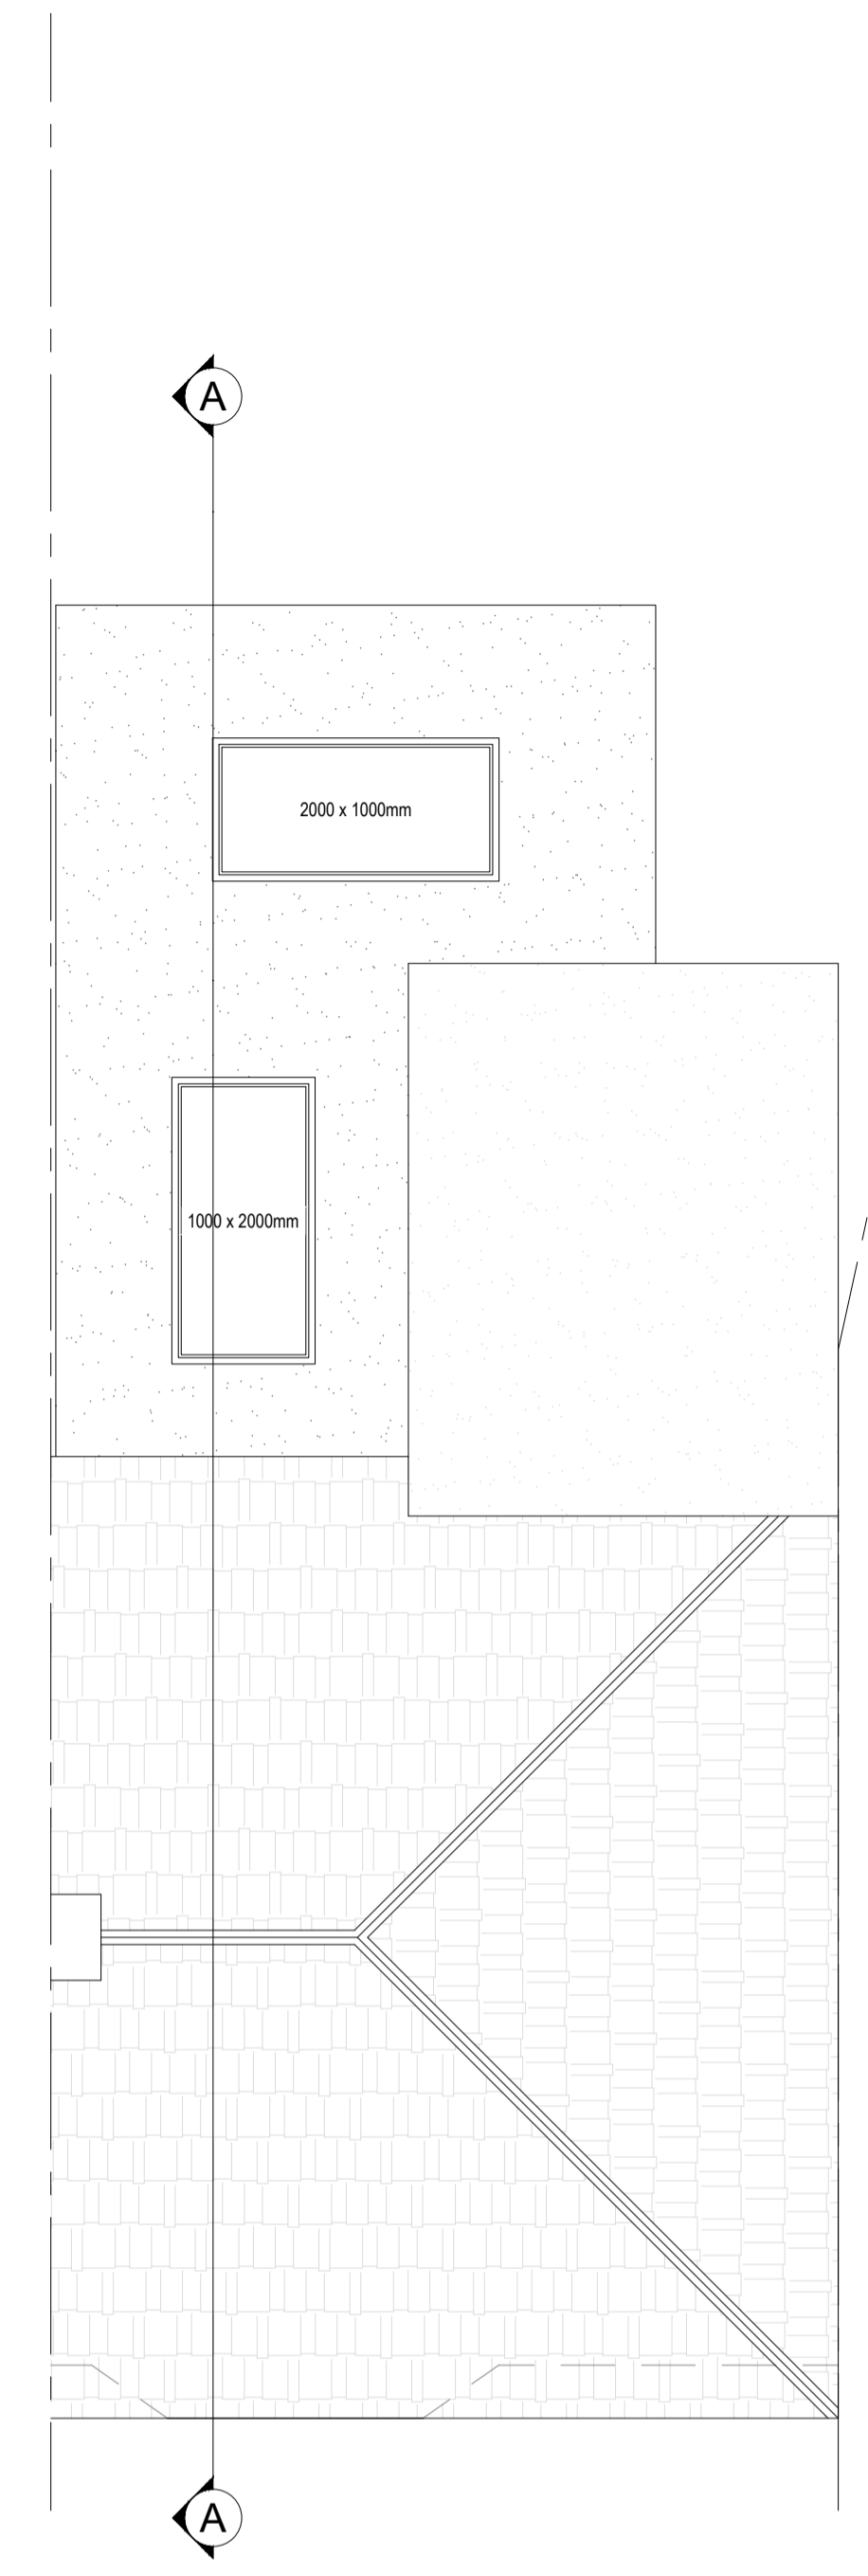

Roof Plan

Symbol Key:

- Proposed wall
- Boundary line
- Details above
- Waste drainage layout
- Demolished
- Rainwater layout



Note to Contractor: Contractor is recommended to carry out an intrusive site investigation prior to commencing works on site to ensure all details designed for this project are appropriate. Contractor to cross reference with Structural Calculations package for suitability, to assess site levels and confirm any design assumptions within the calculations package prior to works commencing on site. If the Contractor requires any additional information, please send a Request For Information to hello@planituk.co.uk before ordering materials and starting the works - requests will be acknowledged and responded to as soon as possible. Please ensure that the drawings have been submitted to Building Control for a Full Plans submission and the compliance report has been discharged before starting works on site.

Drawn by:
FD

Title Number
SGL201509

Project:
10 Chester Road, Sidcup, DA15 8SB

Date:
04.04.2024

No.:
24-0324

Client:
D Harris

Drawing Title:
PROPOSED PLANS

Scale @A1:
1:50

Rev:
02

Page:
D03

