


Contractor must verify all dimensions on site before commencing any work or shop drawings. If this drawing exceeds the quantities taken in any way, the building designers are to be informed before the work is initiated. Only figured dimensions to be taken from this drawing. Do not scale off this drawing. Drawing based on Ordnance Survey and/or existing record drawings - design and drawing content subject to Site Survey, Structural Survey, Site Investigations, Planning and Statutory Requirements and Approvals. All drainage layouts are schematic and invert levels must be established prior to construction.

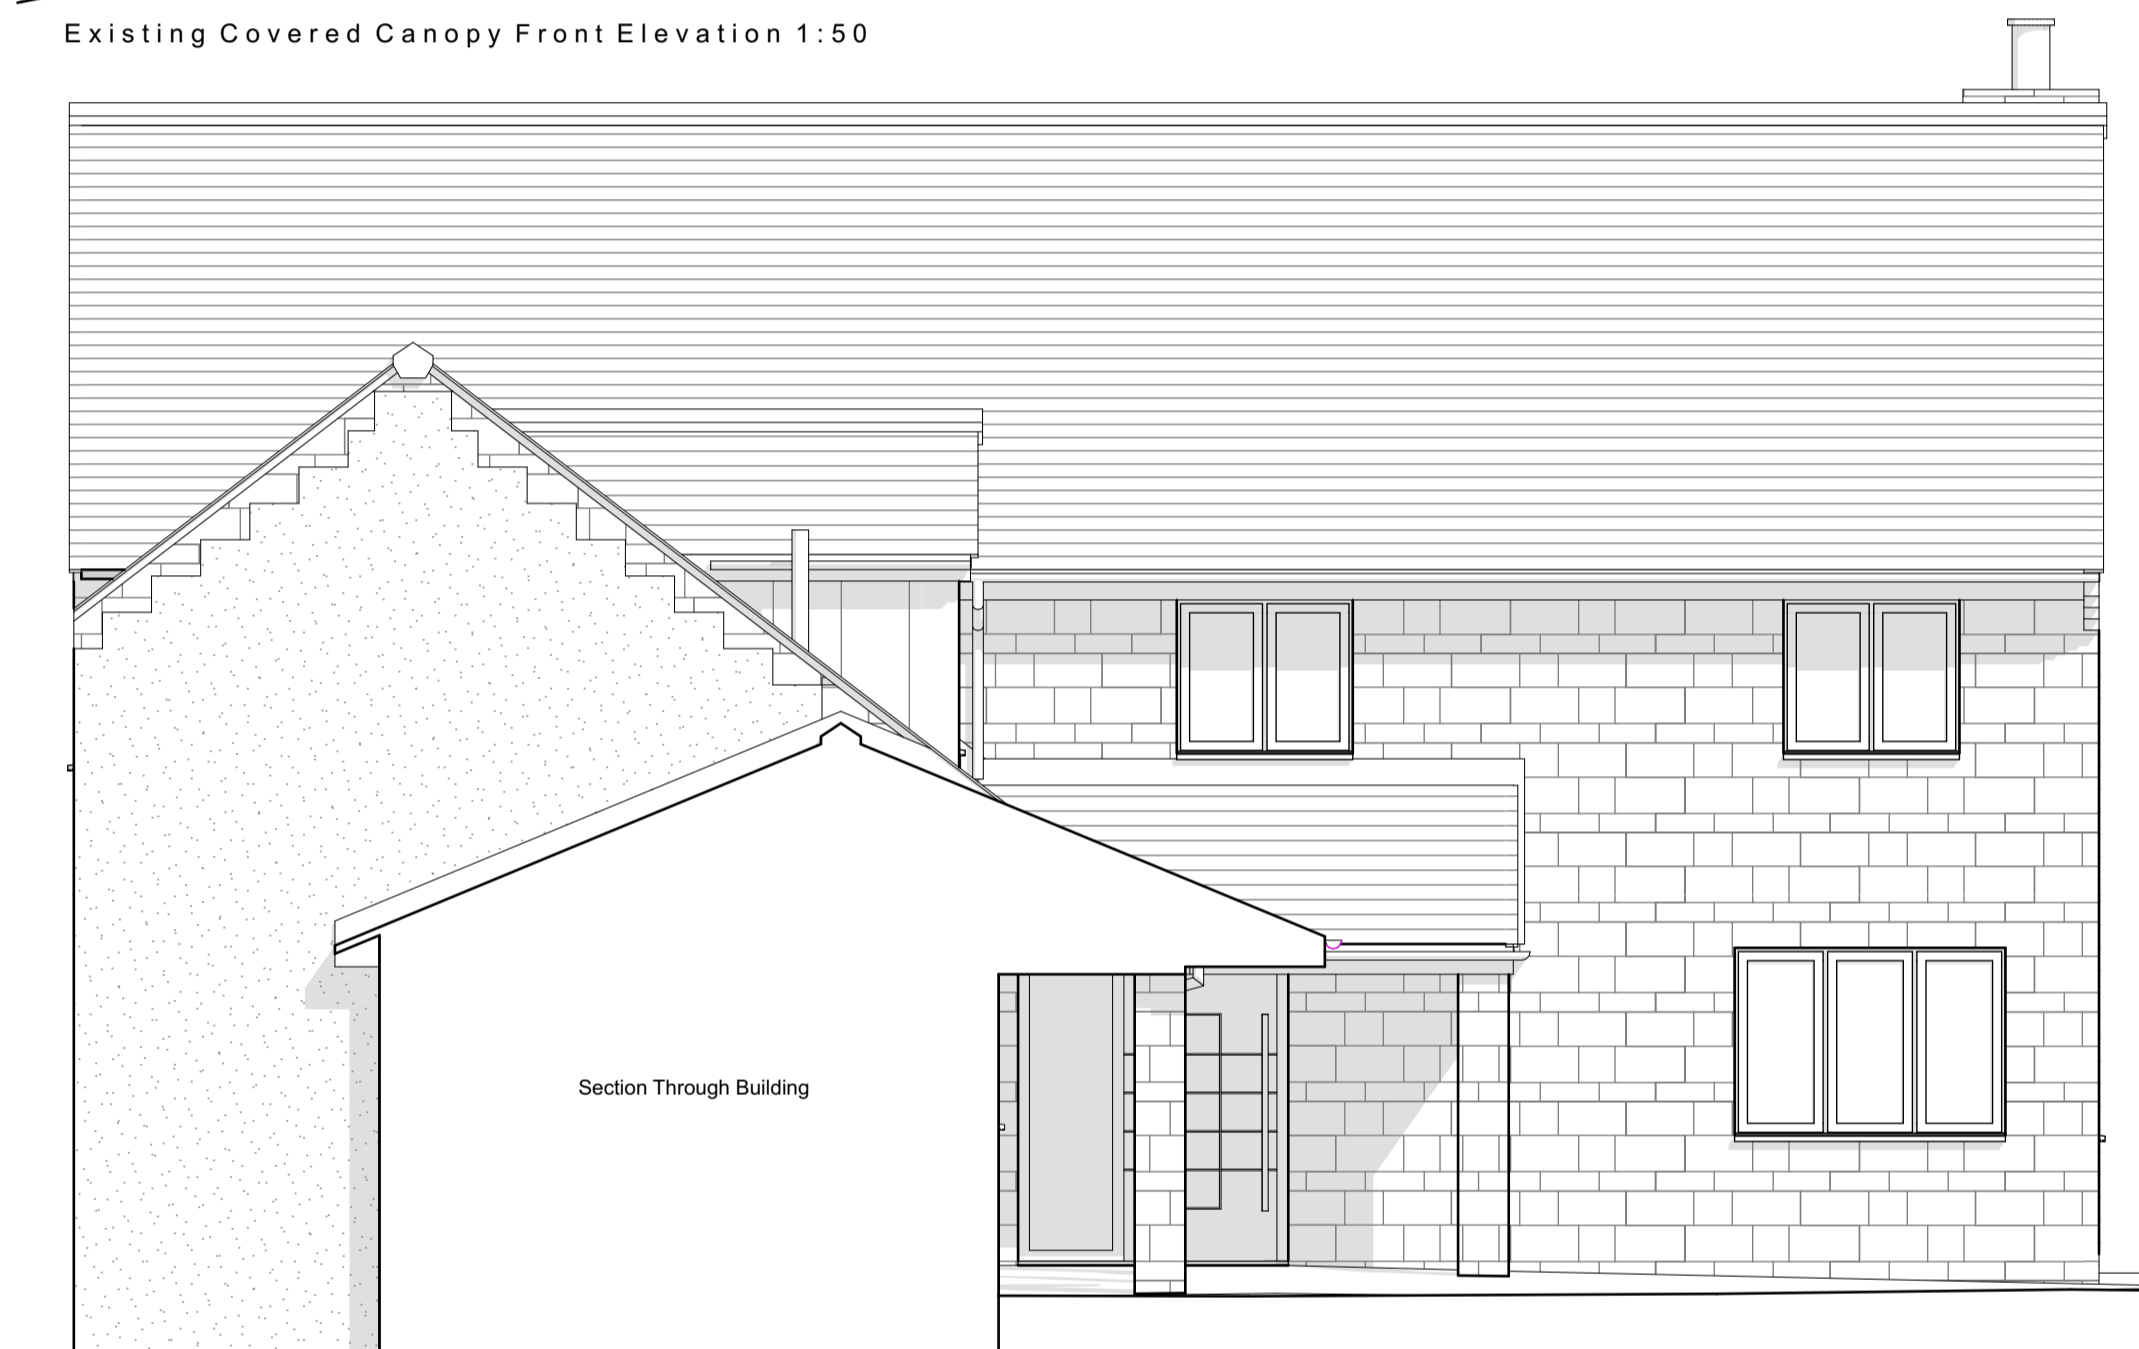


Existing Covered Canopy Front Elevation 1:50



Existing Covered Canopy Side Elevation 1:50

Material Key:	
	Buff stonework
	Grey roof tiles.
	White render.
	Dormer flashing


Note:  
All grey fascias, soffits, gutters & downpipes.  
All grey windows and doors.

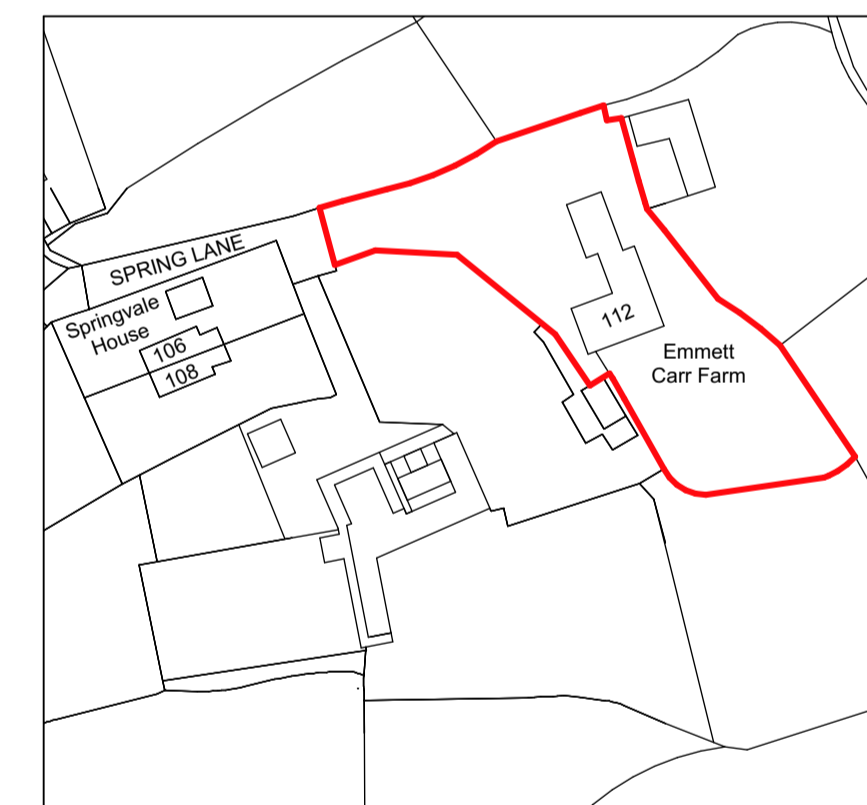

Existing Site Location Plan 1:1250



Existing 3D View (No Scale)

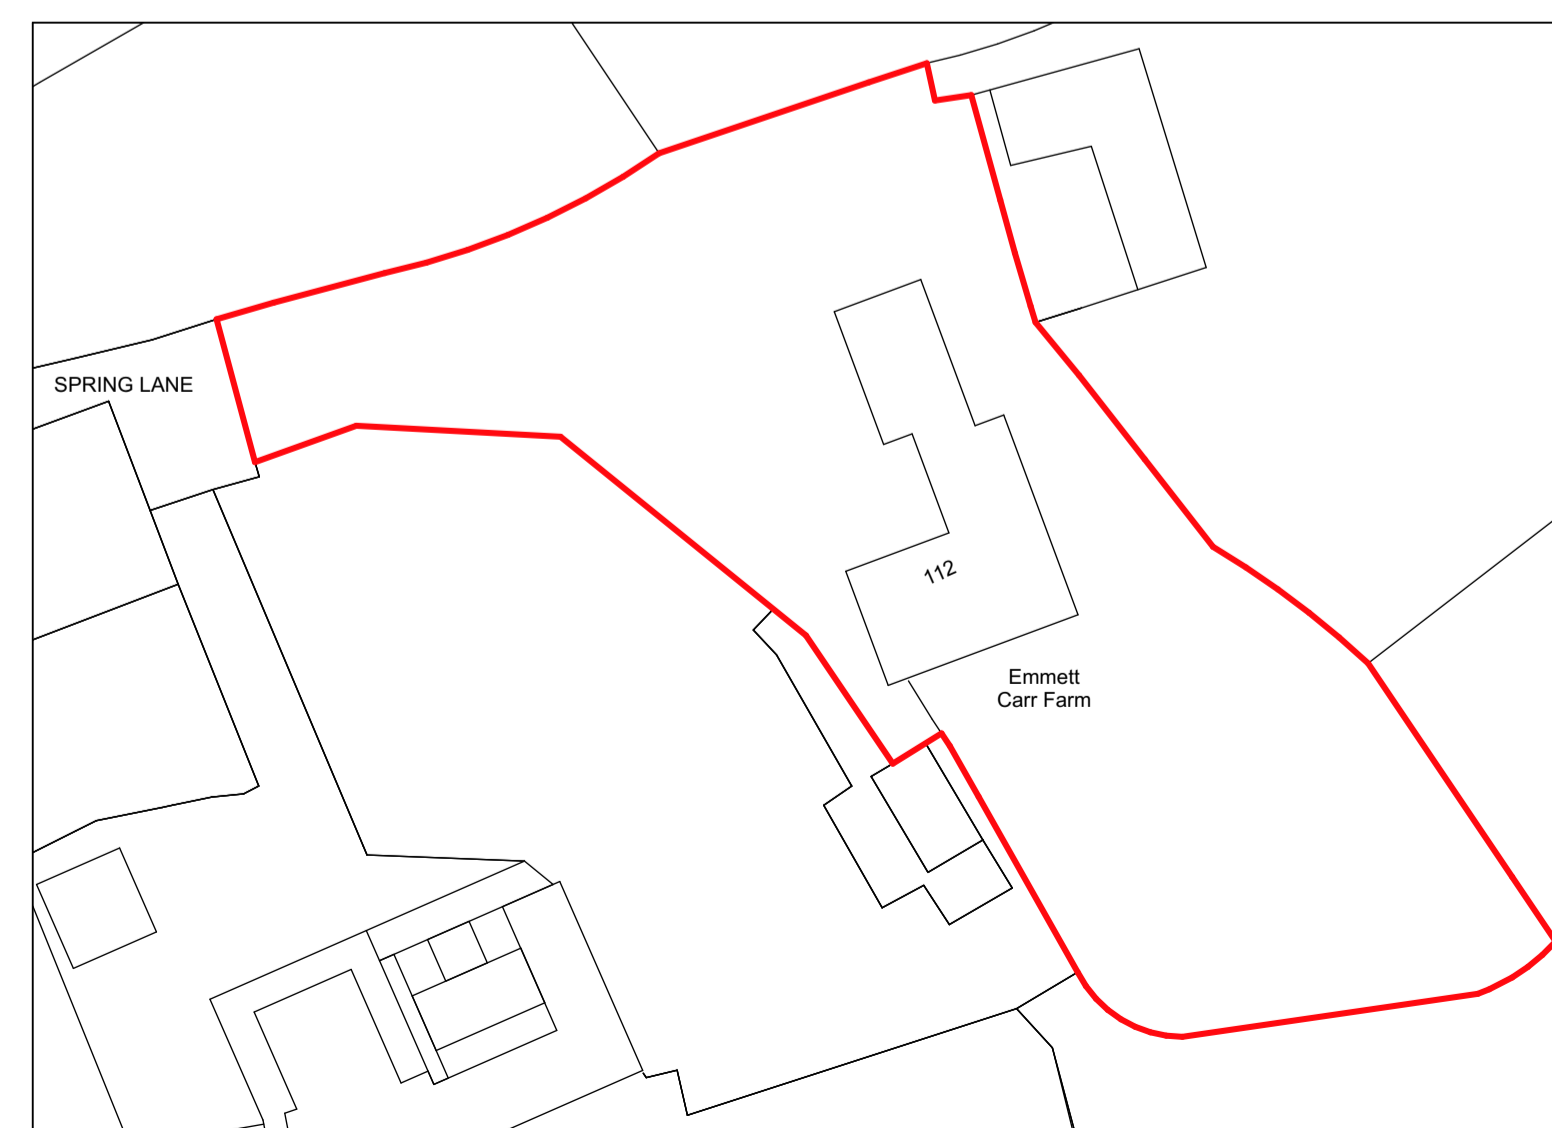

Existing Site Block Plan 1:500

Project Status:	PLANNING ONLY
4 Rushmead Court, Ossett, WF5 0NZ tel: 01924 275 594 web: www.transformarchitects.co.uk email: info@transformarchitects.co.uk	
Project Address:	Emmett Carr Farm Spring Lane Rennishaw Sheffield S21 3WE
Client:	Mr & Mrs Wilkinson
Drawing Title:	Existing Arrangements A1
Scale:	1:50, 1:500, 1:1250
Date:	09.04.2024
Drawn By:	MNB
Drawing Number:	T948 - PL11
Revision:	Nil