


PROPOSED GROUND FLOOR PLAN 1:100


PROPOSED PLANT

REVISION

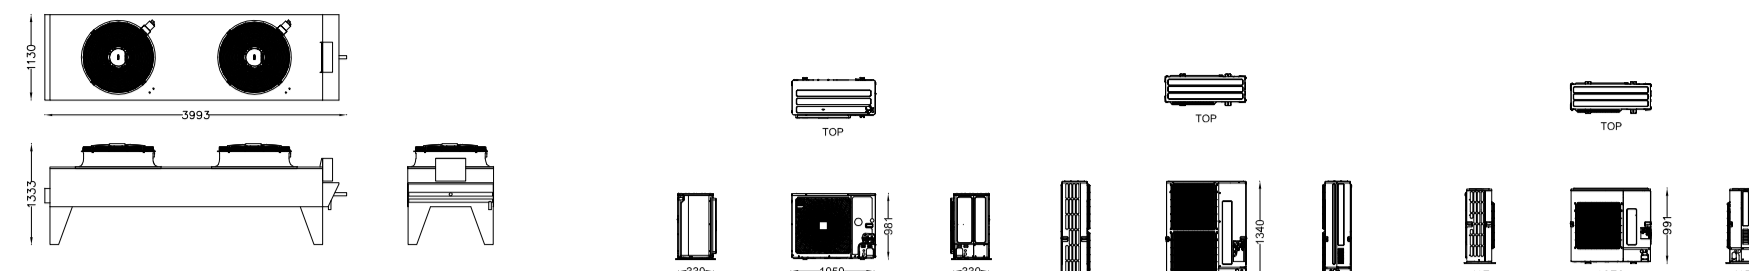


DA GAS COOLER

A/C UNITS

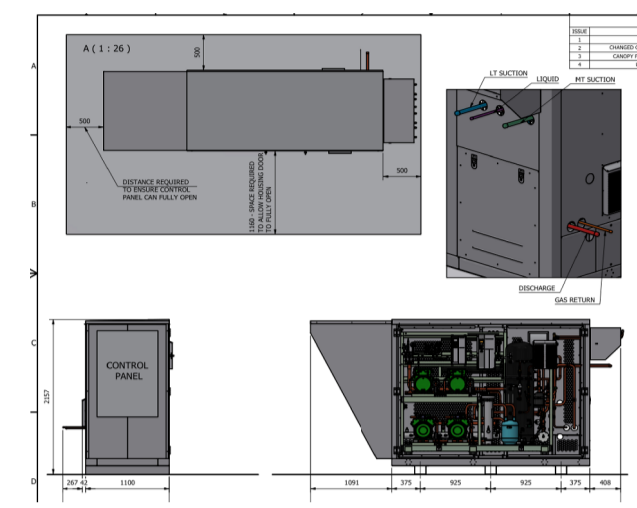


COMPRESSOR PACK

 SCALE 1:50




PROPOSED WORKS INCLUDE;

- \* BLOCK UP ONE OPENING AND RELOCATE ATM IN NEW SHOPFRONT SECTION.
- \* SPRAY SHOPFRONT FRAMES, DOORS, SHUTTER BOXES AND GUIDES TRAFFIC GREY RAL 7043.
- \* NEW EXTERNAL LAUNDRETTE
- \* NEW MECHANICAL PLANT IN EXISTING LOUVERED COMPOUND

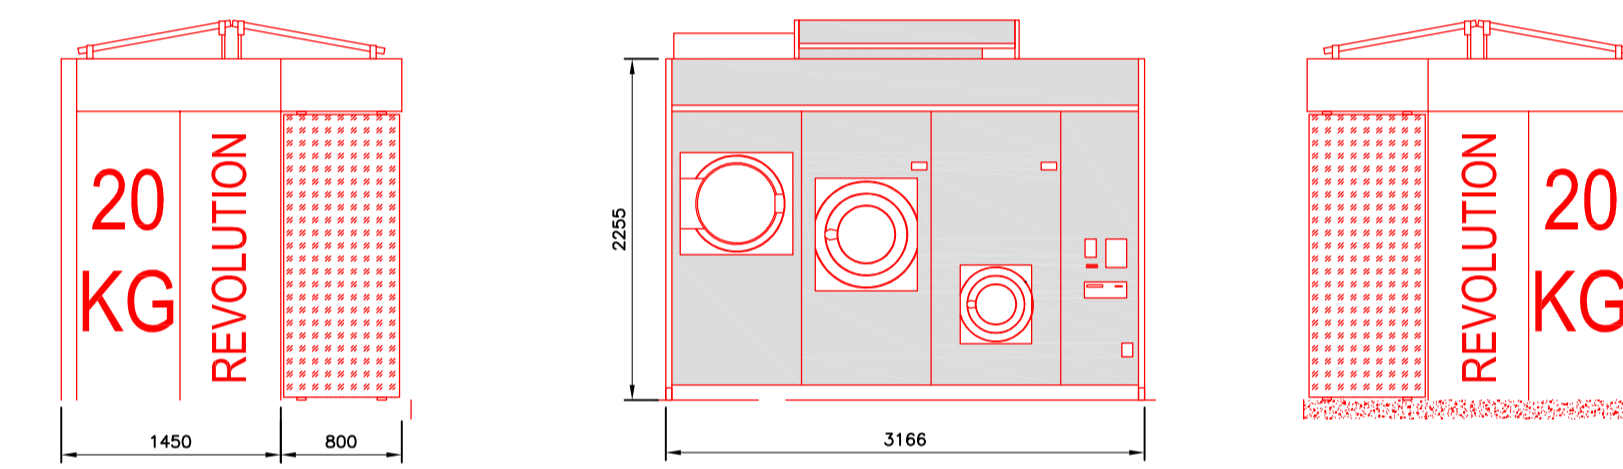

PROPOSED EXTERNAL LAUNDRETTE 1:50


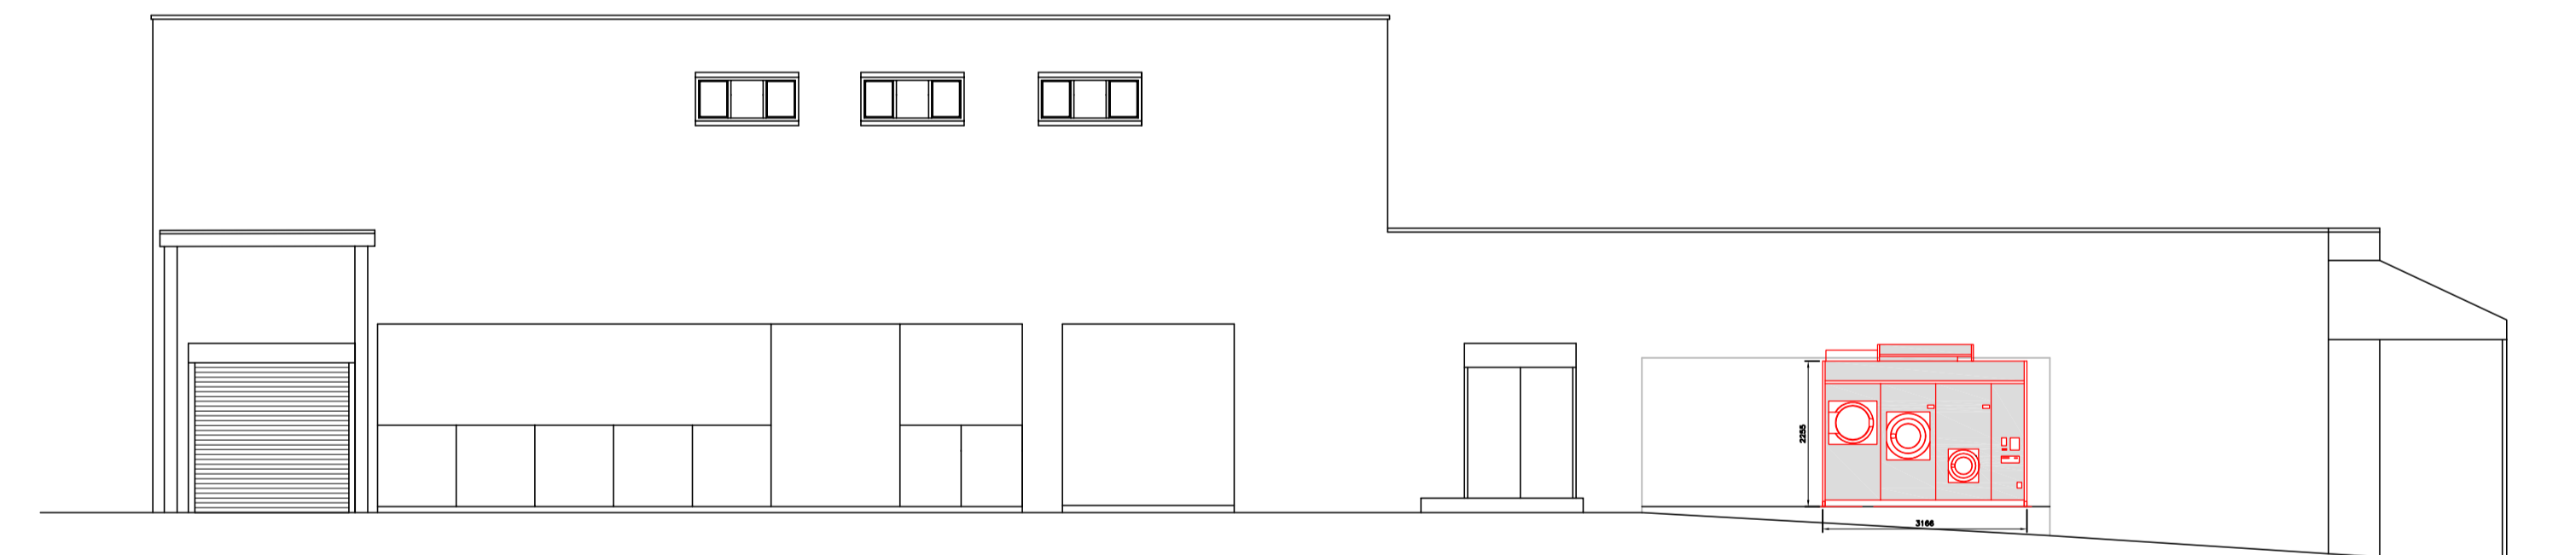


PROPOSED REAR ELEVATION 1:100



PROPOSED FRONT ELEVATION 1:100

 SCALE 1:100

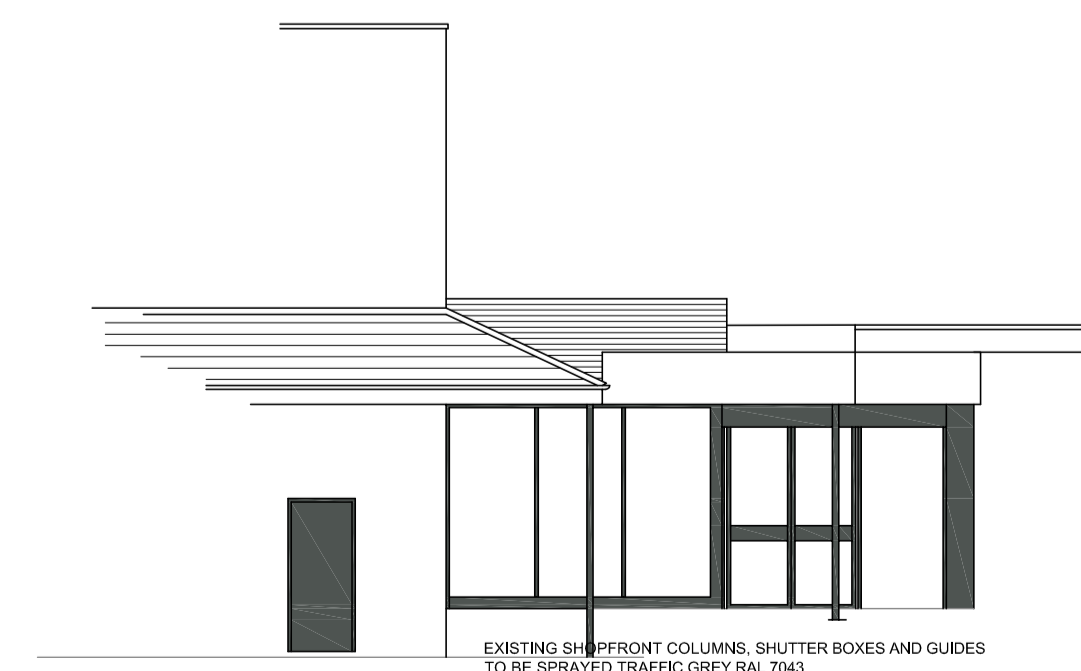

PROPOSED SIDE ELEVATION 1:100

© THE CONTENTS OF THIS DRAWING REMAIN THE SOLE PROPERTY OF WELLSFIELD ASSOCIATES AND MUST NOT BE COPIED OR REPRODUCED WITHOUT PRIOR PERMISSION.

FULL SURVEY NOT CARRIED OUT, DRAWING PRODUCED USING INFORMATION SUPPLIED BY THE CLIENT

**Wellsfield Associates**

York House  
Westview Drive  
Rayleigh, Essex.  
SS6 7AU  
Mob No 07766 221958  
chris@wellsfieldassociates.co.uk

project

CO-OP SUPERMARKET  
HIGH STREET  
CROWTHORNE  
BERKSHIRE  
RG45 7AF

PROP PLAN AND ELEVATIONS

date MAR 24 drawn C.J.J.

scale 1:100 @A1 drg no. 3868.11