


VISUAL SCALE 1:500 @ A3

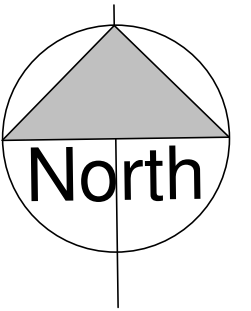


DRAINAGE

Roof Area 157m²
Connect to existing StormWater system.

Refer to Crandon Construction As Built External Works Plan for Existing Drainage Information 1475-08

storm →

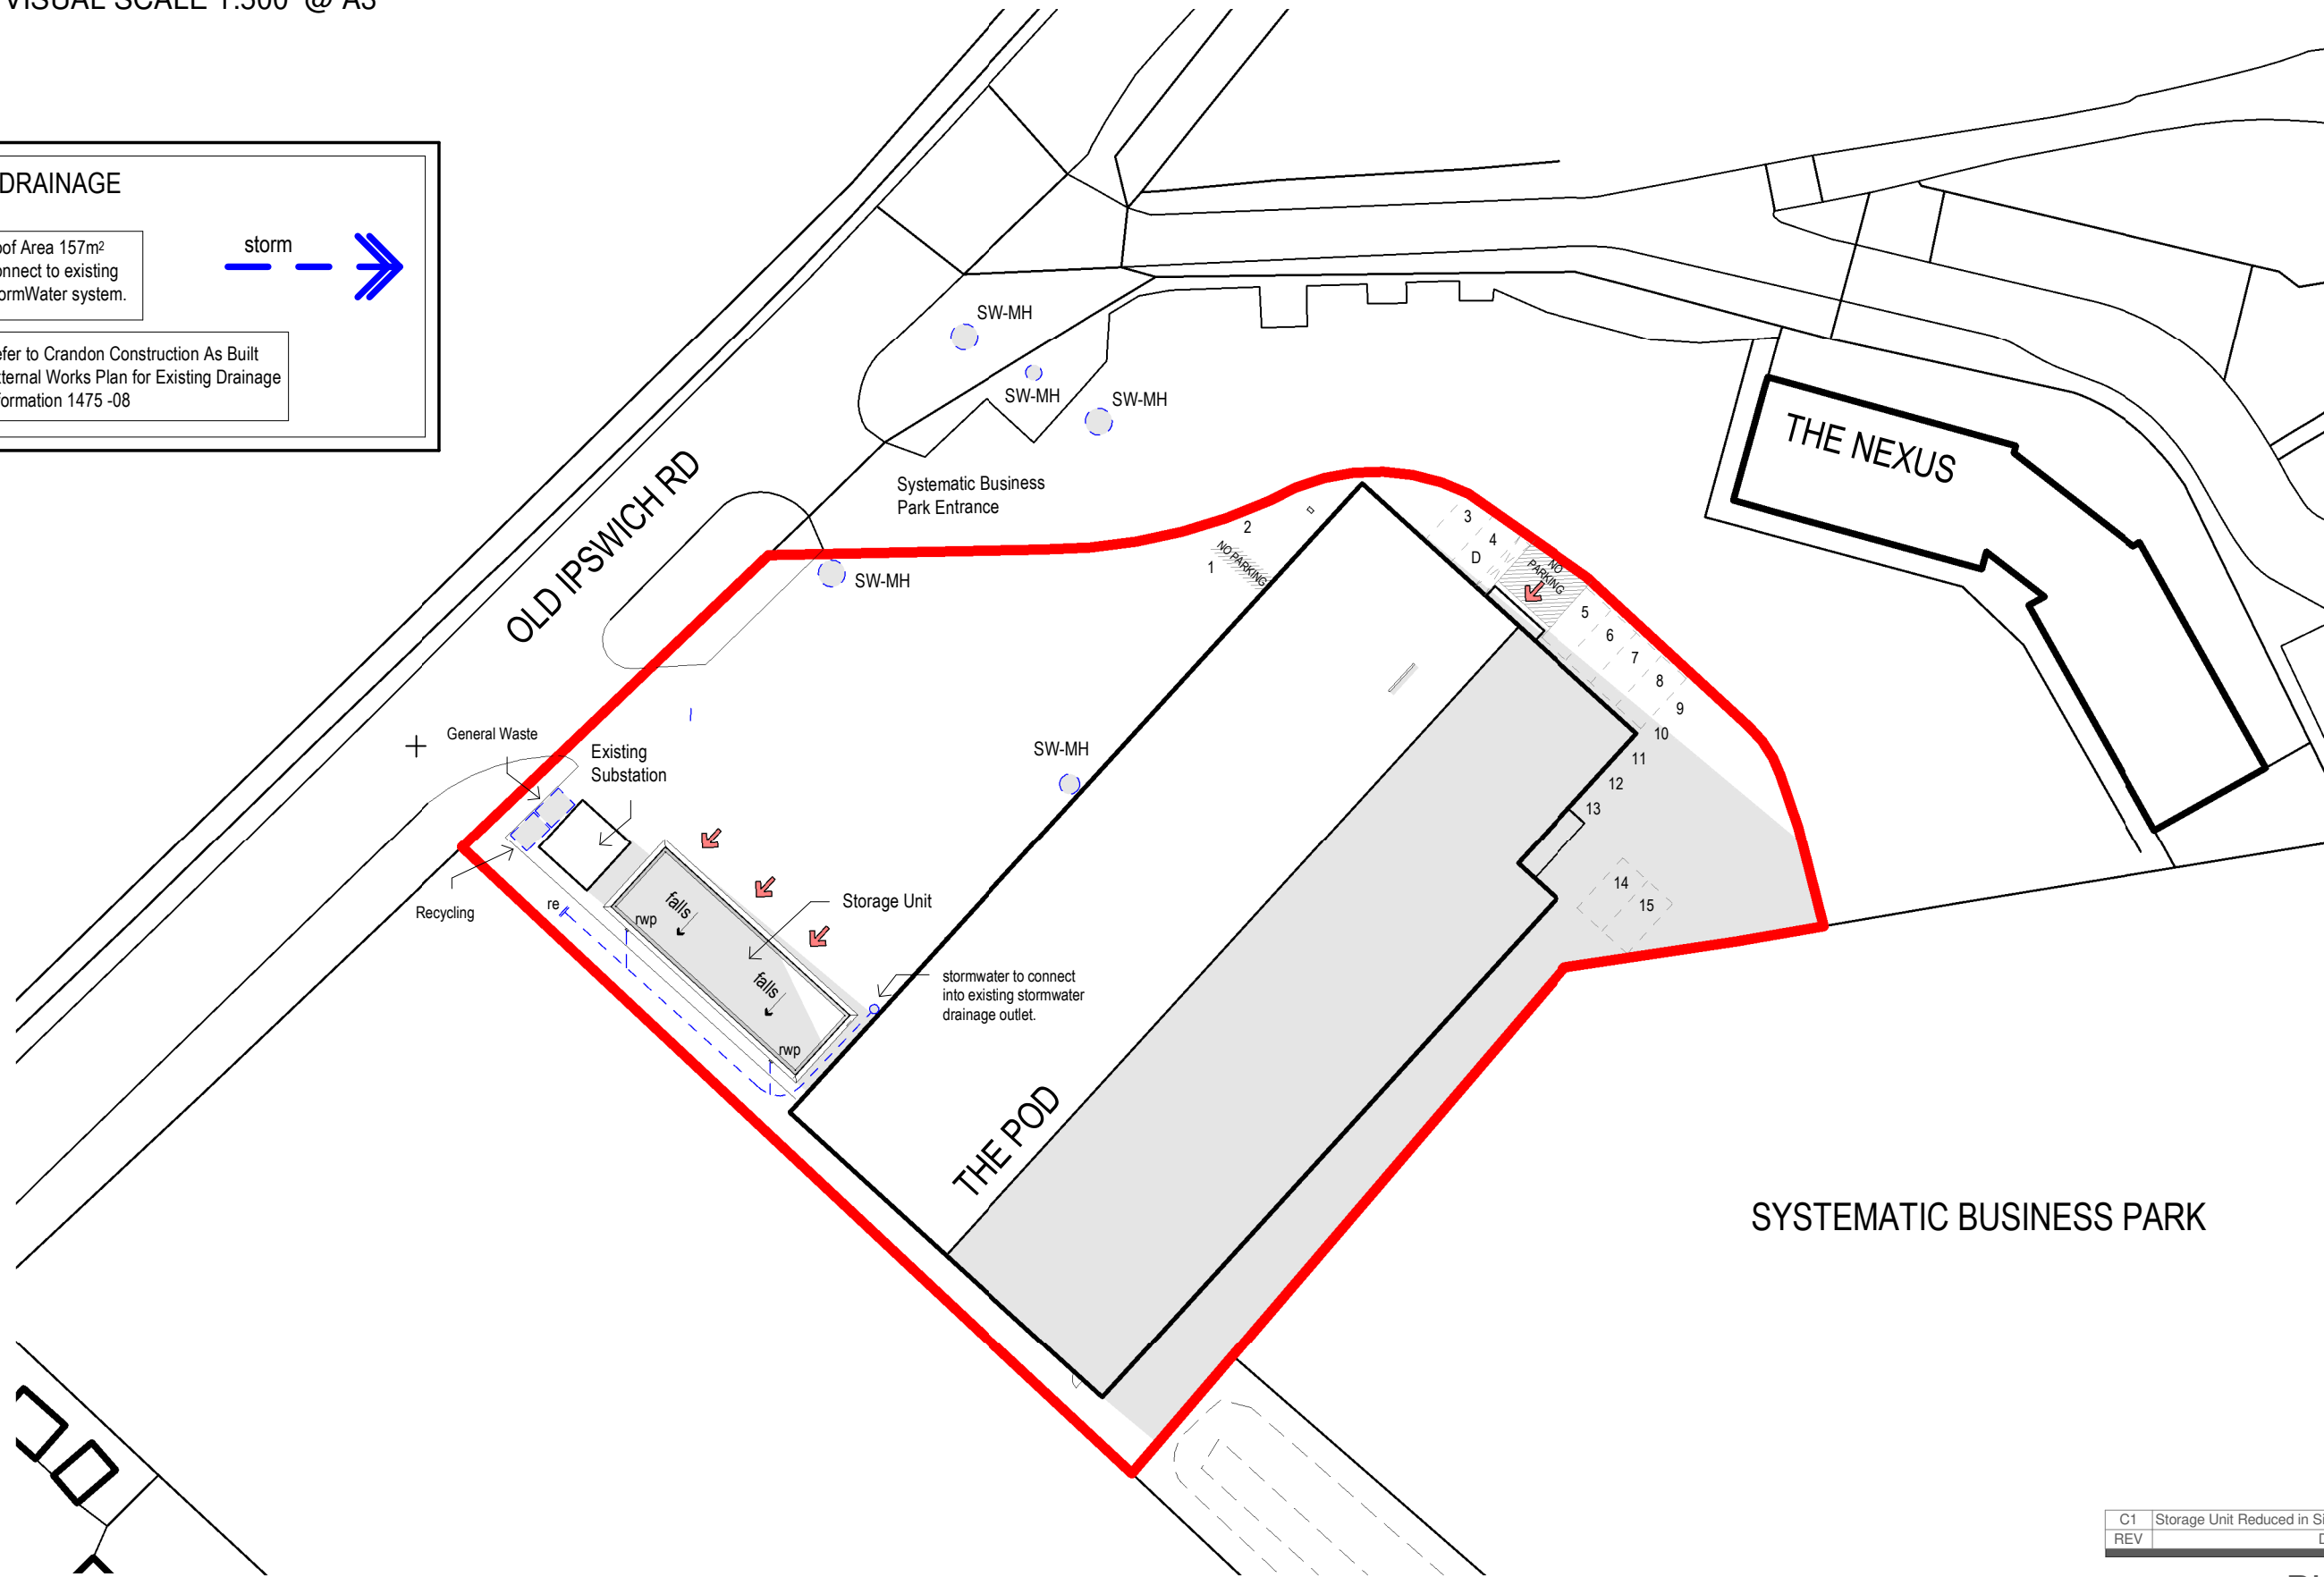

C1	Storage Unit Reduced in Size. To have a Green Roof	03.04.24
REV	DESCRIPTION	DATE

PLANNING

CLIENT
JA Brooks Mechanical Services

DRAWN
SN

DRAWING
Proposed Site Plan



PROJECT
Storage Unit @ The Pod

SCALE
1 : 500 @ A3

DRAWING NUMBER
2329-1103-C1

DATE
February 2024

