

### KEY TO SYMBOLS




### Low Level Path Lighting

Lanea Path Lighting Bollard with PIR sensor.


#### BenXDits:

- LED mains wired.
- Low level height, only 40cm high.
- LED bulbs installed into this pillar lamp are in such a manner that they shine downwards onto cascading reflectors, keeping all light at low level.
- Integrated PIR sensor, keeping light levels low and only on when required.
- Range 2-8metres, set at 5m as shown.
- Lighting duration (5 seconds to 6 minutes) are configurable.
- Detects movement at an angle of 90 degrees.

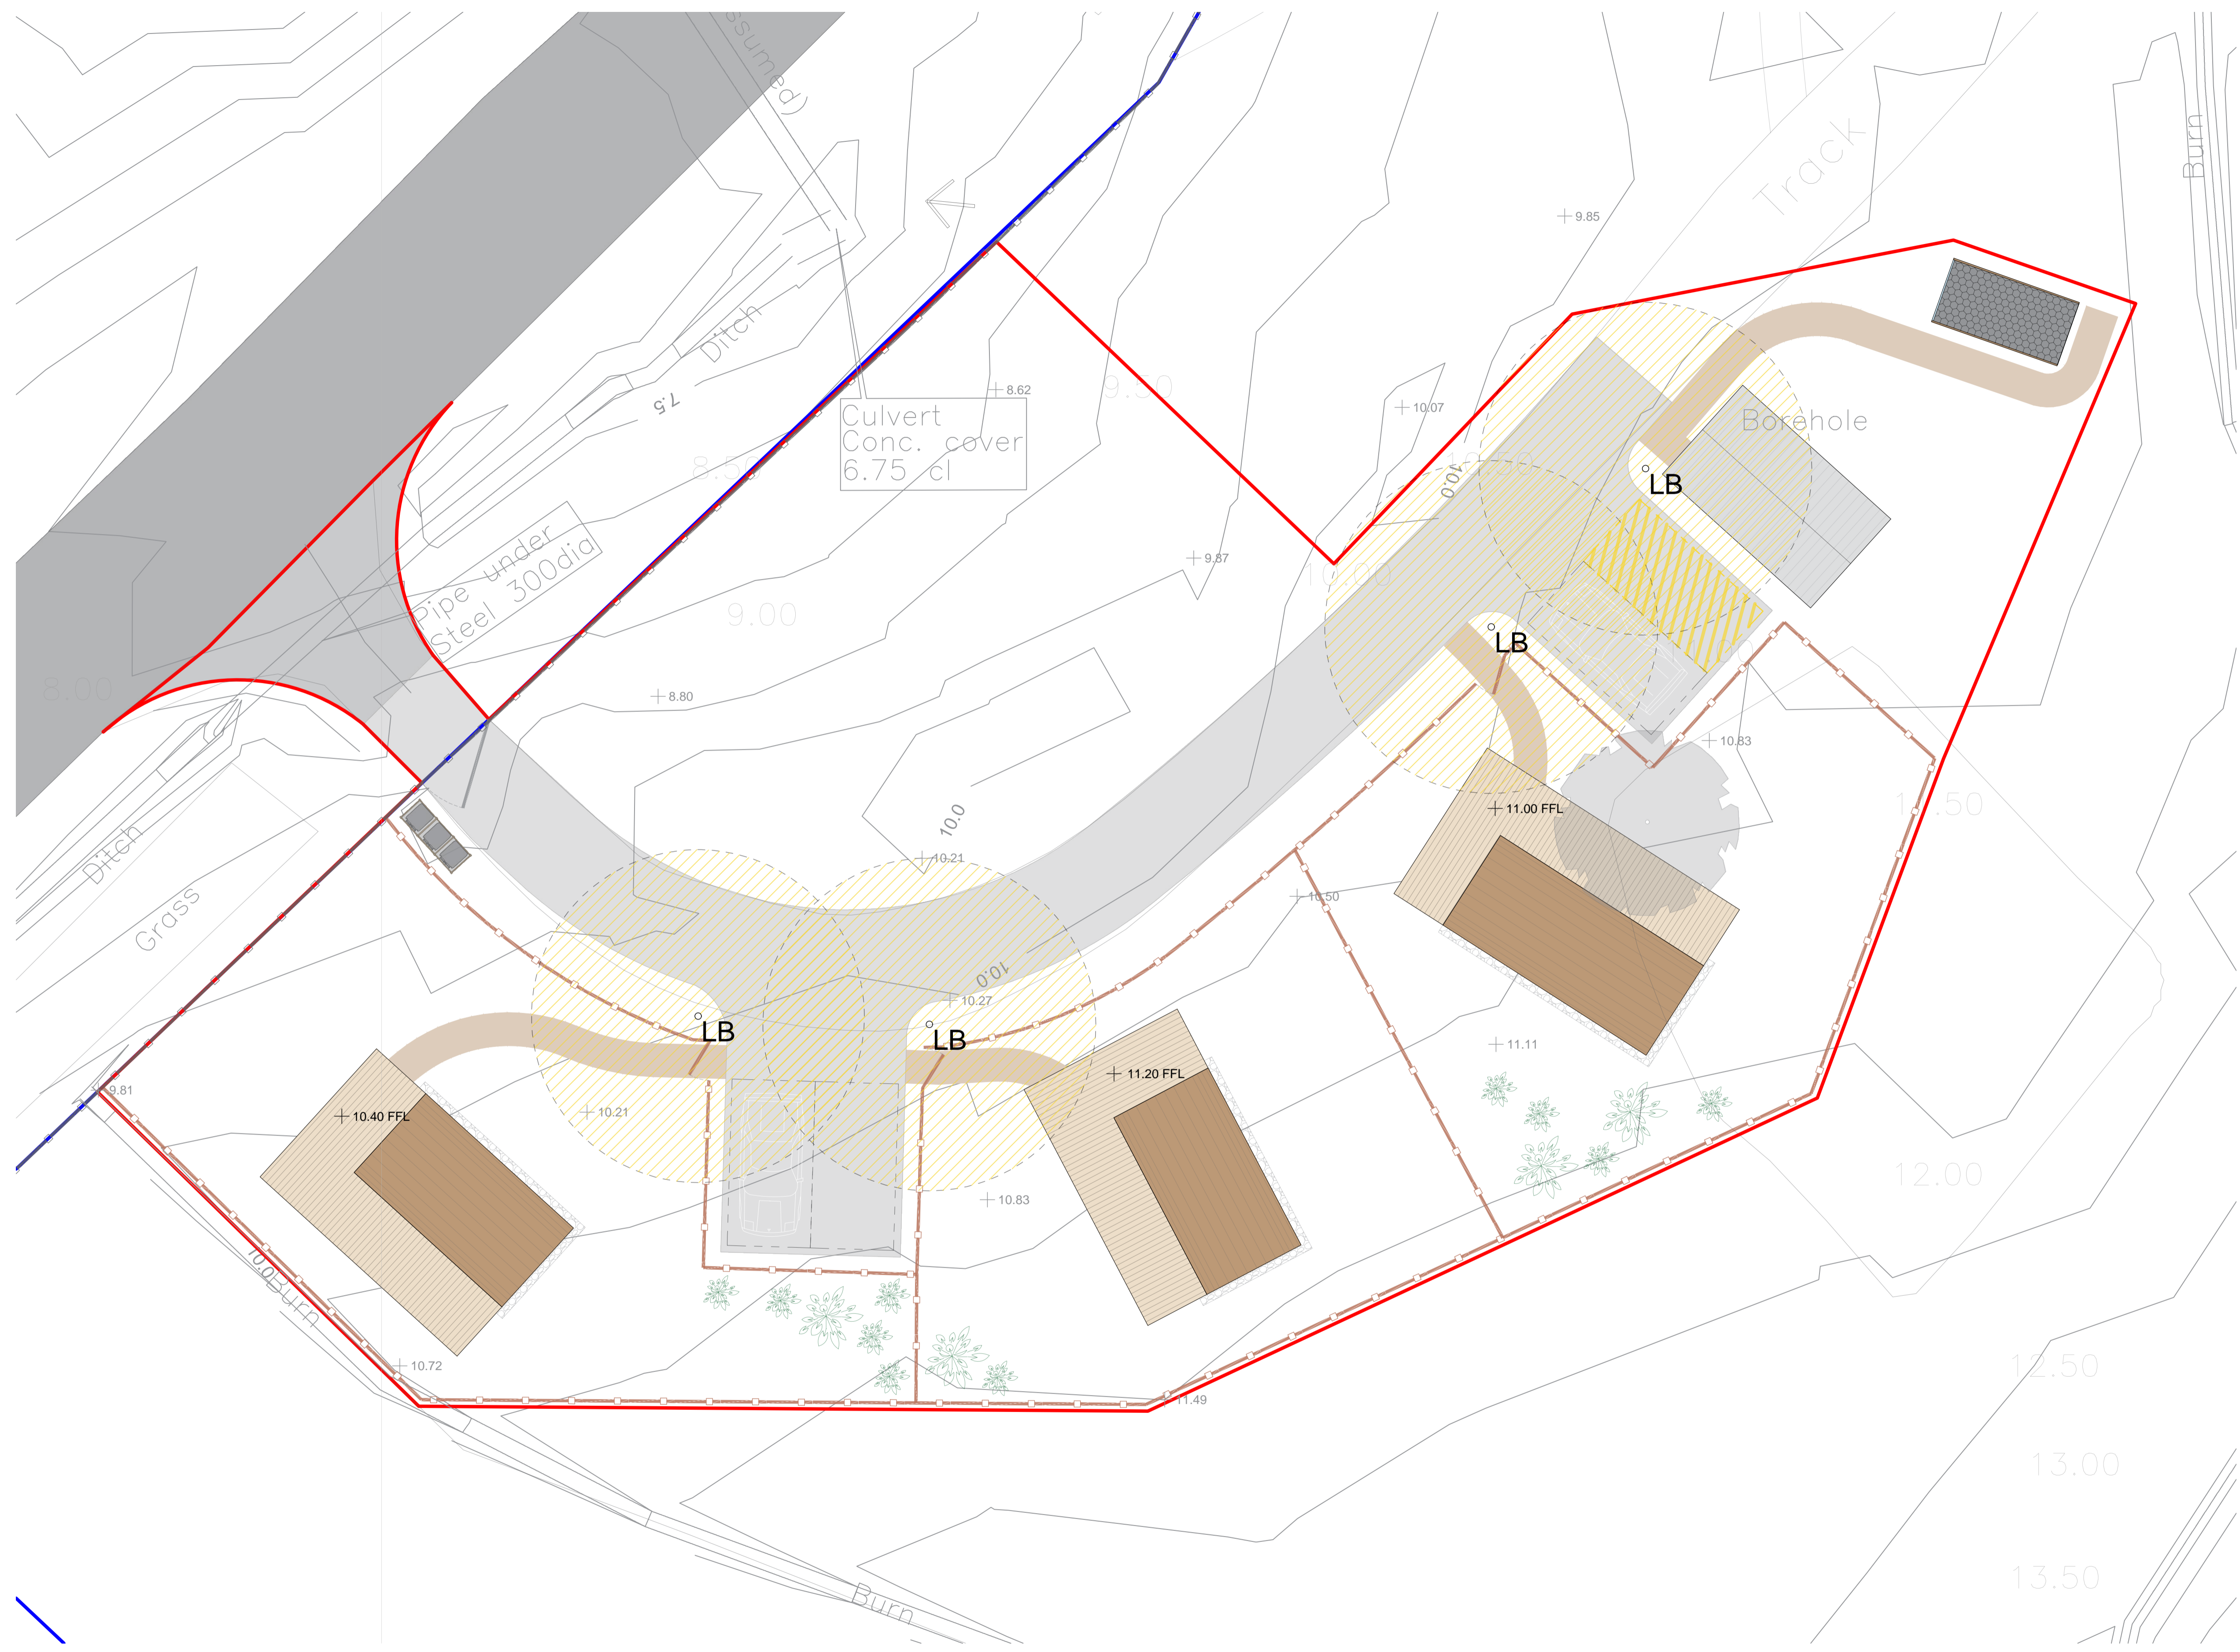

Date	Description	Rev	By
29.03.24	Add data from topo, adjust pod positions	A	XD

### Revision Description

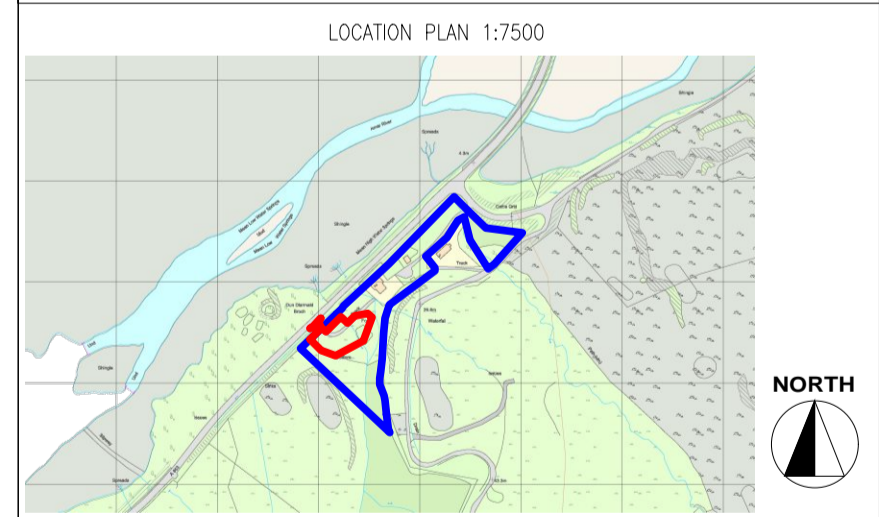

Project:  
**Proposed Glamping Site - For Keith Mabbott**  
 2 Coillire, Struan, Isle of Skye  
 IV56 8FX

Drawing Title:  
**PROPOSED LIGHTING PLAN**

Drawing Number:  
**231221-01-07**

Revision: A  
 Date: 16.01.2024  
 Scale: 1:100 @ A1  
 Drawn By: XD  
 CAD Dwg File: -  
 Checked By: -

Issue Status:  
**Full Planning Application**

OWNERSHIP BOUNDARY  
 AREA = 1.1 ha.

SITE BOUNDARY  
 SITE AREA = 1,470 m2

