

KEY TO SYMBOLS




Low Level Path Lighting

Lanea Path Lighting Bollard with PIR sensor.



BenXDits:

- LED mains wired.
- Low level height, only 40cm high.
- LED bulbs installed into this pillar lamp are in such a manner that they shine downwards onto cascading reflectors, keeping all light at low level.
- Integrated PIR sensor, keeping light levels low and only on when required.
- Range 2-8metres, set at 5m as shown.
- Lighting duration (5 seconds to 6 minutes) are configurable.
- Detects movement at an angle of 90 degrees.

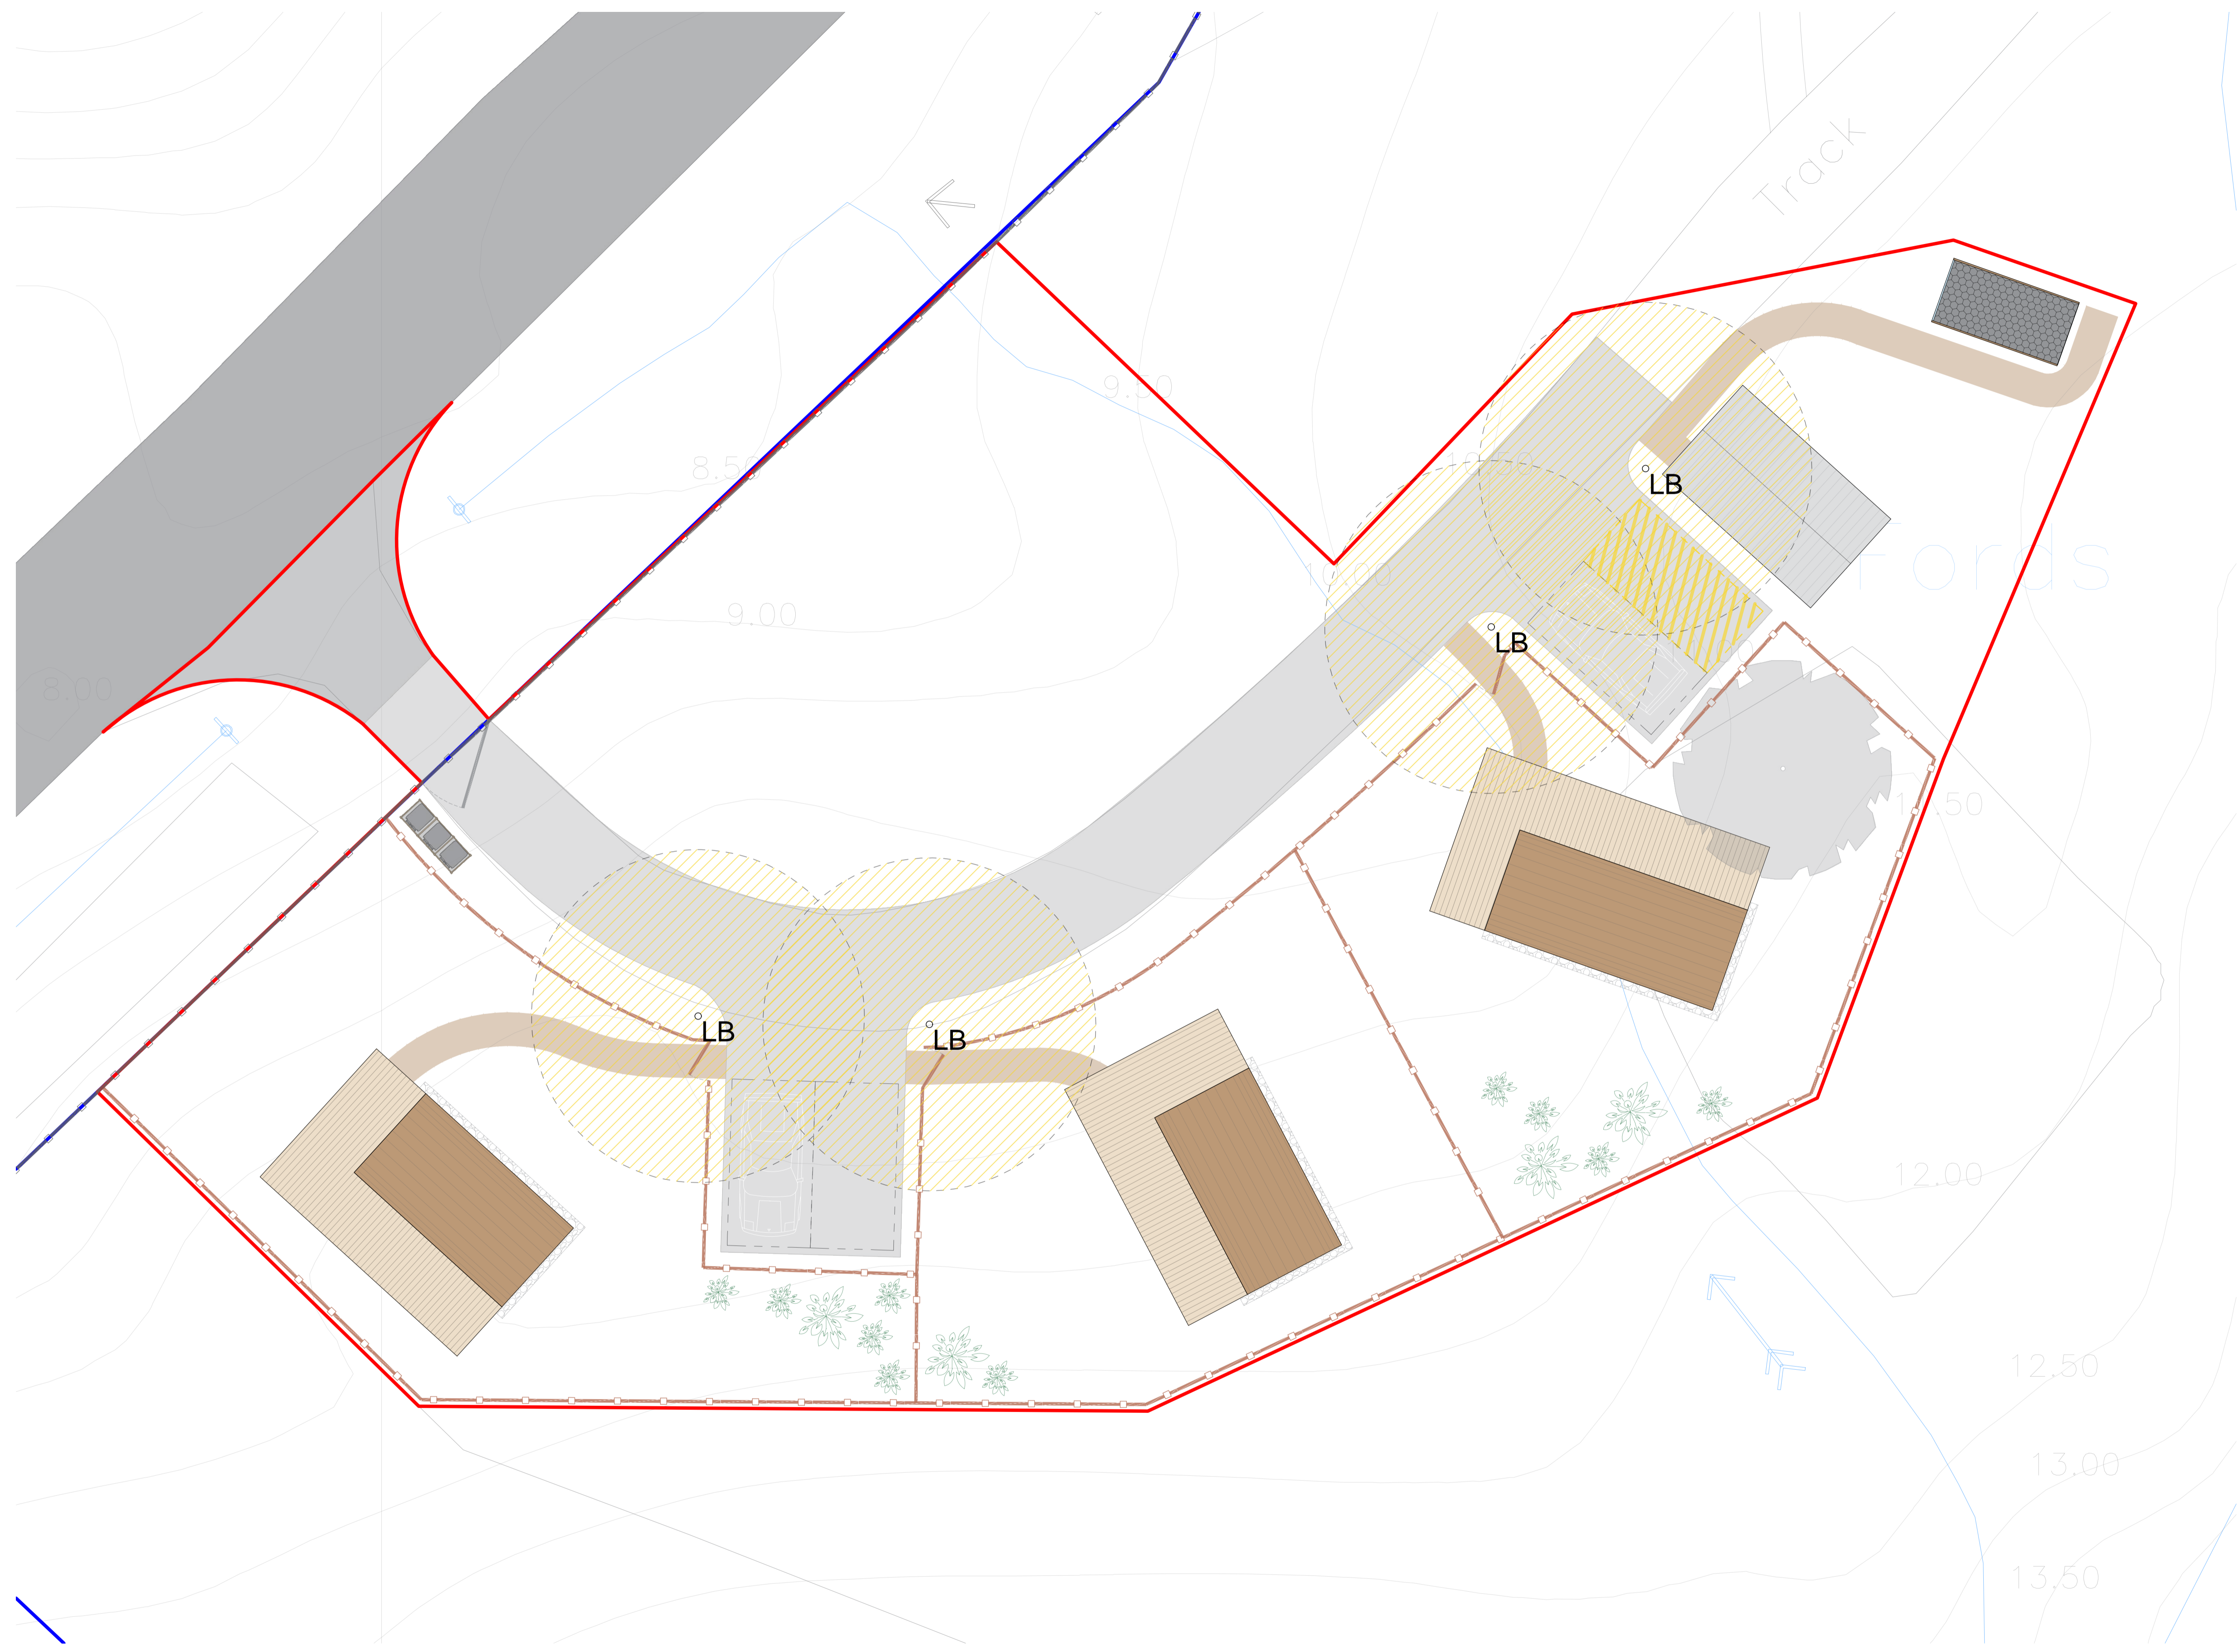


OWNERSHIP BOUNDARY
 AREA = 1.1 ha.

SITE BOUNDARY
 SITE AREA = 1,470 m²

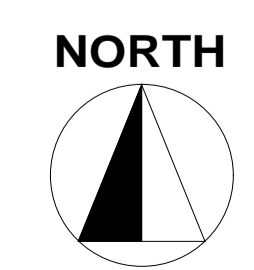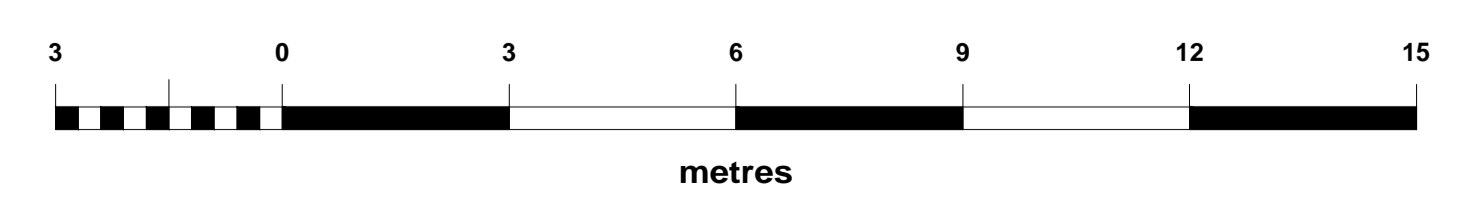

Date	Description	Rev	By

Revision Description

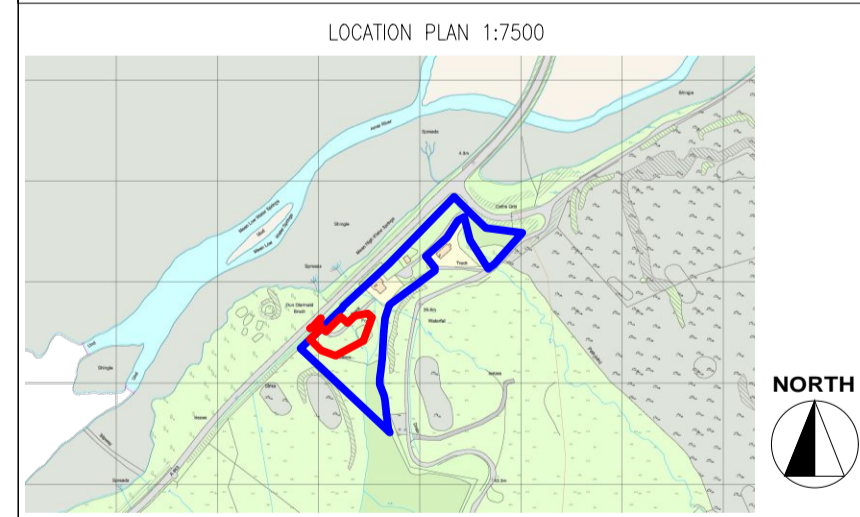

Project:
 Proposed Glamping Site - For Keith Mabbott
 2 Coillore, Struan, Isle of Skye
 IV56 8FX

Drawing Title:
 PROPOSED LIGHTING PLAN

Drawing Number:
 231221-01-07

Revision: -
Date: 16.01.2024
Scale: 1:100 @ A1
Drawn By: XD
CAD Dwg File: -
Checked By: -

Issue Status:
 Full Planning Application A1