



VENTILATION SCHEDULE							
Ref. No.	Type	Make	Model	Airflow	Dimensions (L x W x D) (mm)	Weight (kg)	Electrical Supply
SF-01	Supply Fan	System Air	MUB 100 630D4-L		1020 x 1020 x 1020	161.5	400V 3P&N 50Hz
EF-01	Extract Fan	Heilos	GBD710/4/3		1020 x 1020 x 1020	170	400V 3P&N 50Hz
SFI-01	Supply Filter	TBC	TBC	N/A	TBC	TBC	N/A
EFI-01	Carbon Filter	Purified Air	4No. MFU 1200 A1	N/A	1850 x 1245 x 1260	748	N/A
ESP-01	Electrostatic Precipitator	Purified Air	ESP4500		1350 x 630 x 640	118	40W
ESP-02	Electrostatic Precipitator	Purified Air	ESP4500		1350 x 630 x 640	118	40W

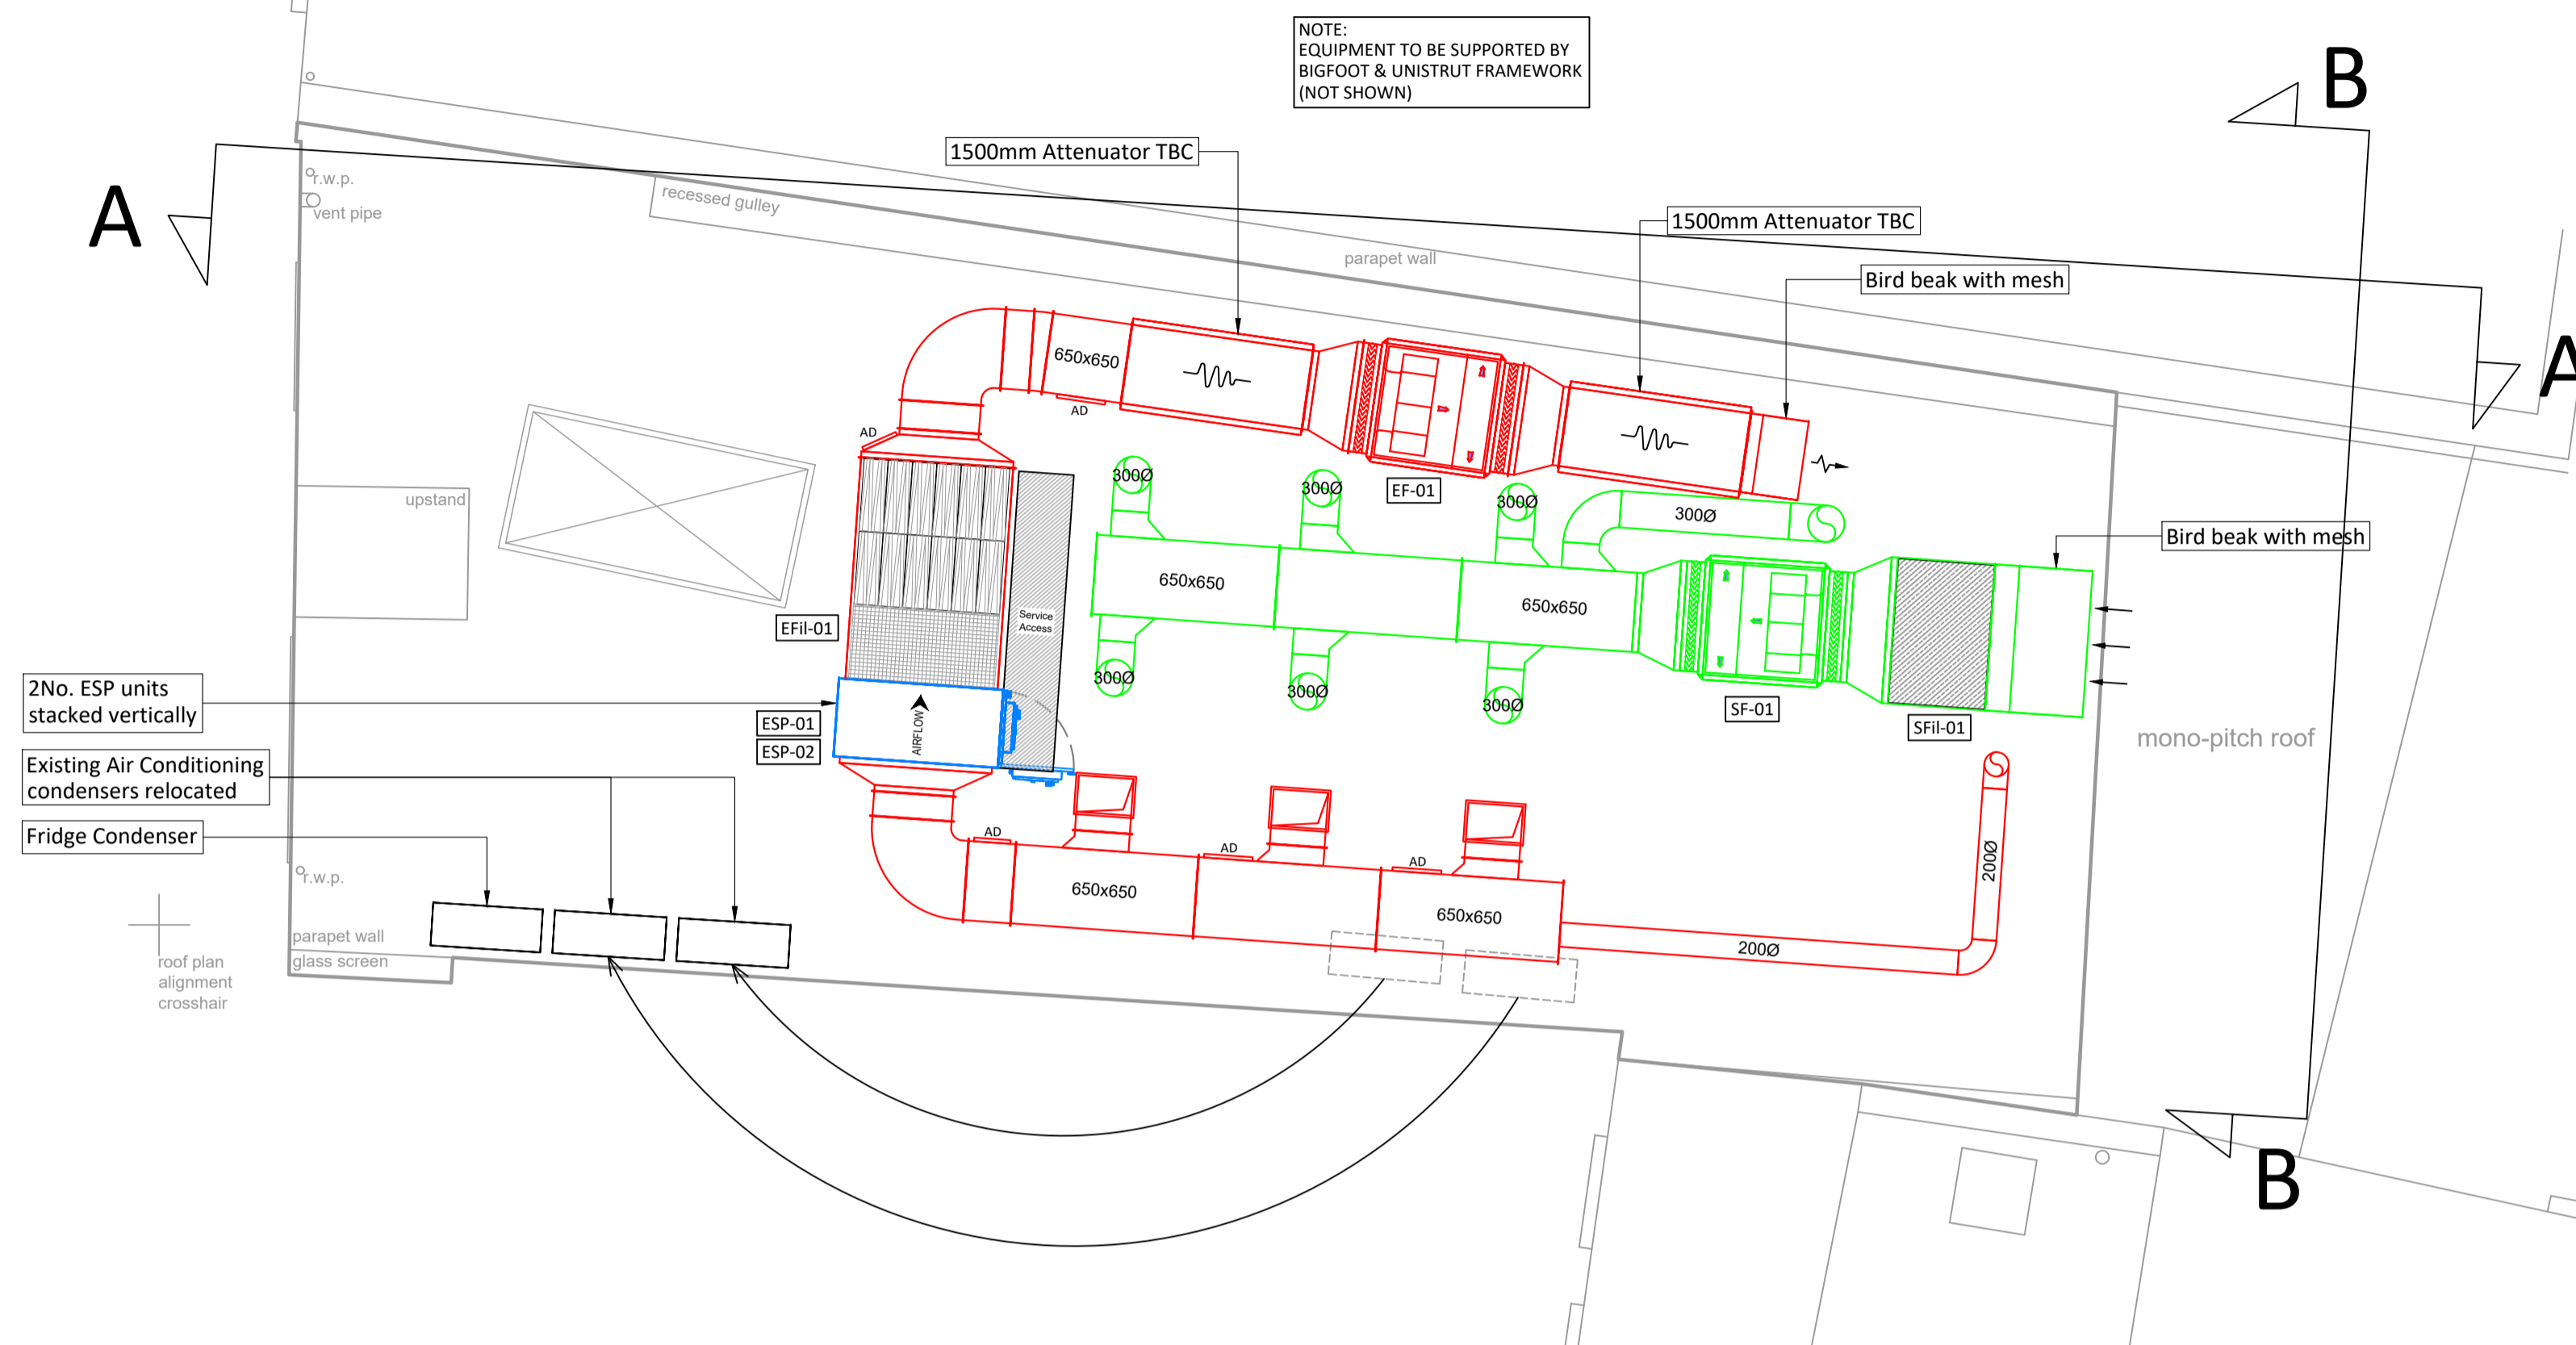


NOTES:

THIS DRAWING MUST NOT BE SCALED; ALL SETTING OUT MUST BE CHECKED ON SITE; ALL DIMENSIONS MUST BE CHECKED ON SITE; THIS DRAWING MUST BE READ IN CONJUNCTION WITH THE RELEVANT SPECIFICATION CLAUSES; THIS DRAWING MUST NOT BE USED FOR LAND TRANSFER PURPOSE

COPYRIGHT OF LEECH GROUP SERVICES, LEECH MECHANICAL SERVICES & POSITIVE FACILITIES MAINTENANCE

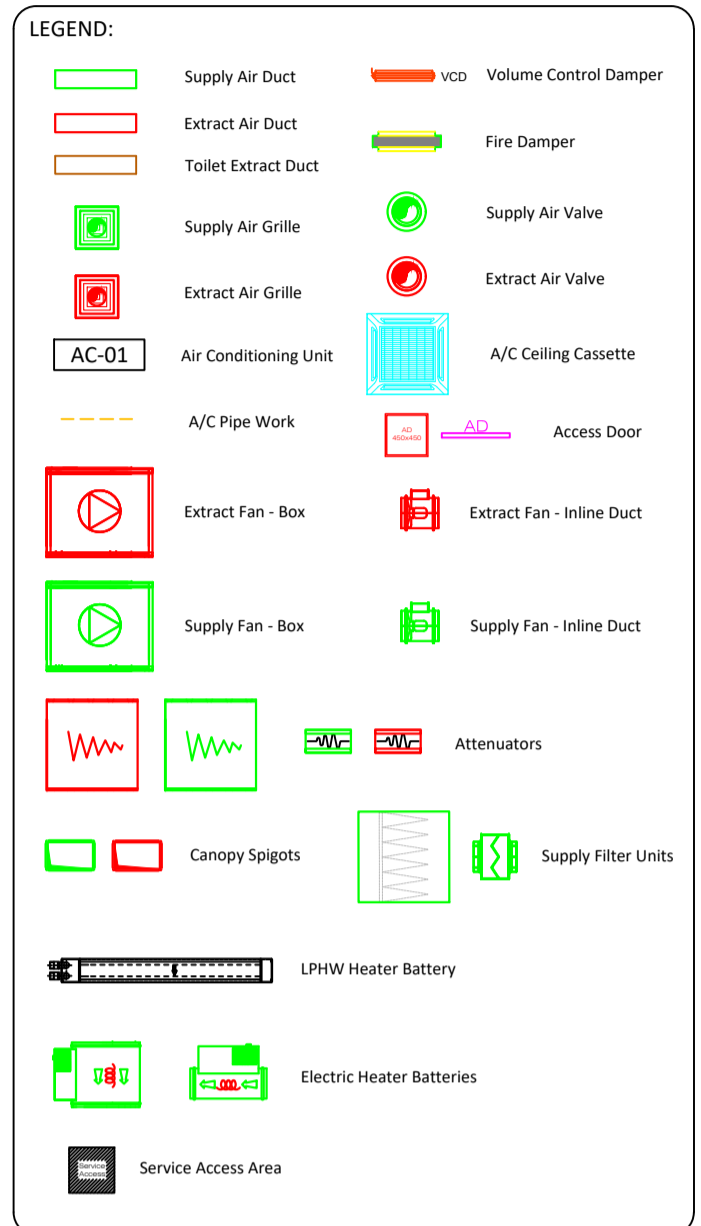

ELEVATION A-A

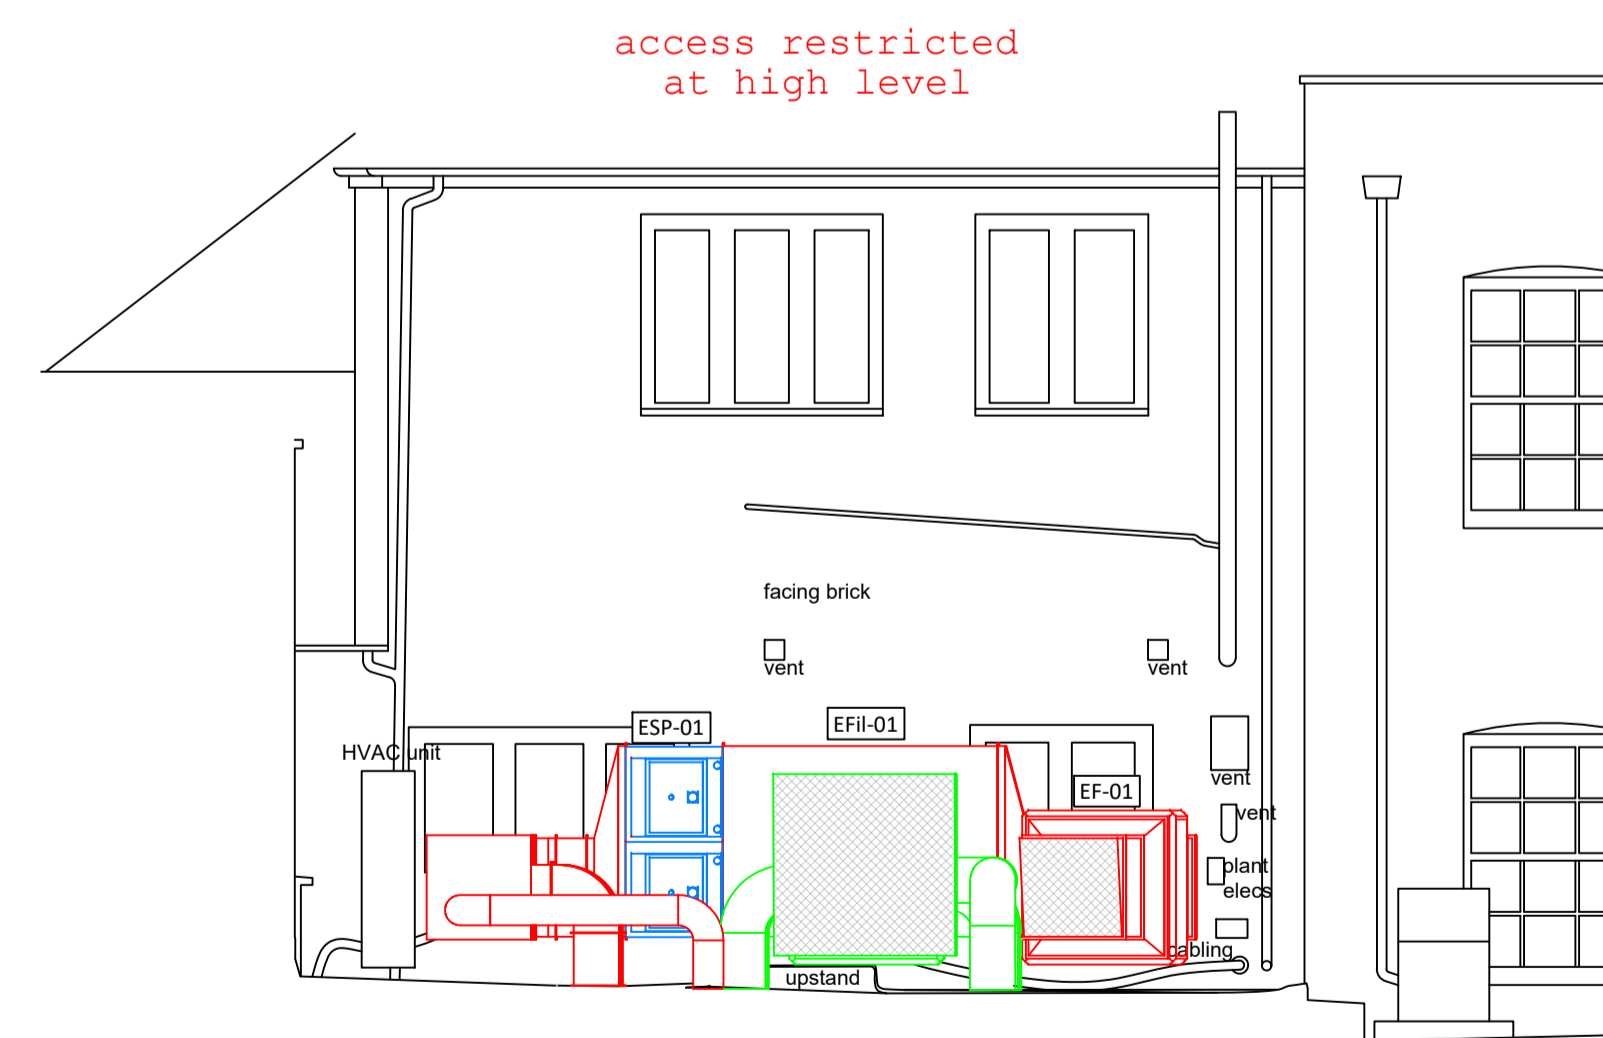

ELEVATION B-B

LEECH

Unit 17, Mapledean Works,  
Maldon Road, Latchingdon,  
Essex, CM3 6LG  
Tel: +44 (0)1621 742424,  
Email: help@leechgroupservices.co.uk  
[www.leechgroupservices.co.uk](http://www.leechgroupservices.co.uk)



H.			
G.			
F.			
E.			
D.			
C.			
B.			
A.	CH	Design Development...Door Curtain Added Further additions to be made in due course	---
Rev	Rev by	Description	Date

PROJECT:  
**Pho Greenwich**  
**18 Greenwich Church St,**  
**London SE10 9BJ**

TITLE:  
**Proposed Roof & Elevations**  
**HVAC Layout**

PROJECT NUMBER:	QU003917
DATE:	05/04/2024
DRAWN BY:	MF
CHECKED BY:	RR
DRAWING NO:	QU003917/003 Rev 0
SCALE	1:50@A1 - 1:100@A3