



NOTES:

THIS DRAWING MUST NOT BE SCALED; ALL SETTING OUT MUST BE CHECKED ON SITE; ALL DIMENSIONS MUST BE CHECKED ON SITE; THIS DRAWING MUST BE READ IN CONJUNCTION WITH THE RELEVANT SPECIFICATION CLAUSES; THIS DRAWING MUST NOT BE USED FOR LAND TRANSFER PURPOSE

COPYRIGHT OF LEECH GROUP SERVICES, LEECH MECHANICAL SERVICES & POSITIVE FACILITIES MAINTENANCE

LEGEND:

	Supply Air Duct		Volume Control Damper
	Extract Air Duct		Fire Damper
	Toilet Extract Duct		Supply Air Valve
	Supply Air Grille		Extract Air Valve
	Extract Air Grille		A/C Ceiling Cassette
	Air Conditioning Unit		Access Door
	A/C Pipe Work		Extract Fan - In-line Duct
	Extract Fan - Box		Supply Fan - In-line Duct
	Supply Fan - Box		Supply Filter Units
	Attenuators		Supply Filter Units
	Canopy Spigots		Supply Filter Units
	LPHW Heater Battery		Supply Filter Units
	Electric Heater Batteries		Supply Filter Units
	Service Access Area		

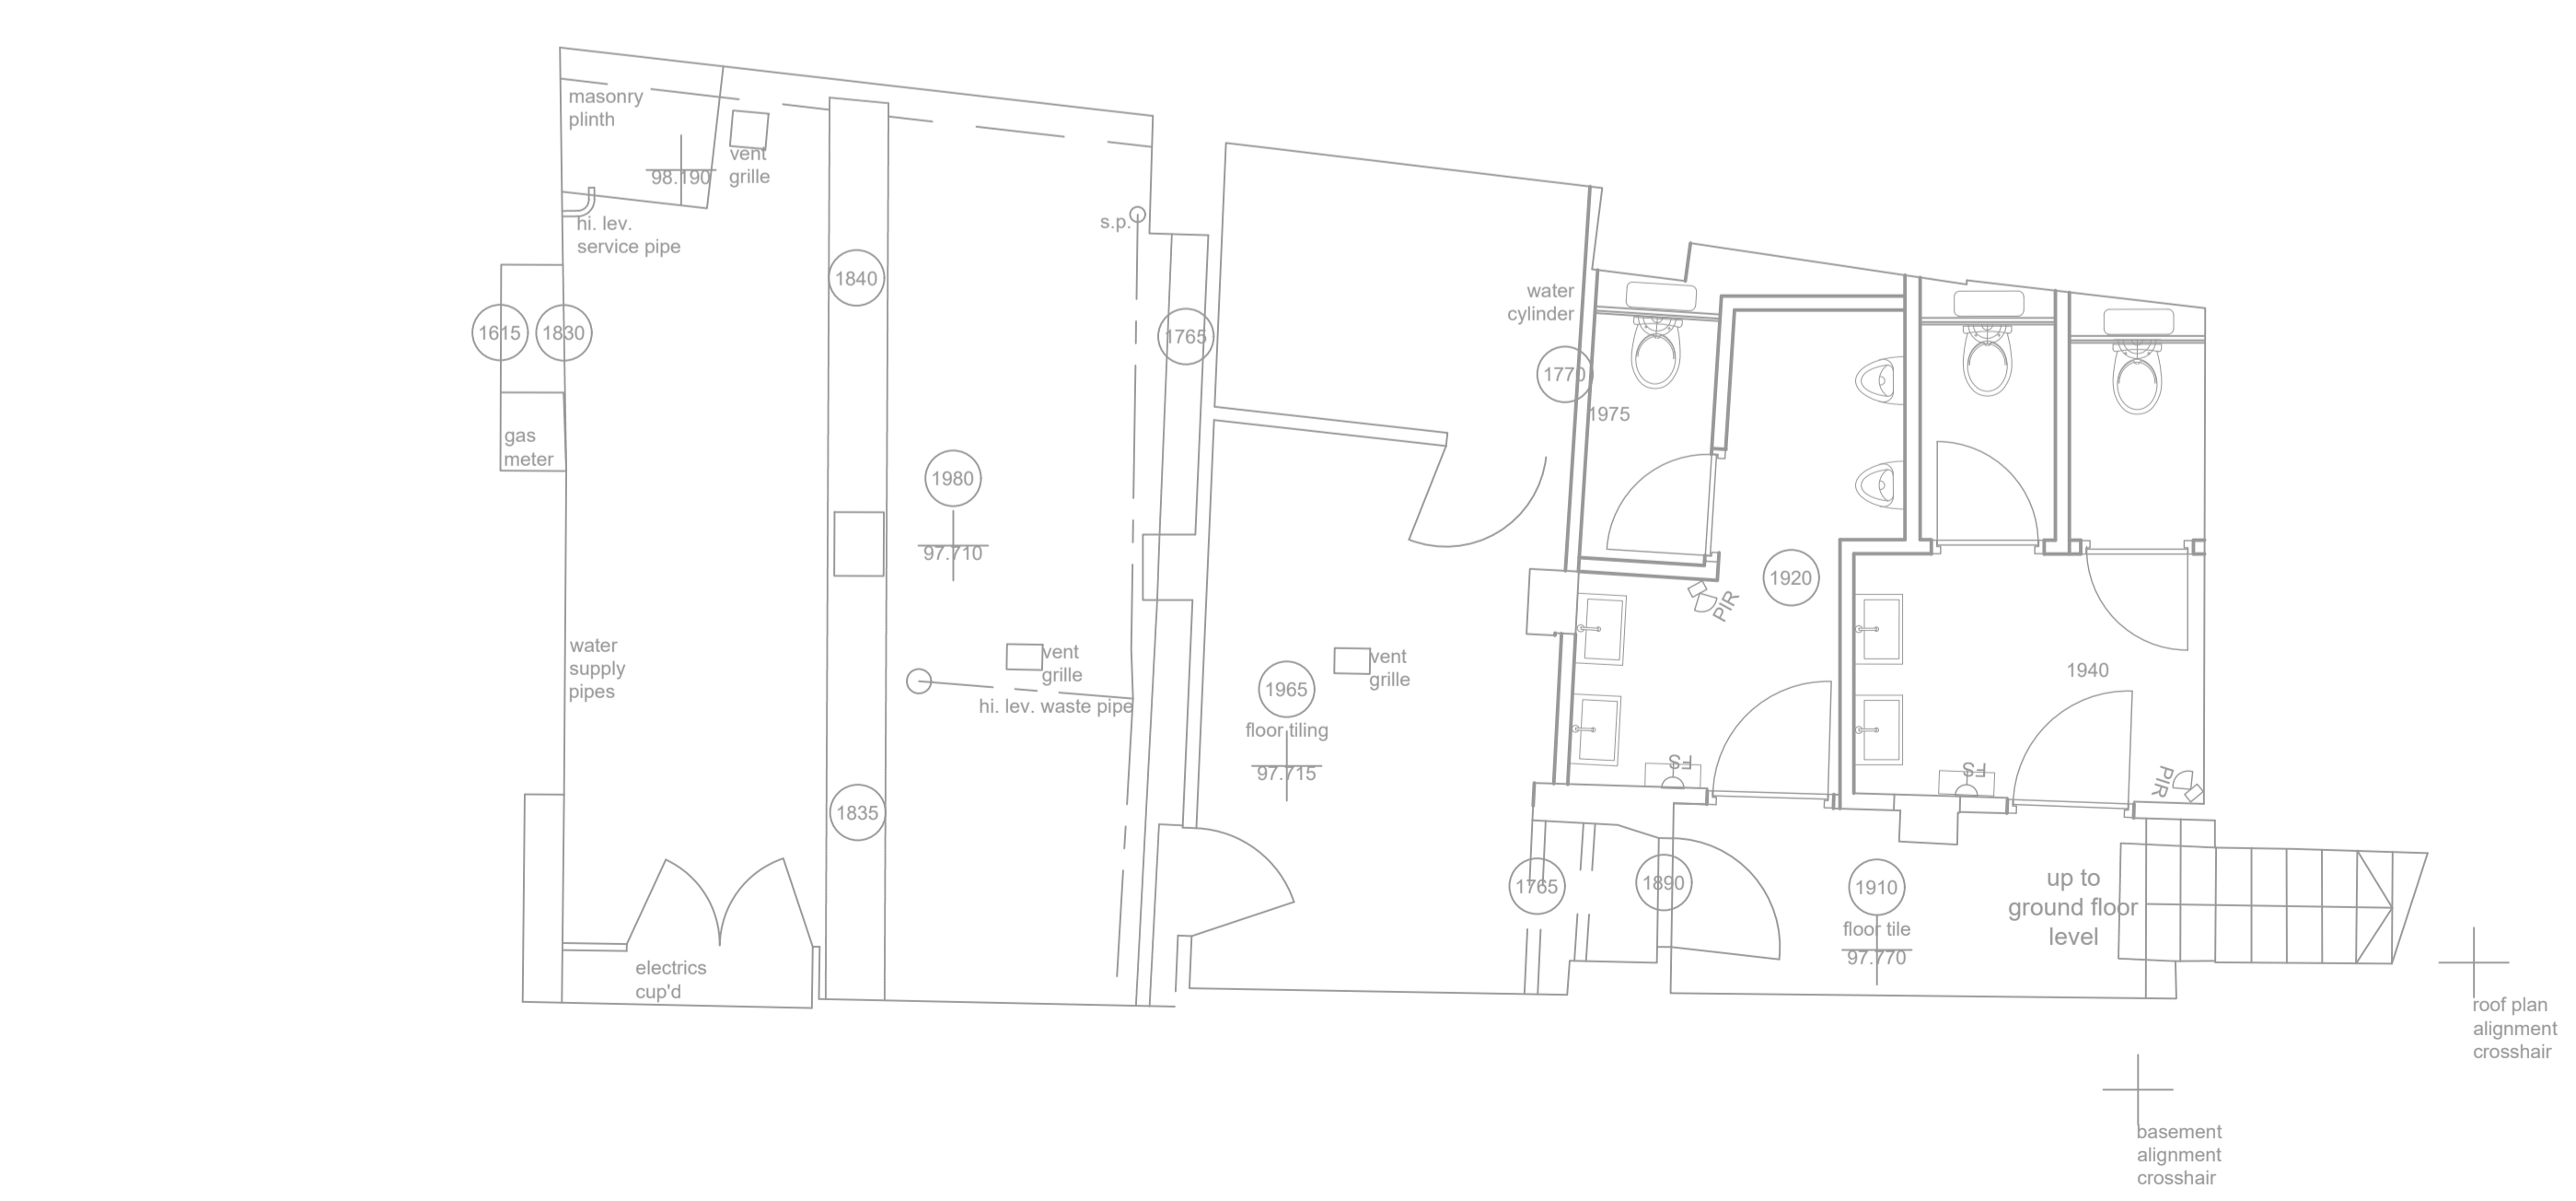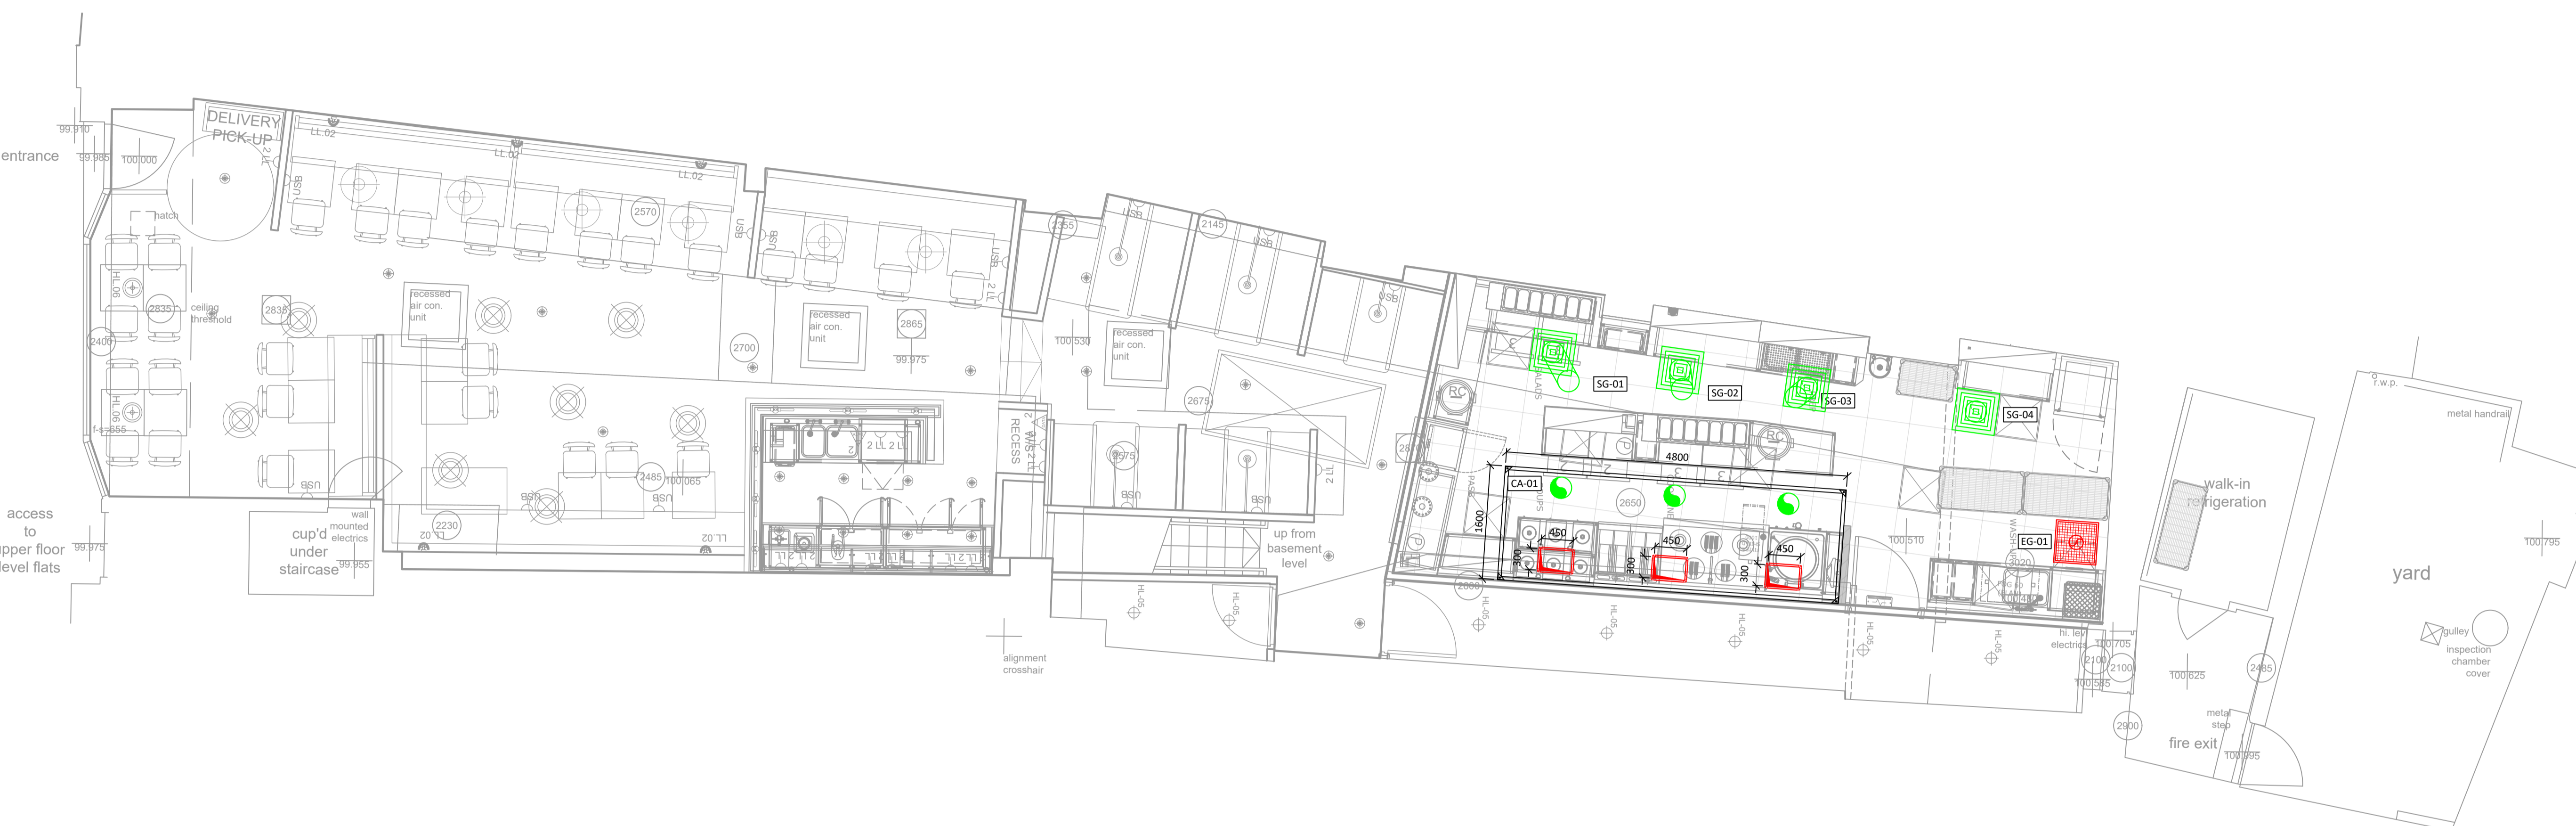

LEECH

Unit 17, Mapledan Works,
Maldon Road, Latchingdon,
Essex, CM3 6LG

Tel: +44 (0)1621 742424,
Email: help@leechgroupservices.co.uk
www.leechgroupservices.co.uk

SCAN ME

H.			
G.			
F.			
E.			
D.			
C.			
B.			
A.			
Rev	Rev by	Description	Date

PROJECT:

Pho Greenwich
18 Greenwich Church St,
London SE10 9BJ

TITLE:

Proposed HVAC Layout

PROJECT NUMBER:	QU003917
DATE:	25/03/2024
DRAWN BY:	MF
CHECKED BY:	RR
DRAWING NO:	QU003917/001 Rev 0
SCALE:	1:50@ A1 - 1:100@A3