



FLOOR PLAN AS EXISTING 1:50

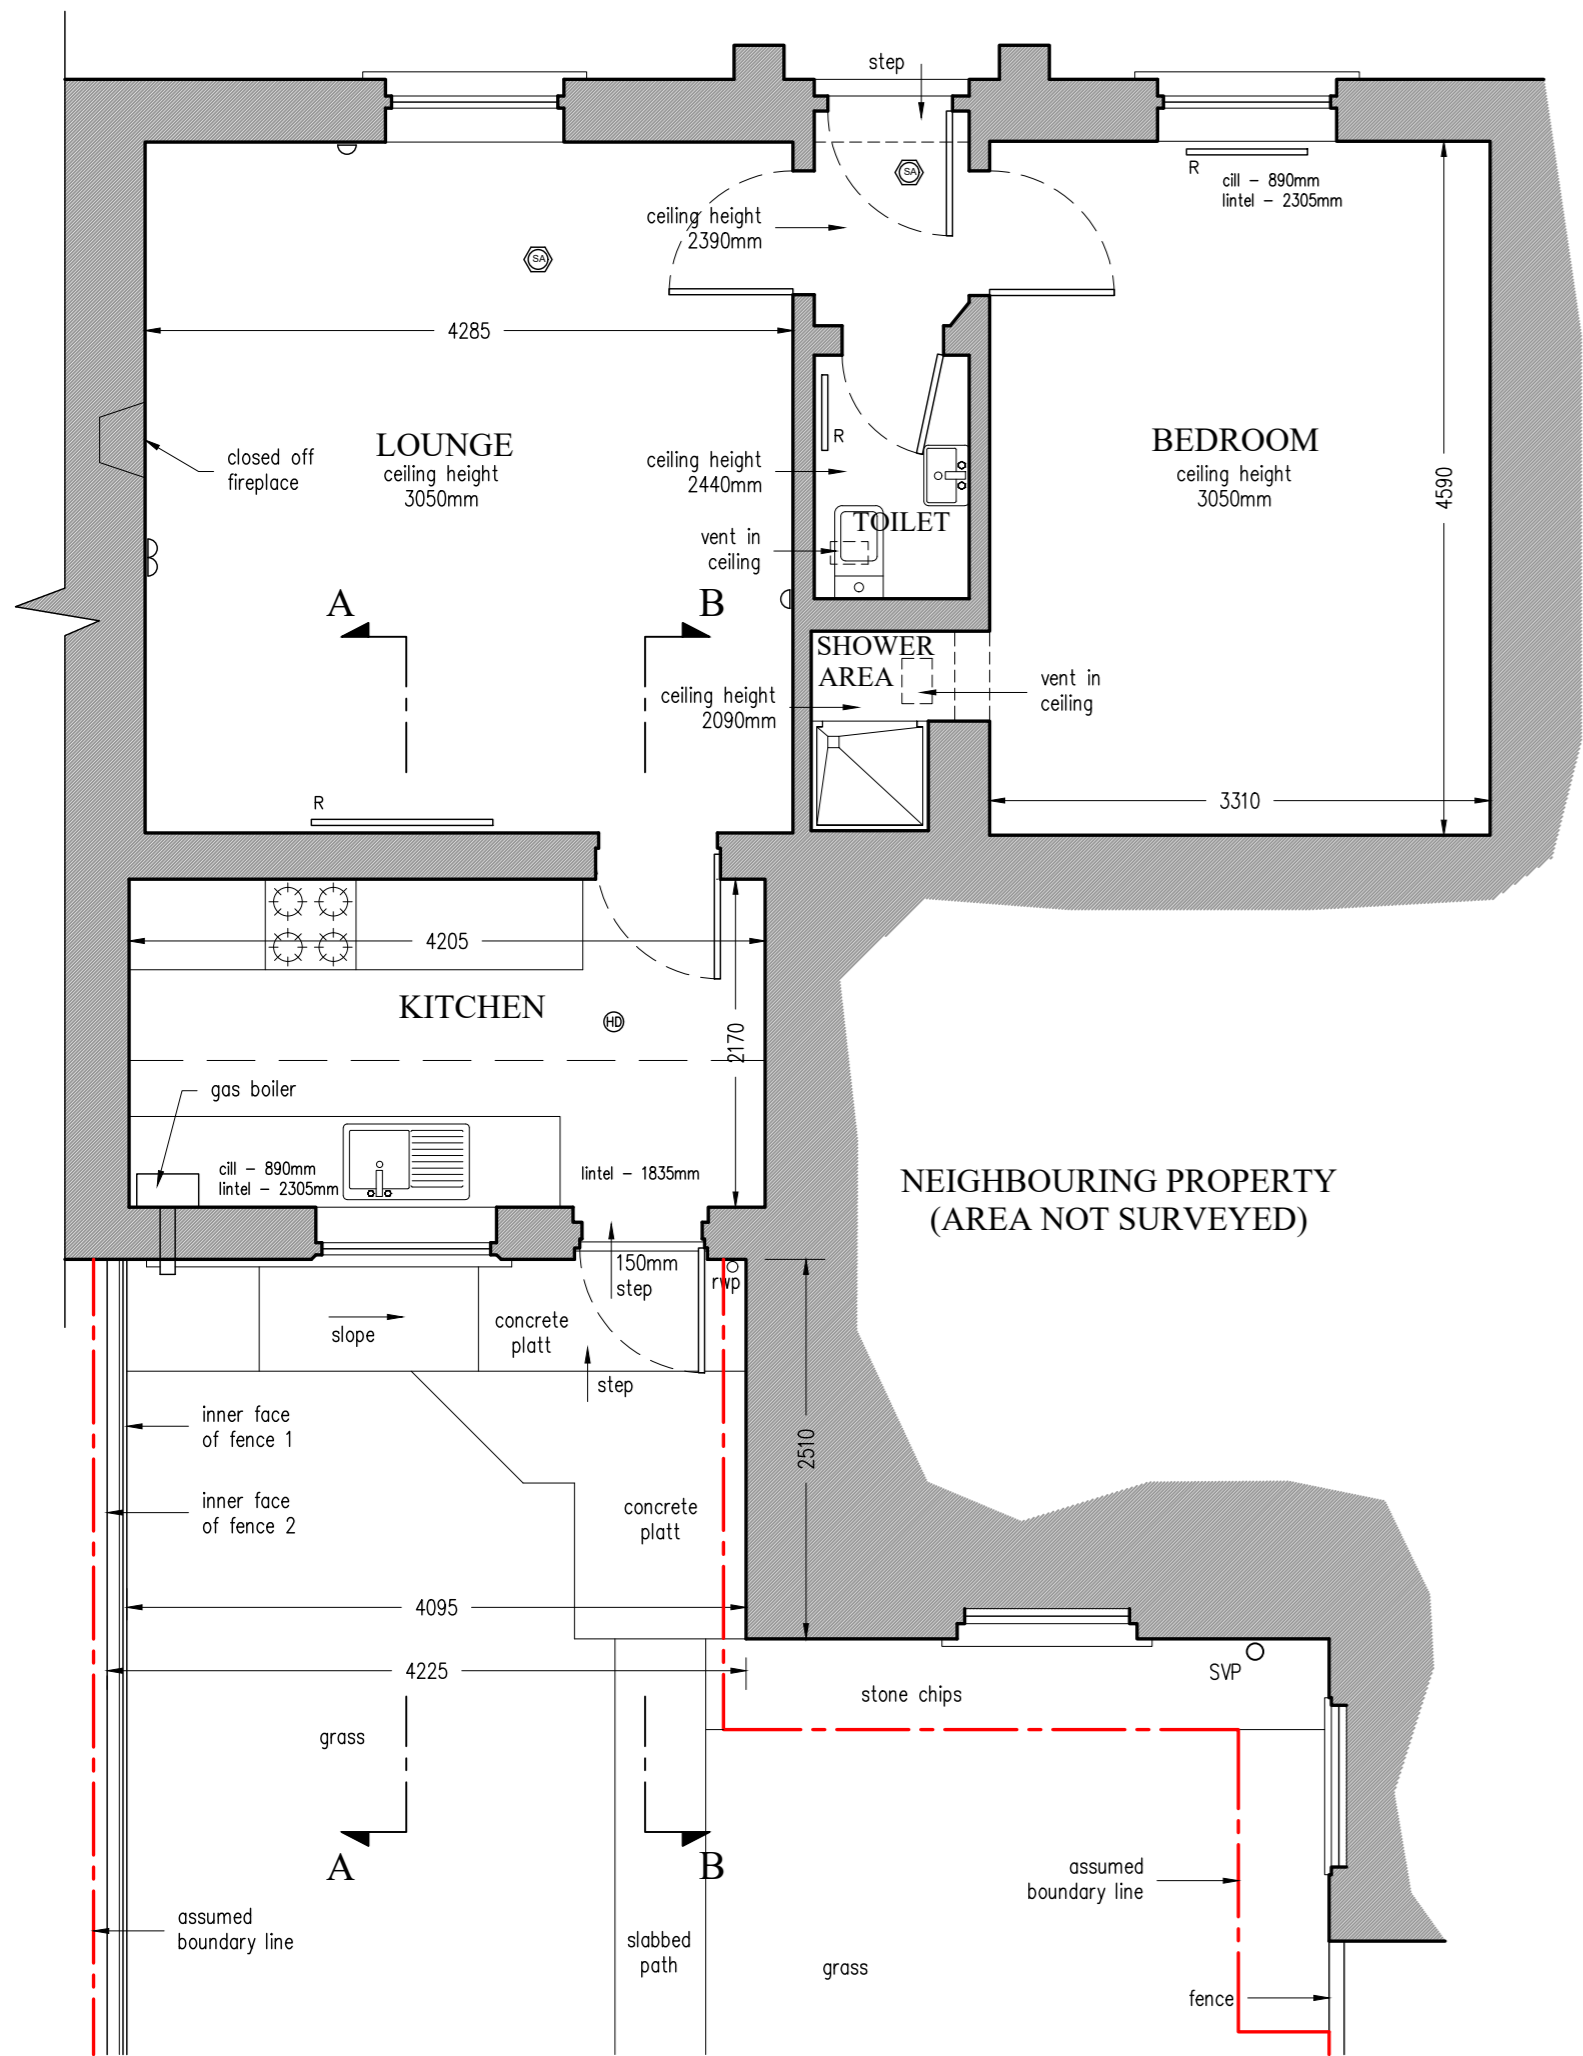

ELECTRICAL LEGEND	
	DOUBLE LOW LEVEL SWITCH SOCKET OUTLET
	LOW LEVEL SOCKET SWITCH SOCKET OUTLET
	FIXED RADIATOR OR HEATING PANEL
	SMOKE ALARM
	HEAT DETECTOR


SECTIONS AS EXISTING 1:50

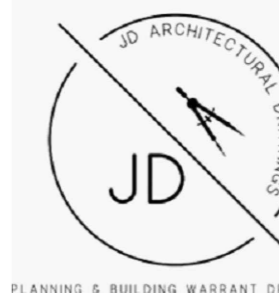


NOTES

DRAWING TO BE READ IN CONJUNCTION WITH SPECIFICATIONS AND ENGINEERS DRAWINGS.
ALL DIMENSIONS ARE IN MILLIMETRES
ALL DIMENSIONS TO BE VERIFIED BY CONTRACTOR ON SITE PRIOR TO FABRICATION OR ERECTION.
ANY DISCREPANCIES ON THIS DRAWING OR BETWEEN DRAWINGS SHOULD BE REPORTED TO THE ARCHITECT AND CLARIFICATION REQUESTED PRIOR TO PROCEEDING WITH WORK.

DO NOT SCALE THIS DRAWING.

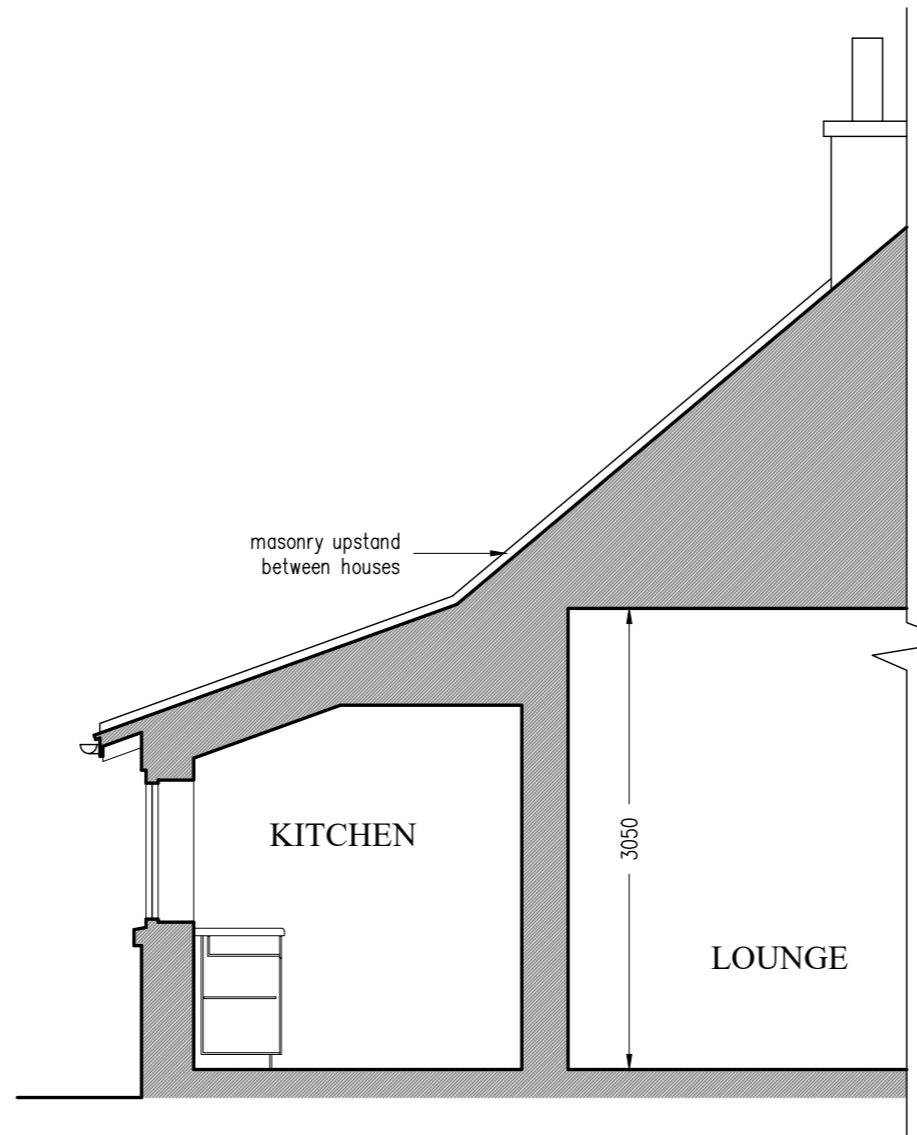


SECTION A-A

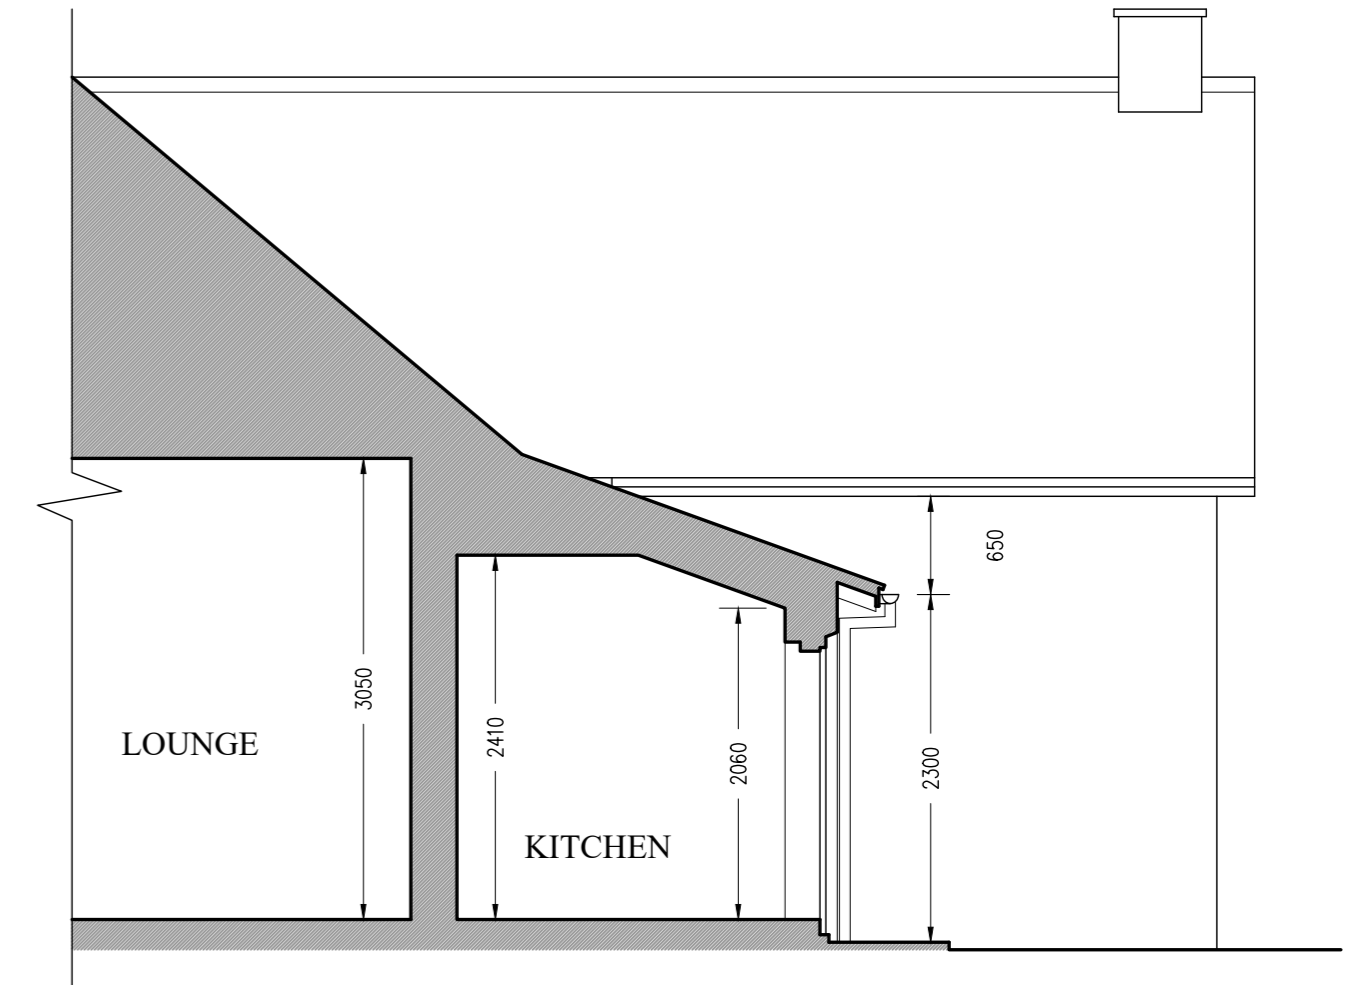

SECTION B-B

SOUTH (REAR) ELEVATION AS EXISTING 1:50

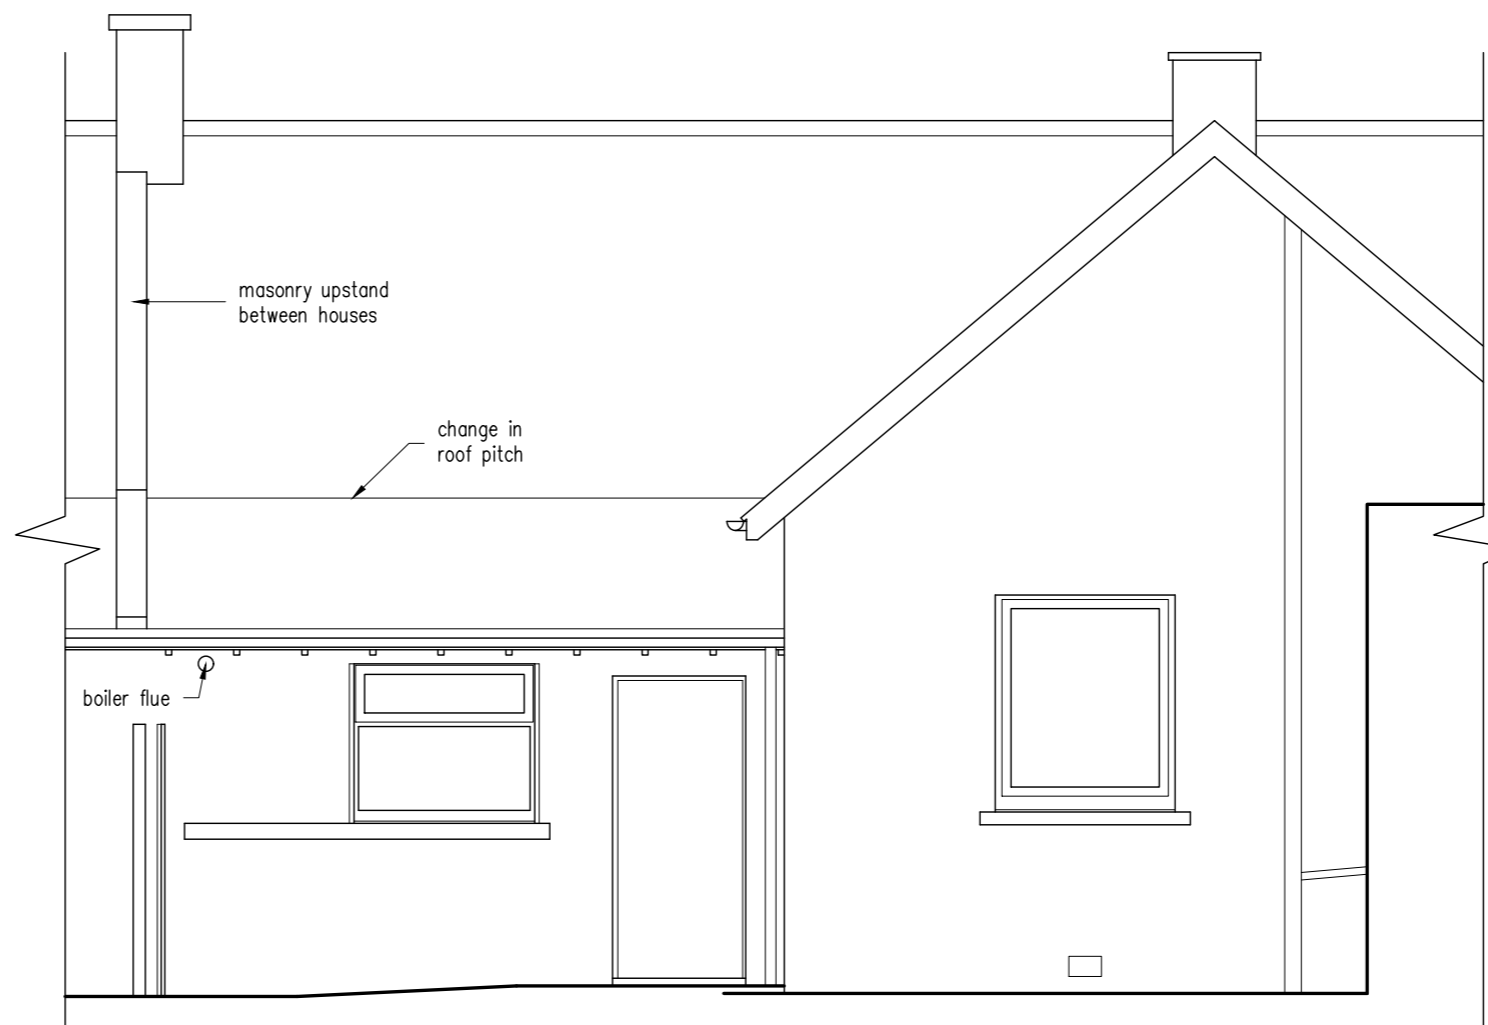

DATE	DESCRIPTION	REVISION

CLIENT
Mrs L. Maitland

PROJECT
Proposed Rear Extension at 3 Fern Cottages, Glasgow, G13 1NH

DRAWING
Floor Plan, Sections & Elevation As Existing

DATE: Apr. 2024 SCALE: 1:50 © A2

DRAWING N. REVISION
PL-02