

**EXISTING PLAN LEGEND:**

**GENERAL:**

Area of Works (excluding Fire Alarm System installation)

 
**DOWNTAKINGS:**

Walls  
Doors

**ARCHITECTURAL ELEMENTS:**

Existing Walls  
Doors

**DOOR LEGEND:**




**DOOR TYPES:**


SD Solid Door  
TP Glazed Top Panel

DO NOT SCALE FROM THIS DRAWING  
GD Lodge accepts responsibility for this document only for the intended use by the commissioning party and not to any other.  
All 3D visualisations are for indicative purposes only.  
This drawing is for information only, is subject to approval of the local authority and should not be used for construction.

Rev	Alterations Made	Dwn	Chk	Date
\	INITIAL ISSUE		MS	AM 19.10.23

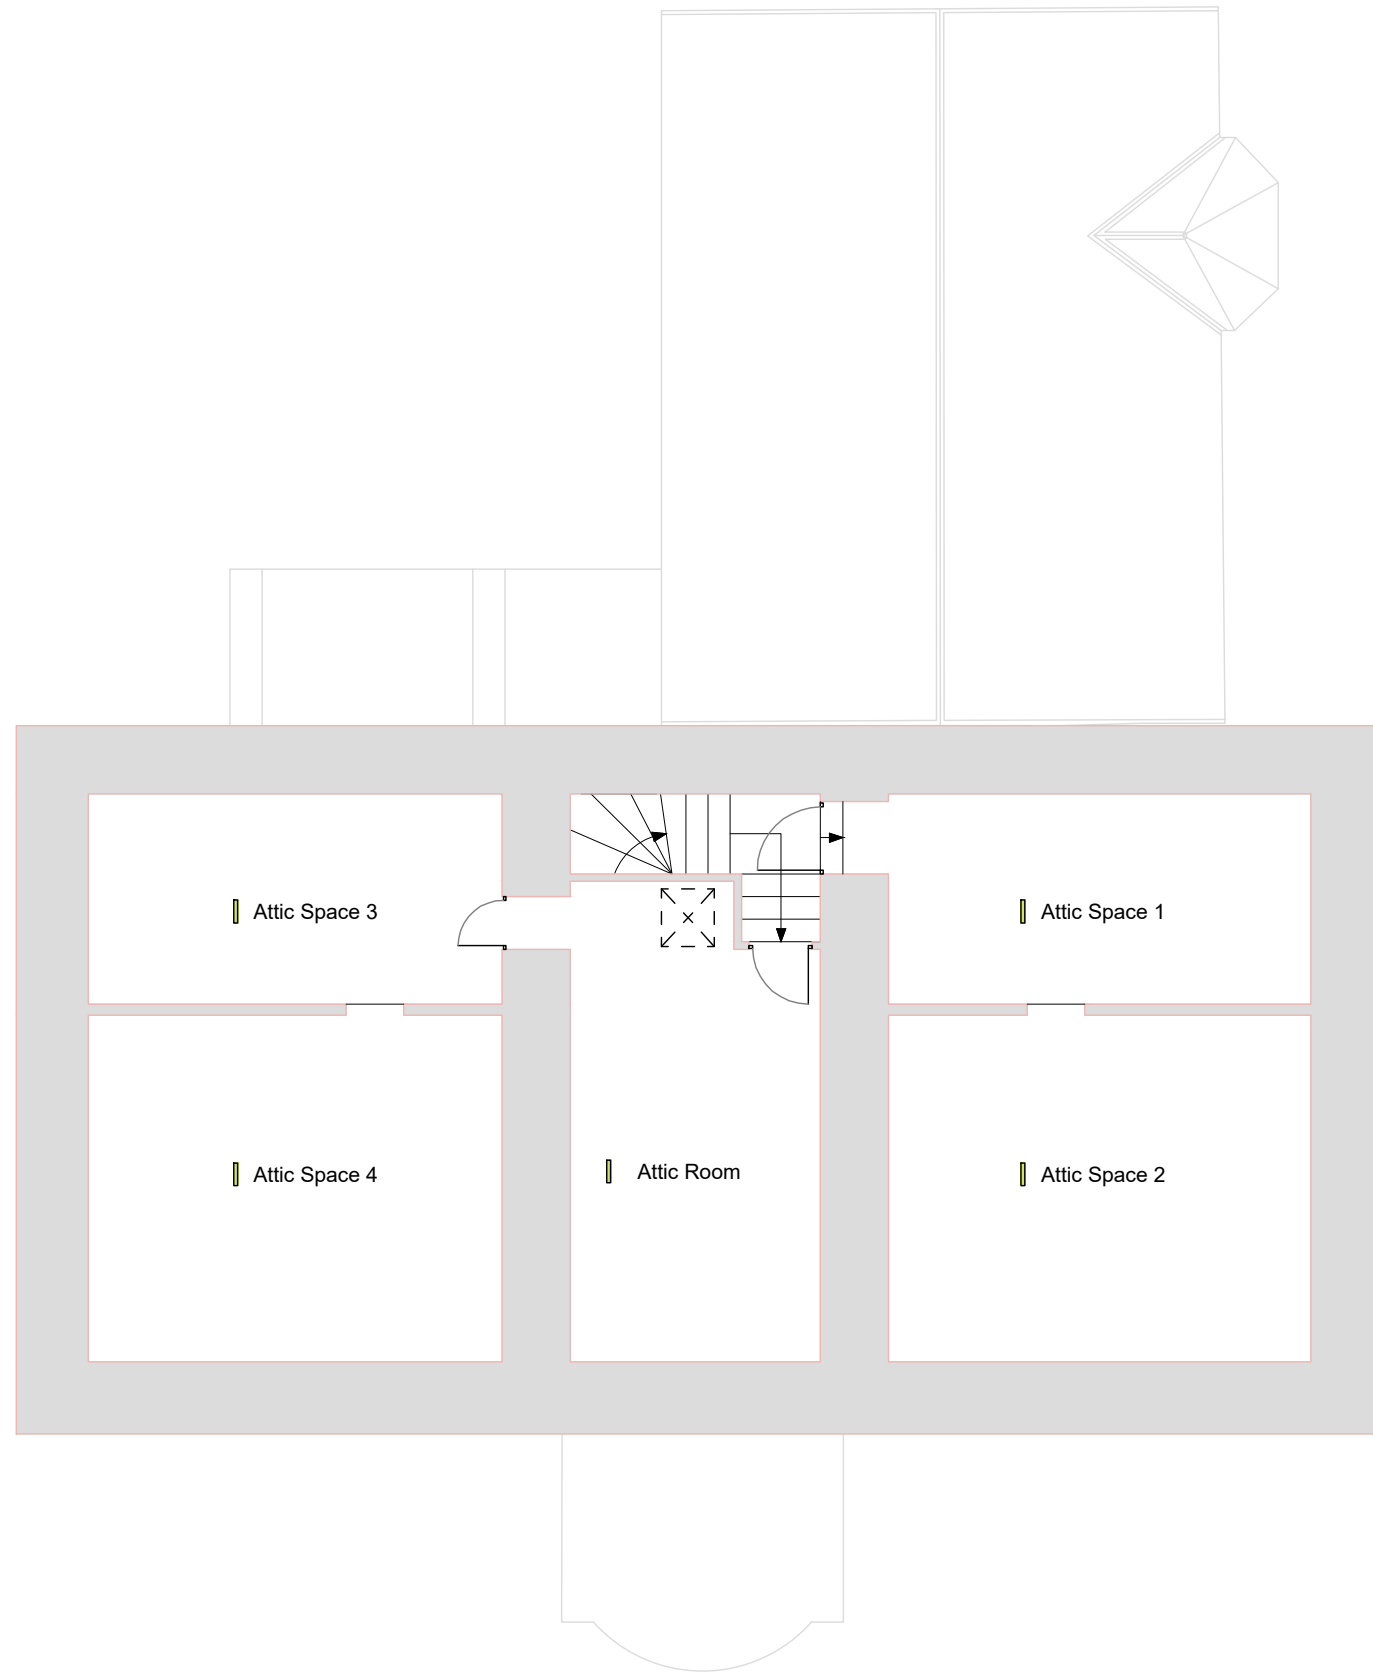

**P04 Existing Attic Floor Plan**

 

**gd lodge architects**

crown house 152 west regent street glasgow G2 2RQ  
www.gdlodge.co.uk projects@gdlodge.co.uk  
0141 332 6804

**Client**  
BANFF CASTLE

**Project**  
Banff Castle

**Drawing**  
Existing Attic Floor Plan

Status Planning	Scale 1:100	Paper Size A3
Job No. 2952	Drawing No. 304	Rev.