

Building (Scotland) Act 2003
 note should be made that the relevant
 person / owner shall be responsible for
 signing and issuing the completion
 certificate application to the verifier.

The relevant person shall also be
 responsible for the building standards CNP
 (Construction Notification Plan)

CONTRACTOR TO VERIFY ALL DIMENSIONS ON SITE
 BEFORE COMMENCING WORK ORDERING MATERIALS.
 ALL ELECTRICAL INSTALLATIONS TO BE TO THE
 LATEST I.E.E. REGULATIONS
 ELECTRICAL LAYOUT AND INSTALLATIONS TO BE IN
 ACCORDANCE WITH B.S. 7671: 2018 (AS AMENDED)

ALL GLAZING TO COMPLY WITH BS 6262

ALL DRAINAGE TO COMPLY WITH CURRENT REGULATIONS
 BSEN 752-3 : 1997 (Am2)
 BSEN 752 - 4 : 2008
 BSEN 1610 :1998
 BSEN 12056 - 3 : 2000


A R Peebles

drawforme@hotmail.com

Mr & Mrs J Louden
 13 Ann Street
 Tillicoultry


Scale 1:50	Date Mar, 24
Drwg No	ArP - 866 - 07

 Architectural Drawing Services
 32 Moss Road, Tillicoultry, FK13 6NS
 Tel : 07780556576



FINISHES SCHEDULE

ROOF - CAMBRIAN SLATE - GREY
 WALLS - DRYDASH RENDER - WHITE
 BASECOURSE - SMOOTH CEMENT - WHITE
 FASCIA / SOFFITS - UPVC - BROWN
 WINDOWS / DOORS - UPVC - BROWN
 RAINWATER GOODS - UPVC - BLACK

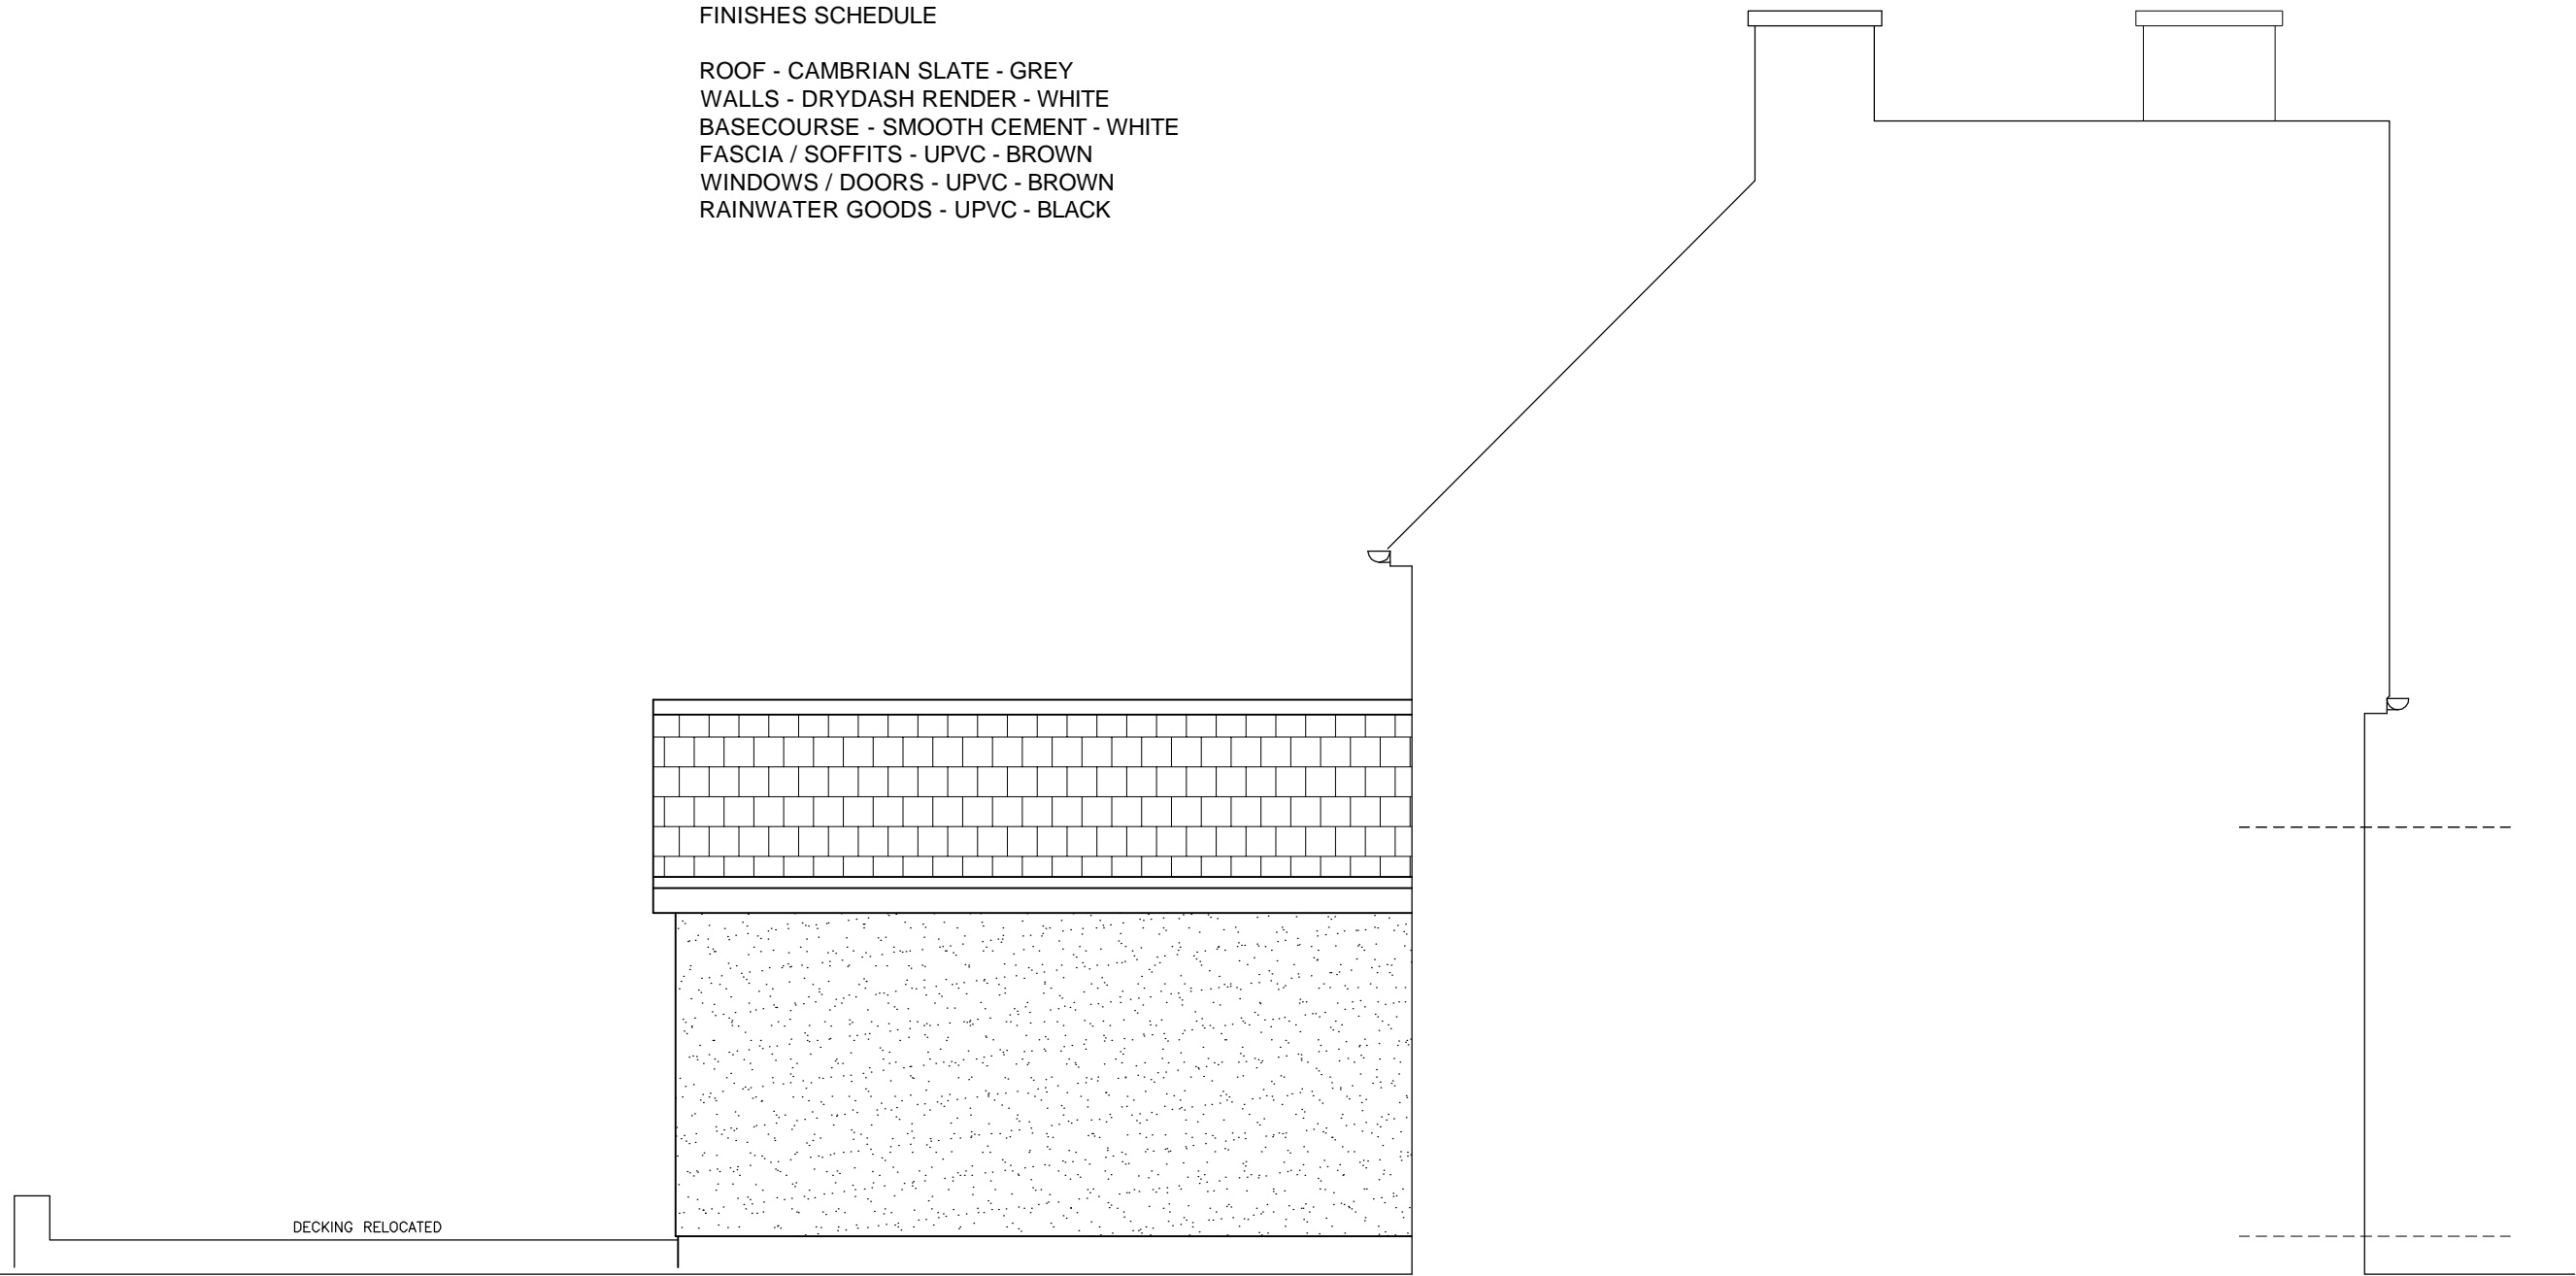

SECTIONAL ELEVATION
 AS PROPOSED

As duly appointed agent these drawings were prepared for the purpose of obtaining planning and building warrant approval, and duties as the duly appointed agent are described in the original letter of appointment