
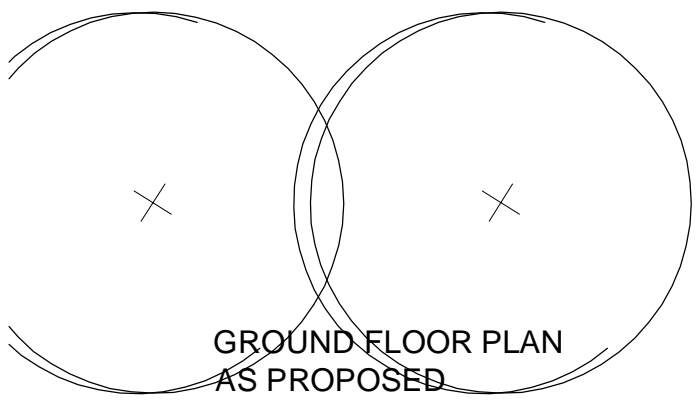
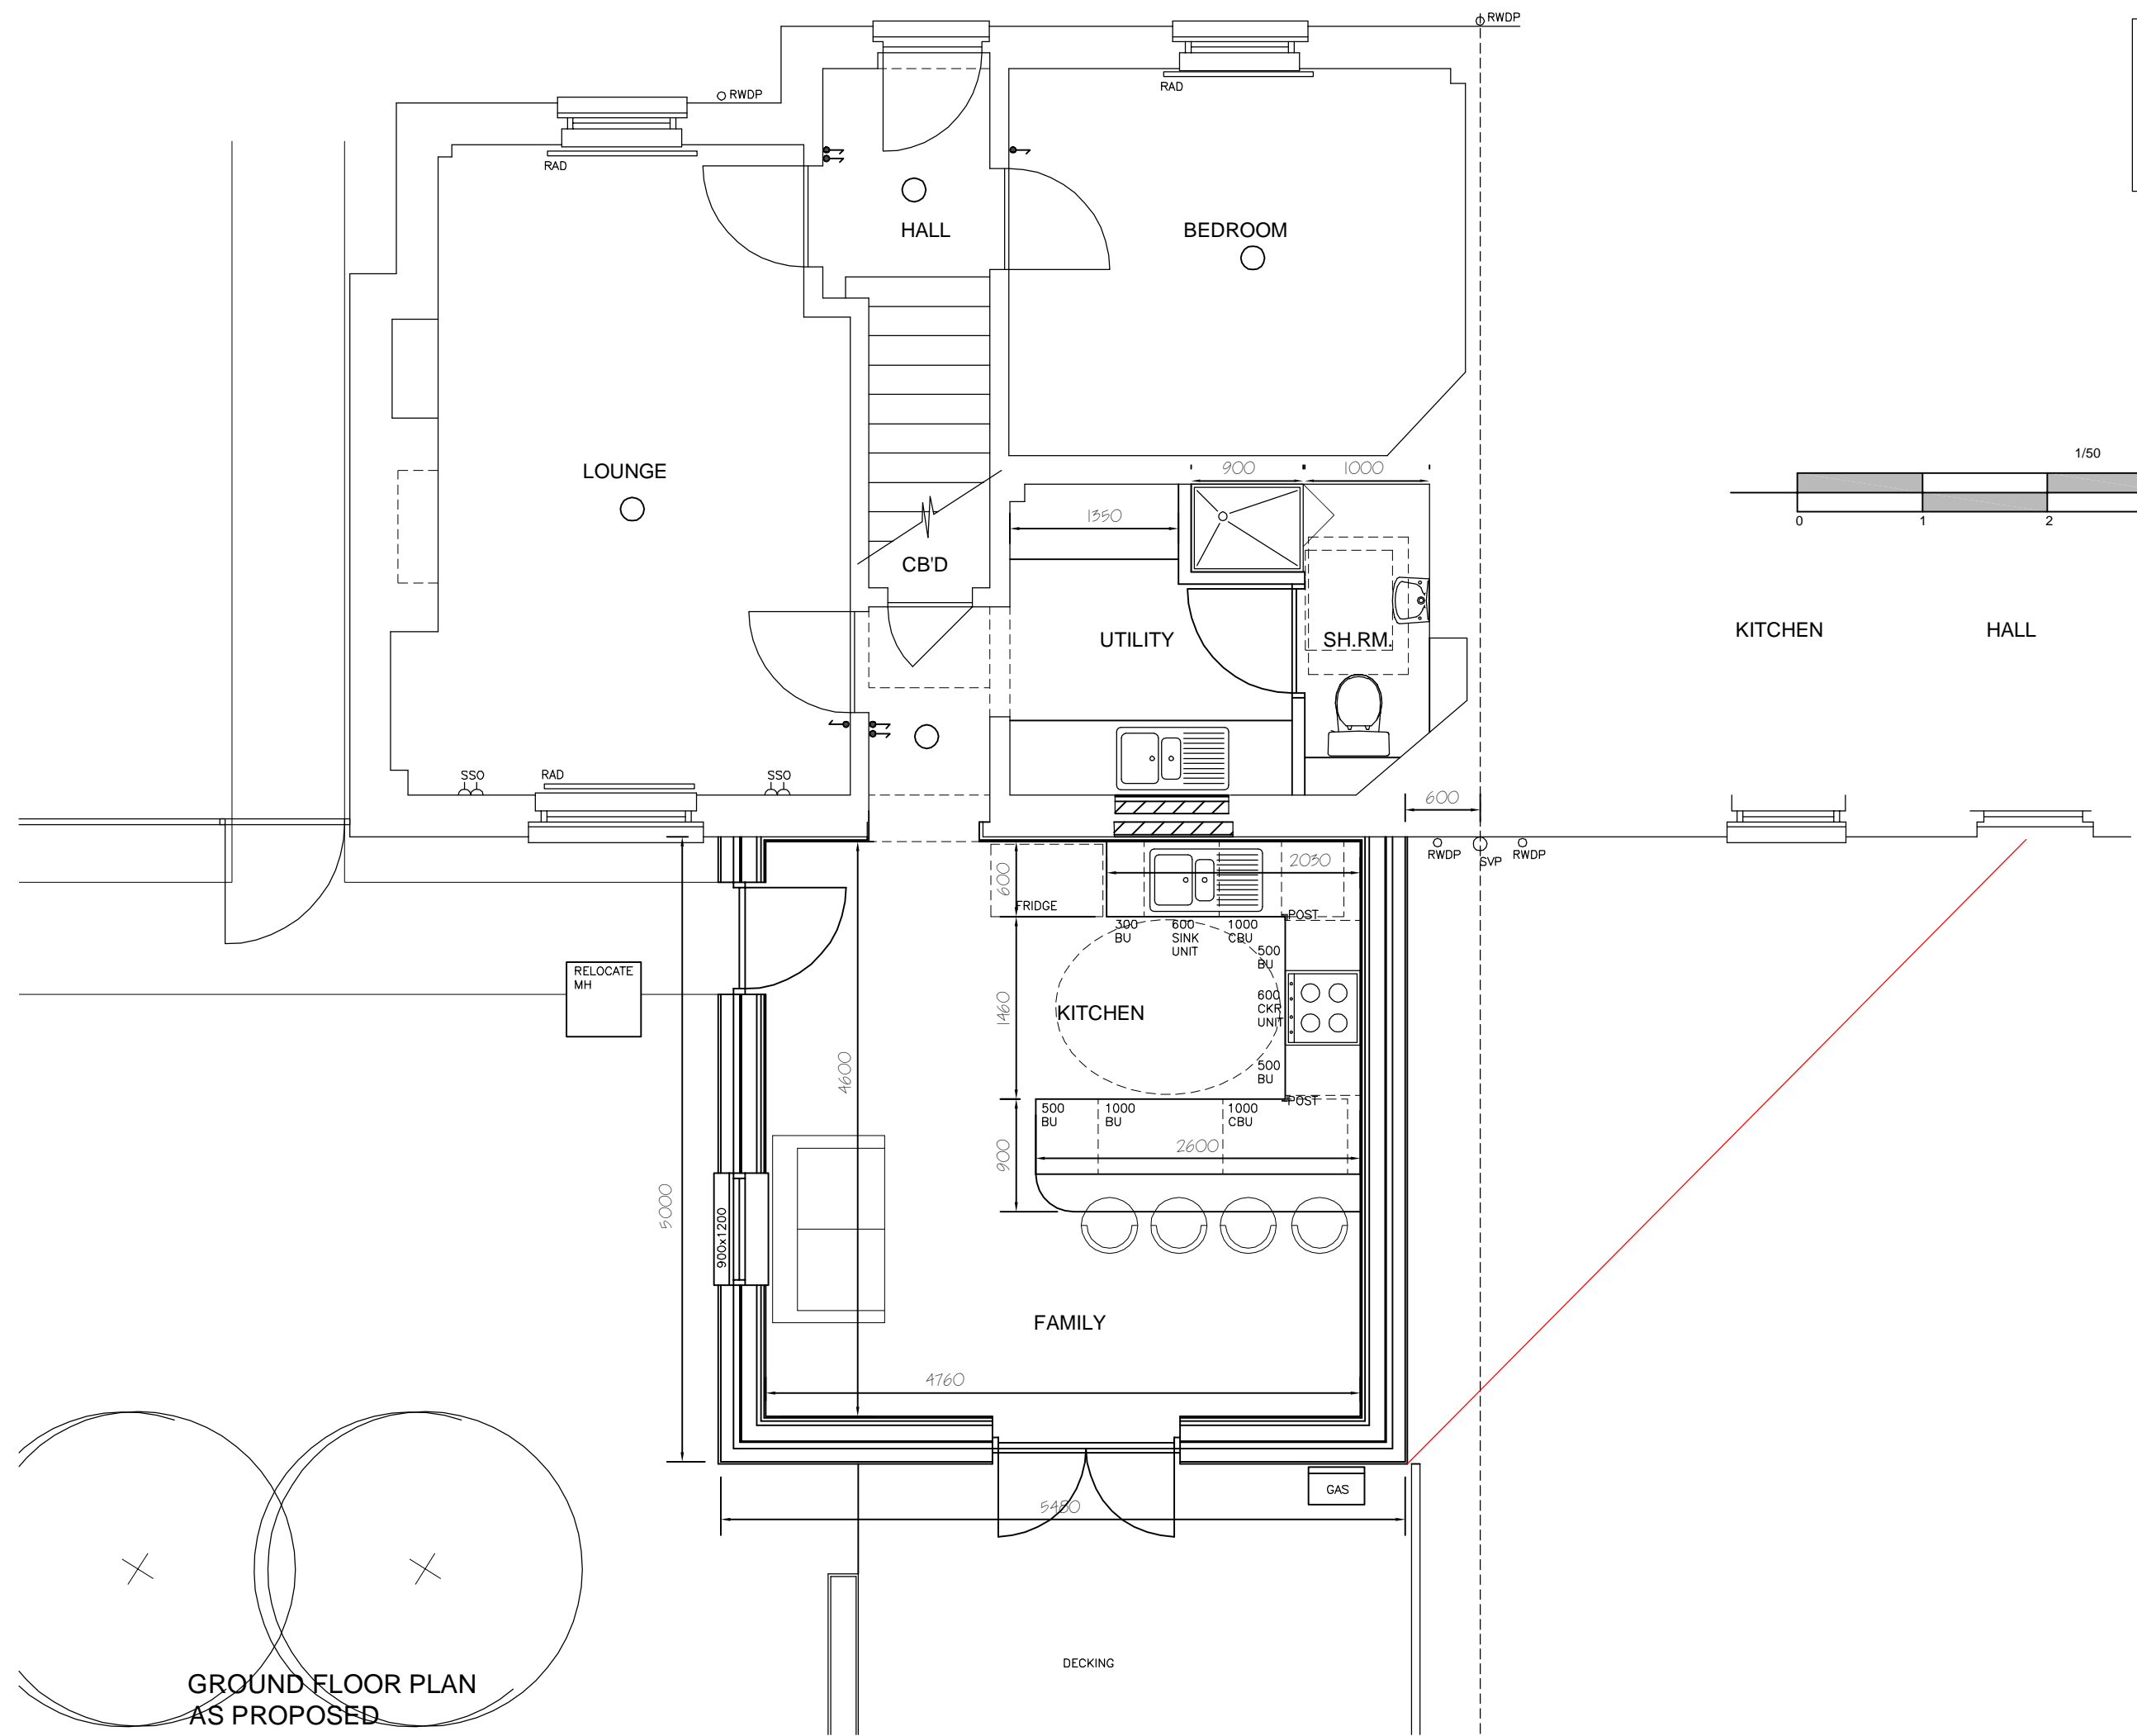


Building (Scotland) Act 2003
 note should be made that the relevant person / owner shall be responsible for signing / issuing the completion certificate application to the verifier.

The relevant person shall also be responsible for the building standards CNP (Construction Notification Plan)

CONTRACTOR TO VERIFY ALL DIMENSIONS ON SITE BEFORE COMMENCING WORK ORDERING MATERIALS.
 ALL ELECTRICAL INSTALLATIONS TO BE TO THE LATEST I.E.E. REGULATIONS
 ELECTRICAL LAYOUT AND INSTALLATIONS TO BE IN ACCORDANCE WITH B.S. 7671: 2018 (AS AMENDED)
 ALL GLAZING TO COMPLY WITH BS 6262
 ALL DRAINAGE TO COMPLY WITH CURRENT REGULATIONS
 BSEN 752-3 : 1997 (Am2)
 BSEN 752 - 4 : 2008
 BSEN 1610 :1998
 BSEN 12056 - 3 : 2000

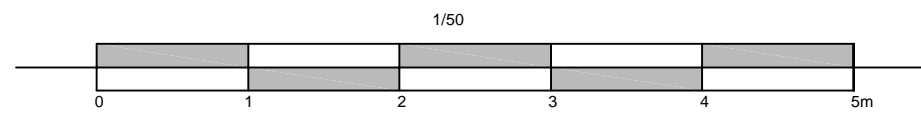

A R
Peebles

drawforme@hotmail.com

Mr & Mrs J Louden
 13 Ann Street
 Tillicoultry

Scale 1:50	Date Mar, 24
Drwg No	ArP - 866 - 02

Architectural Drawing Services
32 Moss Road, Tillicoultry, FK13 6NS
 Tel : 07780556576

As duly appointed agent these drawings were prepared for the purpose of obtaining planning and building warrant approval, and duties as the duly appointed agent are described in the original letter of appointment