
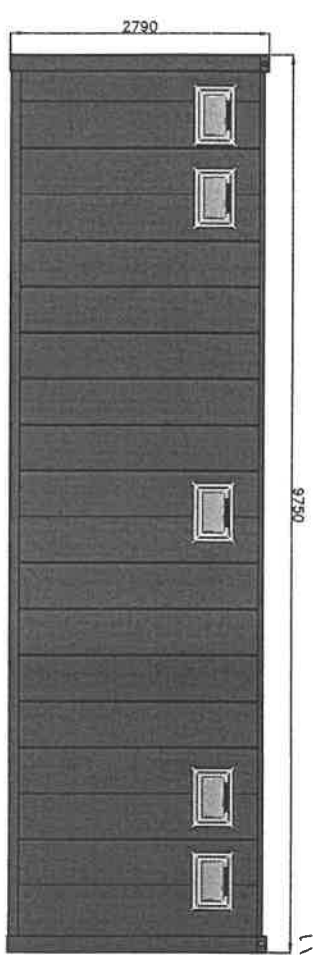


**ELECTRICAL KEY**

- 1. DISTRIBUTION BOARD
- 2. PIR MOTION SENSOR
- 3. LED LIGHTS
- 4. LED BULK HEAD LIGHTS
- 5. FAN HEATER
- 6. DOUBLE SOCKET
- 7. 15L WATER HEATER
- 8. LED EXTERNAL LIGHTS

9. Emergency lighting  
 10. Fire extinguishes  
 11. Fire detectors  
 (Fire alarm system)

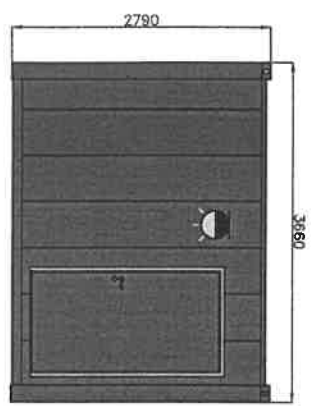

REVISION	DESCRIPTION	ITEM	CHG	DATE

<p><b>Britcab</b>          www.britcabins.com          01759 301725</p>	<p>Britcab Ltd          Moor Lane Industrial Estate          Thelthorpe          York          01759 301725</p>	<p>SCALE 1:75 (A4)</p>	<p>DRAWN TD</p>	<p>DATE 05/03/24</p>
<p>THIS DRAWING IS PROPERTY OF BRITCAB LTD. IT MUST NOT BE COPIED IN WHOLE OR IN PART OR SENT TO A THIRD PARTY WITHOUT WRITTEN CONSENT</p>			<p>DRG. No. 001</p>	<p>Plan Layout</p>