

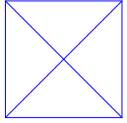

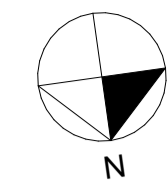


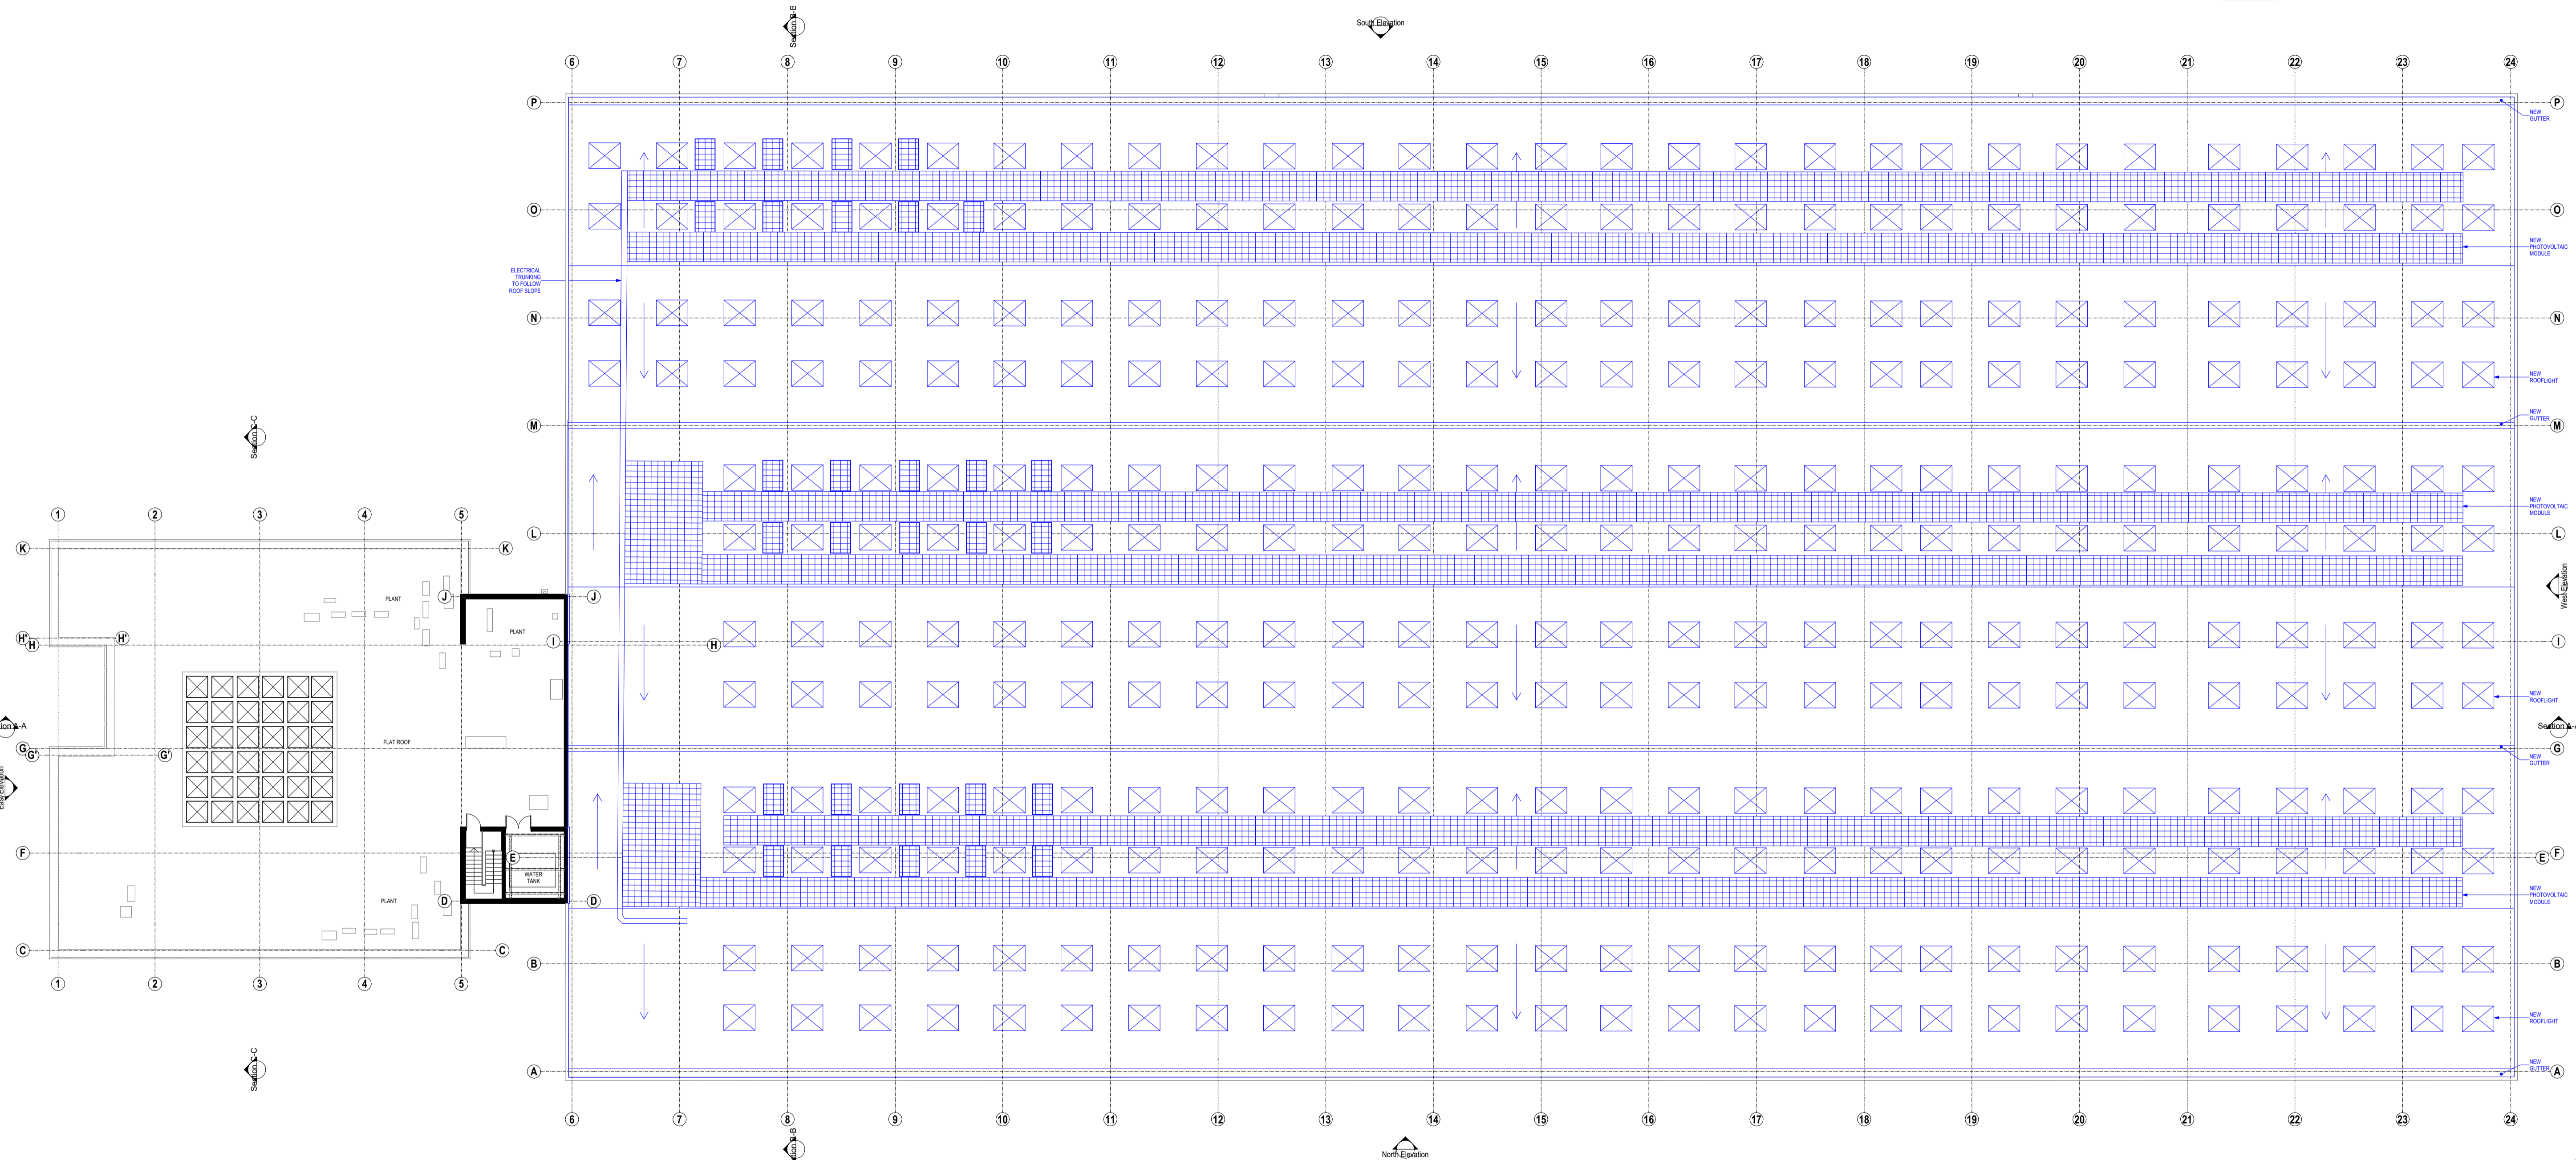
LEGEND

-  EXISTING
-  PROPOSED
-  NEW ROOFLIGHT
-  NEW PHOTOVOLTAIC MODULE



Notes:

- 1 ALL DIMENSIONS TO BE CHECKED ON SITE BEFORE COMMENCING WORK OR MANUFACTURE OF COMPONENTS. ANY DISCREPANCY OR OMISSION TO BE REPORTED TO THE ARCHITECT IMMEDIATELY.
- 2 © COPYRIGHT ROBSON WARREN ARCHITECTS LIMITED. ALL RIGHTS RESERVED.



Roof
AS PROPOSED WORKING

B 26-04-2024 PHOTOVOLTAIC MODULES UPDATED
A 13-06-2023 TENDER ISSUE
Revised:

ROBSON WARREN
Architects
8 Northfields Prospect
Putney Bridge Road
London SW18 1PE
Telephone: 020-8871 9349
E-mail: architects@robsonwarren.co.uk

Project:
ROOF REFURBISHMENT
F.P.HERTING WAREHOUSE
25 Armstrong Way
Southall UB2 4SD
FOR: F.P.HERTING & SON PLC
Drawing:
Roof Plan
AS PROPOSED WORKING

Drawn by: AG Date: 26/04/2024
Checked: PW Scale: 1:200 @ A1
Job No: 2481 Scale: 1:500 @ A3
Dwg No. / Revision: V1/203/B

