



Proposed Ground Floor Plan (scale 1:100)



- Electrical Legend**
Refer to separate specification for fixing heights
- ⊙ ceiling-mounted heat detector
 - ⊗ ceiling-mounted smoke detector/alarm
 - ⊕ ceiling-mounted CO detector/alarm
 - ceiling-mounted light fitting
 - recessed ceiling downlight
 - ⬆ wall-mounted light fitting
 - ⊞ ceiling-mounted extract fan
 - ⊞ through-wall extract fan
 - ⊞ board for consumer unit & electric meter
 - ⊞ appliance control unit
 - ⬆ ball push
 - ⬆ door chime
 - ⚡ low-level double socket
 - ⚡ high-level double socket
 - ⚡ low-level single socket
 - ⚡ high-level single socket
 - BT ⚡ low-level telecom socket
 - BT ⚡ high-level telecom socket
 - low-level flex outlet
 - high-level flex outlet
 - TV ⚡ low-level TV aerial socket
 - TV ⚡ high-level TV aerial socket
 - ⚡ single-gang switch
 - ⚡ double-gang switch
 - ⚡ three-gang switch
 - ⬆ wall-mounted thermostat
 - ⬆ wall-mounted alarm control unit

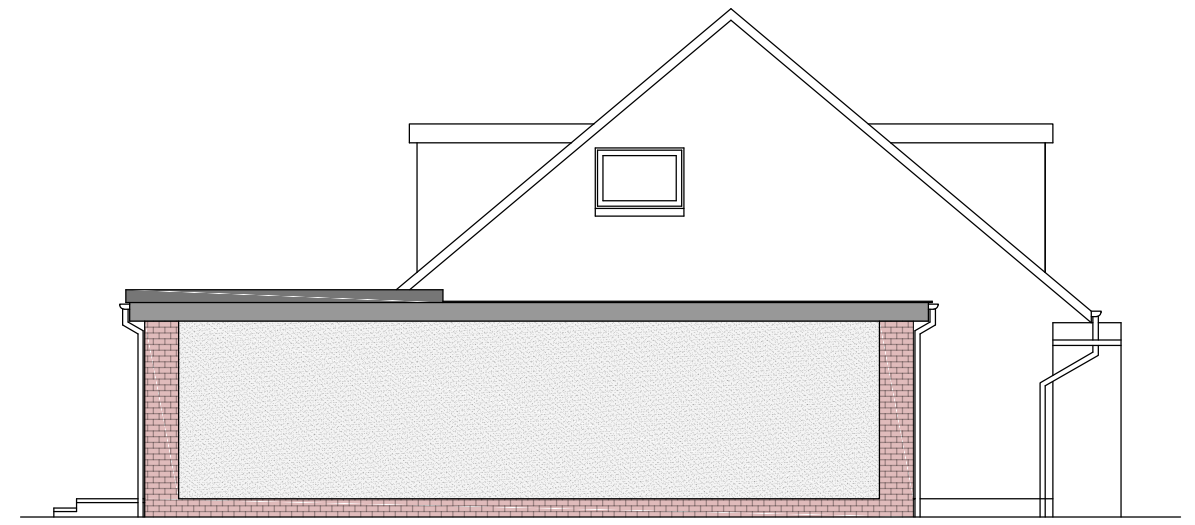

Proposed Side Elevations (scale 1:100)

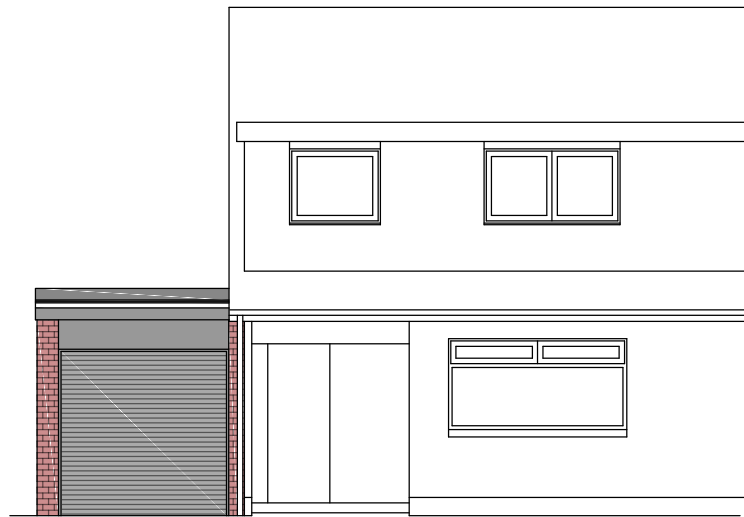

Proposed Front Elevations (scale 1:100)



Proposed Rear Elevations (scale 1:100)



Copyright in this design is reserved to Mcllelland Architectural Design. These drawings are for solely Planning or Warrant purposes only. All dimensions should be checked by Contractor before commencing work.

PROJECT / CLIENT:

Mr and Mrs Thomson
212 Springfield Road
Linlithgow
EH49 7LF

DRAWING:

Proposed Floorplans and Elevations

Drawn by:	Checked by:	Date:	Scales:
mm	mm	12/03/24	1:100

Site Code:	Job Code:	Drawing No.:	Revision:
99	00	002	-



3 Haig Place
Windygates
KY8 5EE

OFFICE: 01333 302585
MOB: 07920 770177