


IMPORTANT NOTE
 THIS PLAN HAS BEEN EXTRACTED FROM CLIENT SUPPLIED DRAWINGS AND HENCE IS SUBJECT TO A DETAILED SITE SURVEY.

DO NOT SCALE DRAWING.
 CONTRACTOR TO CHECK AND CONFIRM ALL DIMENSIONS ON SITE PRIOR TO FABRICATION AND REPORT ANY DISCREPANCIES TO THE DESIGNER.

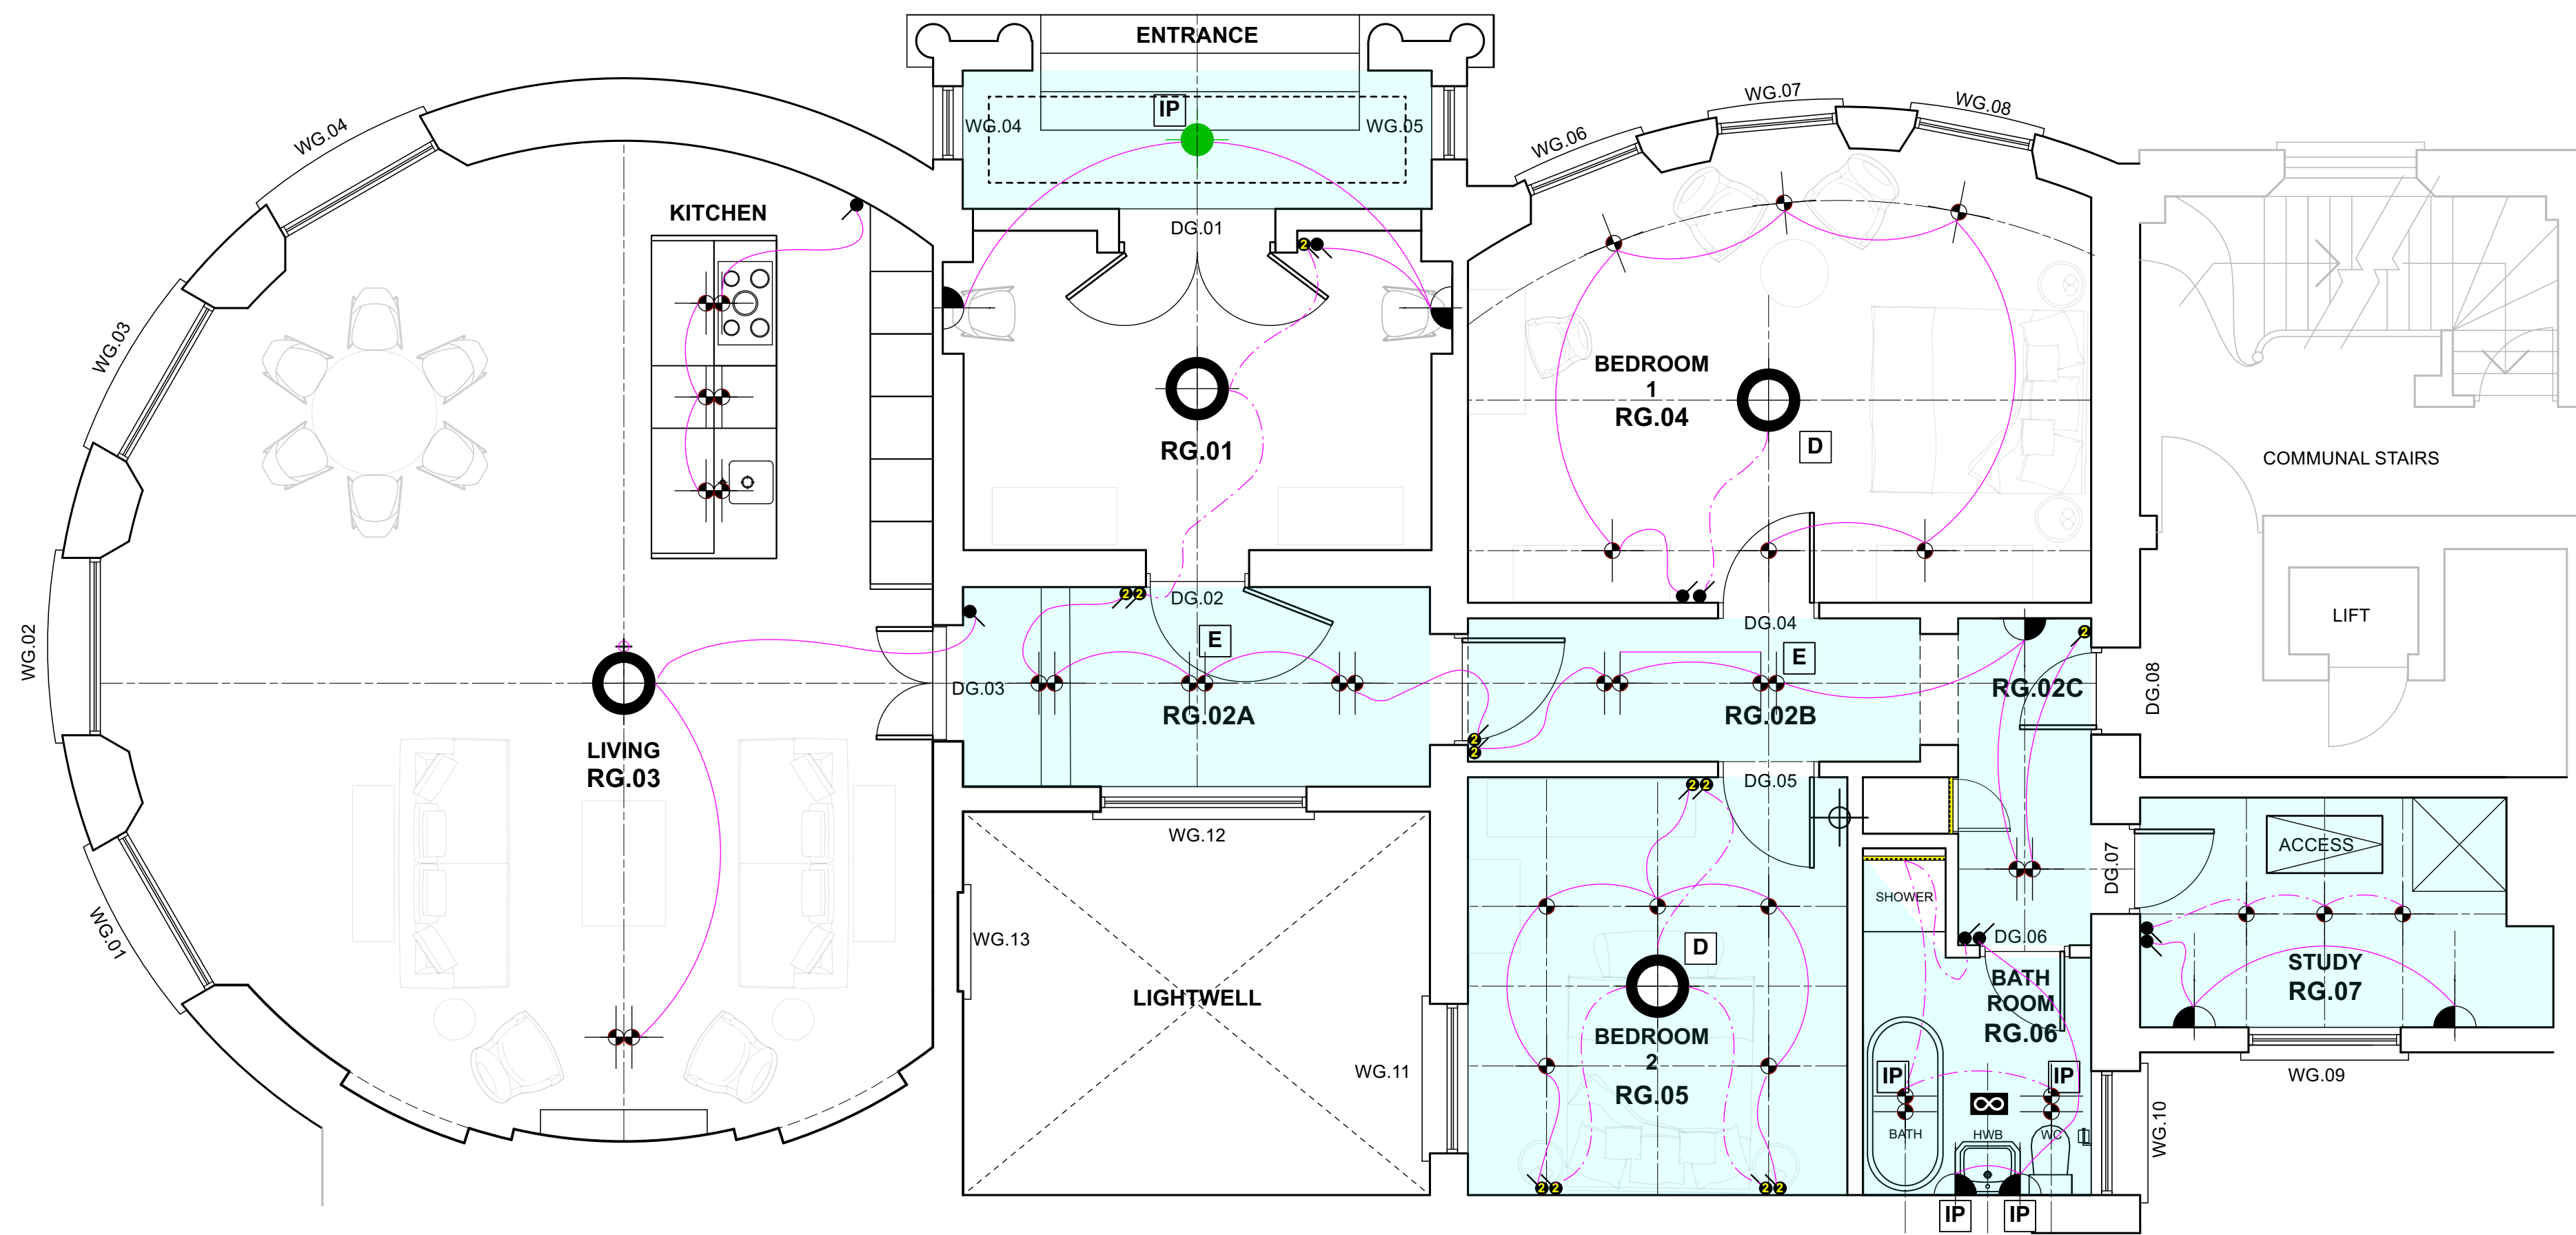

PROPOSED RCP GROUND FLOOR PLAN

LEGEND - SMALL POWER

- 5amp SOCKET FITTED AT SKIRTING LEVEL. SOCKETS TO BE RUN AS A LIGHTING MAIN. ALL SOCKETS IN DARK BRONZE.
- 13amp TWIN GANG SWITCHED SOCKET OUTLET AT SKIRTING LEVEL. ALL SOCKETS IN DARK BRONZE.
- 13amp TWIN GANG SWITCHED SOCKET OUTLET. ALL SOCKETS ABOVE WORKTOP LEVEL. ALL SOCKETS IN DARK BRONZE.
- 13amp TWIN GANG SWITCHED SOCKET OUTLET CONCEALED WITHIN JOINERY ITEM - ALL SOCKETS IN WHITE.
- 5amp & 13amp TWIN GANG SOCKET OUTLET WITHIN FLOOR BOX, ALL SOCKETS IN DARK BRONZE.
- POLISHED CHROME SHAVER POINT
- NEW HEAT DETECTORS
- NEW SMOKE DETECTORS
- DIGITAL TELEVISION POINT, EXACT POSITION TO BE AGREED WITH DESIGNER PRIOR TO INSTALLATION. ALLOW FOR WIRING ACCORDINGLY.
- PROVIDE MECHANICAL EXTRACTION VENTILATION SYSTEM TO EACH AREA AND INSTALLED IN ACCORDANCE WITH THE CURRENT RELEVANT BUILDING REGULATIONS

LEGEND - LIGHTING

- NEW SUSPENDED IP RATED EXTERIOR LANTERN FITTING - CONTRACTOR TO VERIFY WIRING AND RATING IS FIT FOR PURPOSE.
- NEW SUSPENDED IP RATED INTERIOR PLAFONNIER FITTING - CONTRACTOR TO VERIFY WIRING AND RATING IS FIT FOR PURPOSE.
- FLOOR RECESSED LED FIXED SPOTLIGHT. LAMP : NARROW BEAM, WARM WHITE. COL : DARK BRONZE
- CLIENT SUPPLIED WALL MOUNTED MAINS FITTING. CONTRACTOR TO PROVIDE POWER REQUIREMENT. FIXING HEIGHT - TBC
- CEILING RECESSED LED ADJUSTABLE GIMBAL SPOTLIGHT. LAMP : NARROW BEAM, WARM WHITE. COL:WHITE
- CLIENT SUPPLIED MAINS VOLTAGE SUSPENDED CHANDELIER FITTING. CONTRACTOR TO PROVIDE POWER REQUIREMENT AND SECURE FIXINGS.
- CLIENT SUPPLIED 5 AMP VOLTAGE NON FIXED TABLE / FLOOR LAMP LIGHT FITTING. CONTRACTOR TO PROVIDE POWER REQUIREMENT - REFER TO SMALL POWER DRAWING.

LED STRIP - WARM WHITE

CIRCUIT RUNS

LIGHT SWITCH

TWO WAY LIGHT SWITCH

5 AMP LIGHT SWITCH

DIMMER FACILITY

IP RATED FITTING


INTEGRATED EMERGENCY PACK

LEGEND - CEILING

- EXISTING CEILING- ALLOW TO RETAIN EXISTING CEILING MAKING GOOD AS REQUIRED. DECORATIONS TO SPEC.
- NEW SUSPENDED CEILING- ALL AREAS DENOTED THUS TO BE FITTED WITH NEW HALF HOUR FIRE RESISTANT PLASTERBOARD SUSPENDED CEILING. HEIGHT TO BE ESTABLISHED ON SITE.

LEGEND - HEATING

- VERTICAL FLAT PANEL WALL MOUNTED ELECTRIC RADIATOR - TO BE DECORATED TO MATCH WALLS. SIZE TO BE AGREED
- STRAIGHT FRONTED CHROMIUM PLATED TOWEL RADIATOR. SIZE TO BE AGREED
- ELECTRIC UNDERFLOOR HEATING

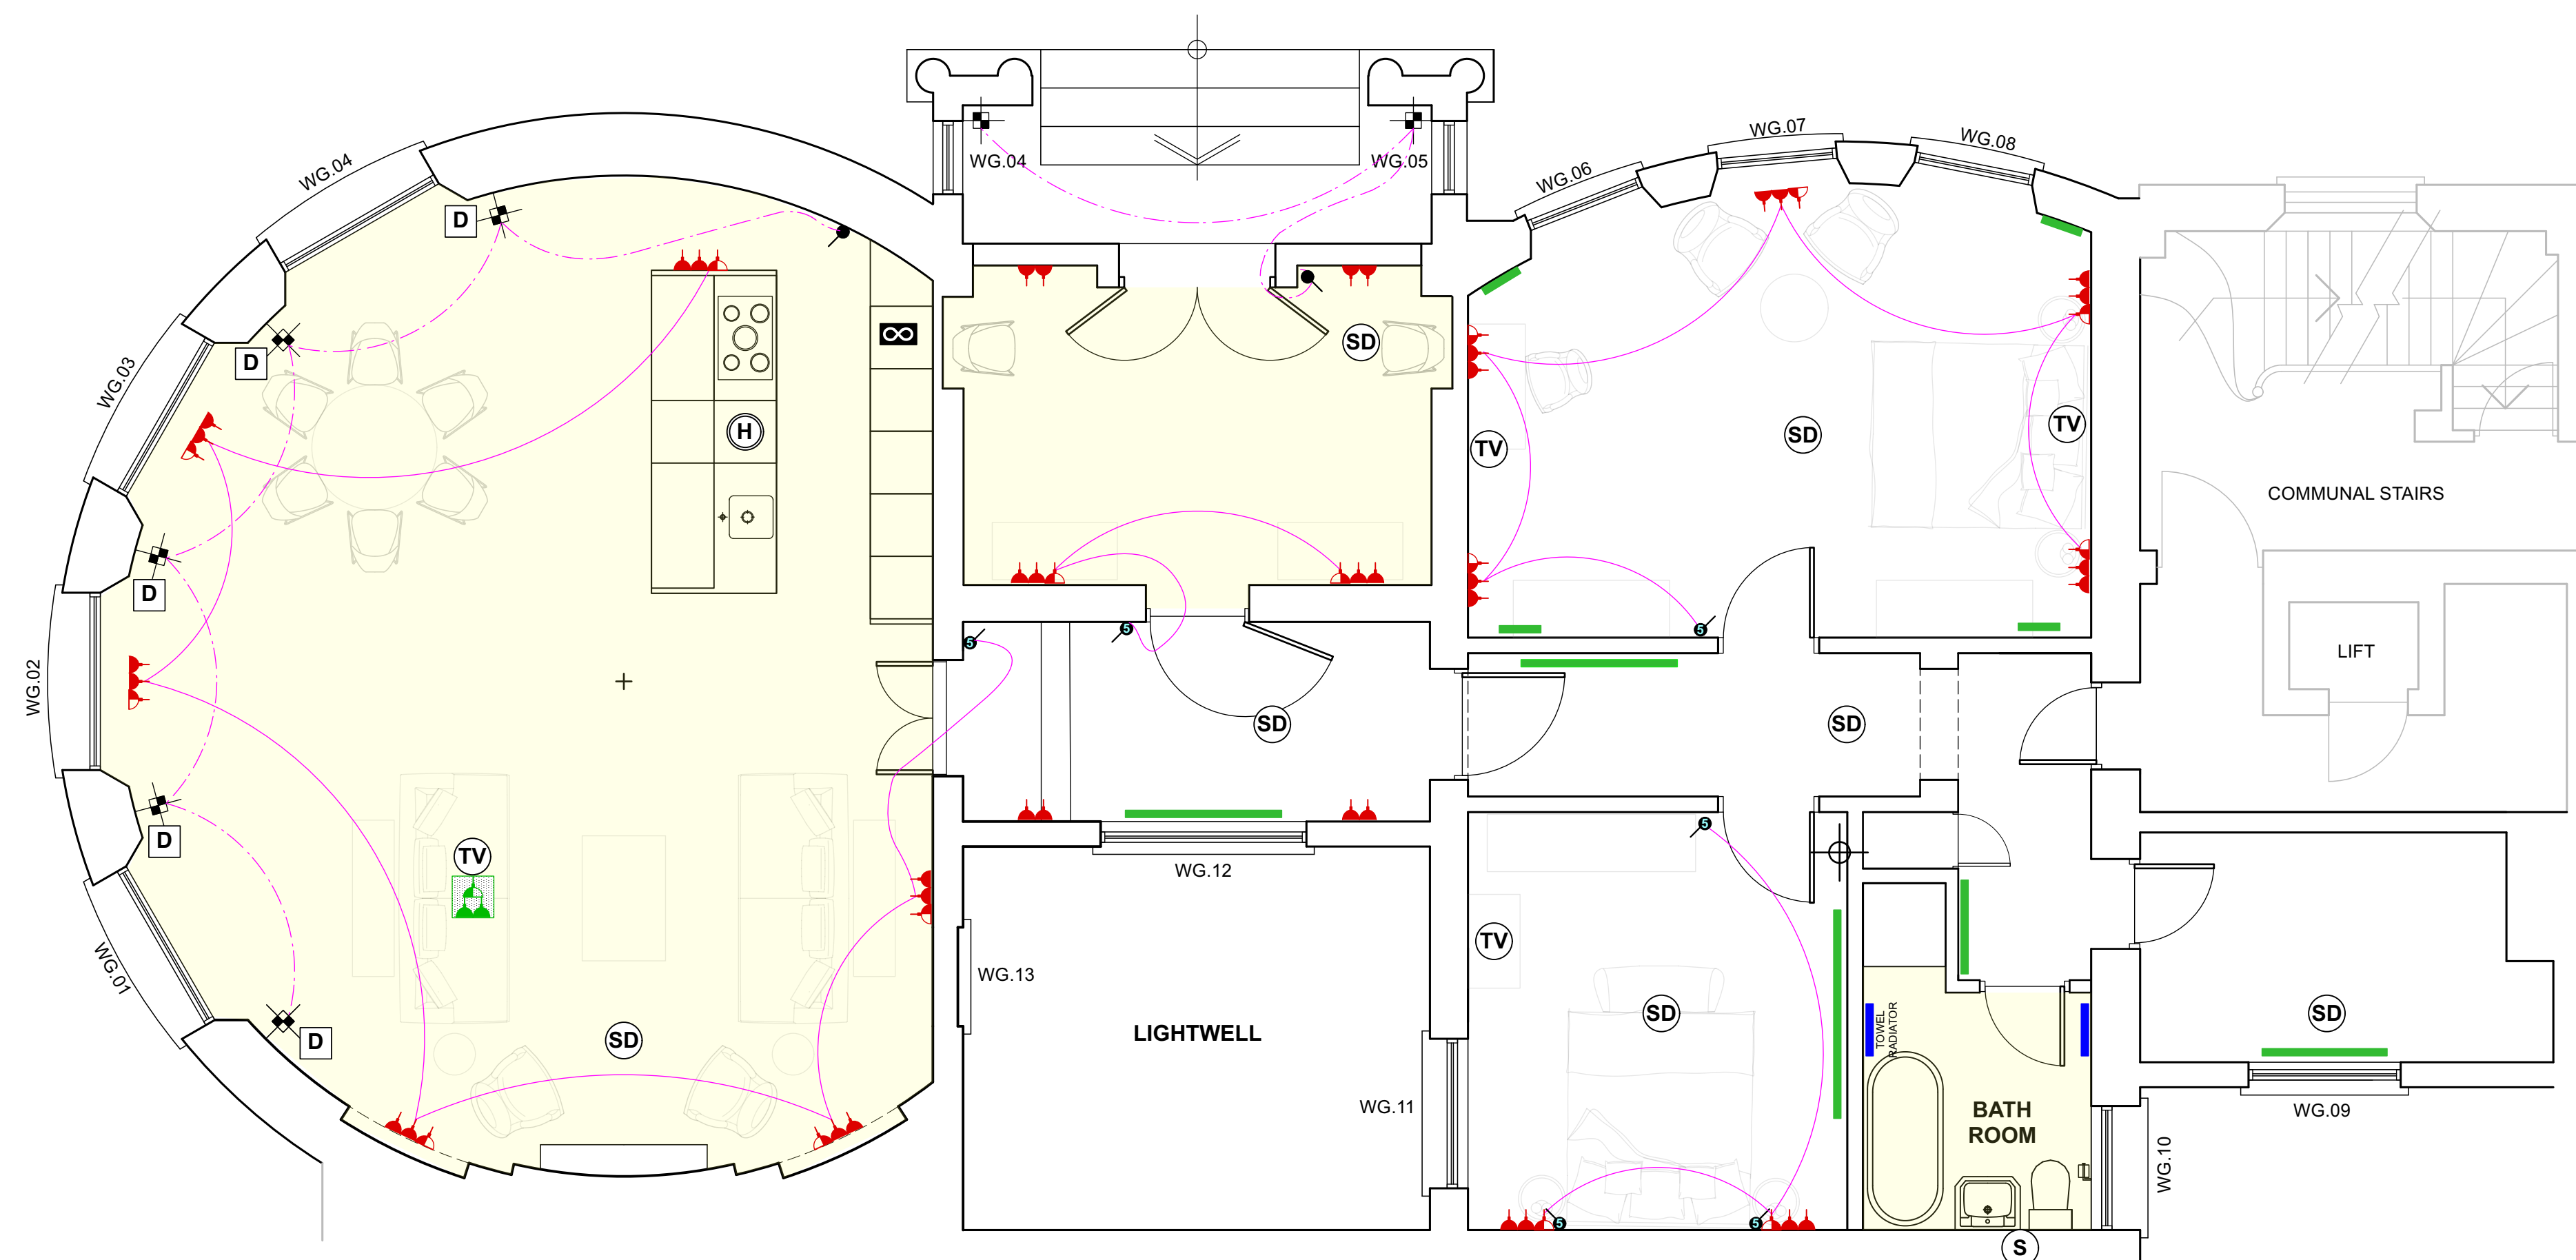

PROPOSED GROUND FLOOR LOW LEVEL POWER PLAN

REV. DATE AMENDMENT

CLIENT

DELANEY & d'ALMADA

PROJECT
FLAT 2 - COURT ROYAL MANSIONS
 1 EASTERN TERRACE, BRIGHTON BN2 1DJ

TITLE
PROPOSED RCP HEATING & SMALL POWER ARRANGEMENT

DATE SCALE
 JANUARY 2024 AS SHOWN
 DRAWN DRAWING NUMBER
 DdA 2CRM - 02

DAVID d'ALMADA LIMITED
 10 ADDISON AVENUE, LONDON W11 4QR
 T 020 7602 4343 F 020 7602 7625

THIS DRAWING IS COPYRIGHT AND NO PORTION SHOULD BE USED WITHOUT CONSENT. NO DIMENSIONS ARE TO BE SCALED OFF THIS DRAWING. ALL DIMENSIONS ARE TO BE VERIFIED ON SITE.