




Communal Heating Notes
 This drawing shall be read in conjunction with all other drawings and specifications

For Notes, Details refer to the following drawings:
 6432-M-Z-M-000-50-900
 6432-M-Z-M-000-50-901

For Communal Heating Schematics refer to the following drawings:
 6432-M-A-M-700-56-700
 6432-M-A-M-700-56-701
 6432-M-BC-M-700-56-702
 6432-M-DE-M-700-56-703
 6432-M-FG-M-700-56-704

For Communal Heating Equipment Schedules refer to the following:
 6432-M-A-ZZ-600-07-130

For Communal Heating Plantroom & Roof Layout refer to drg:
 6432-M-A-01-100-56-100
 6432-M-A-16-100-56-100

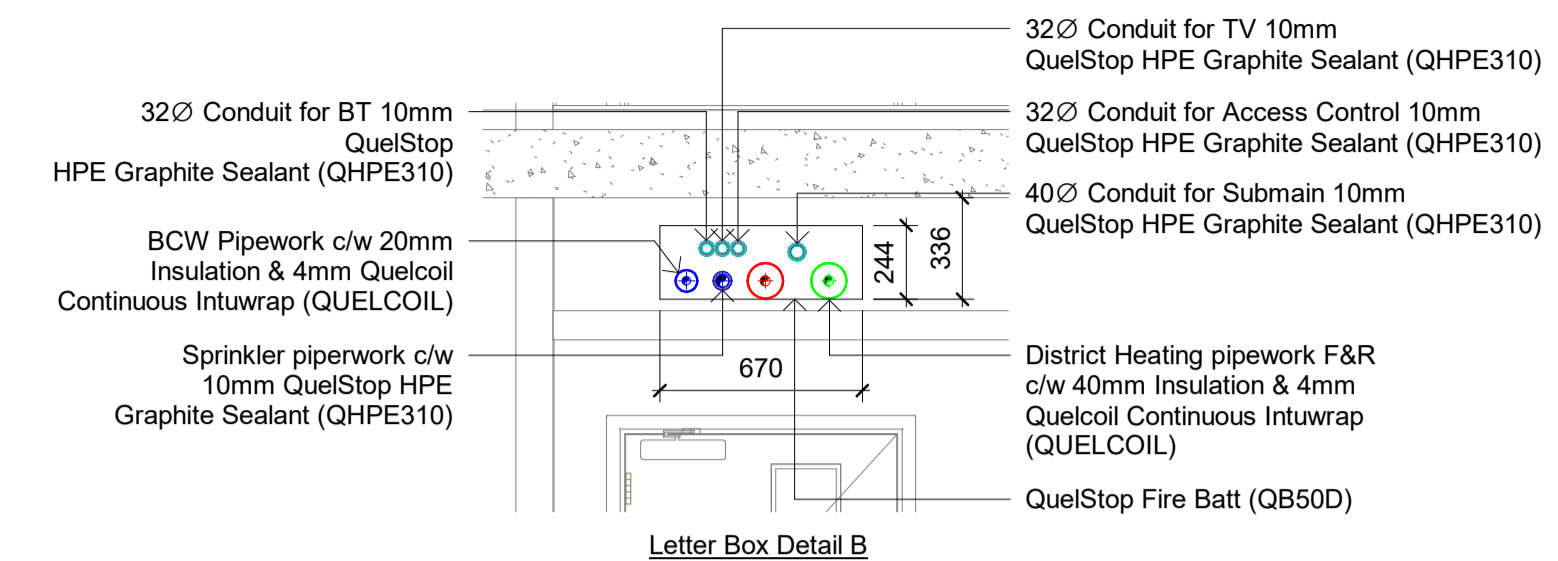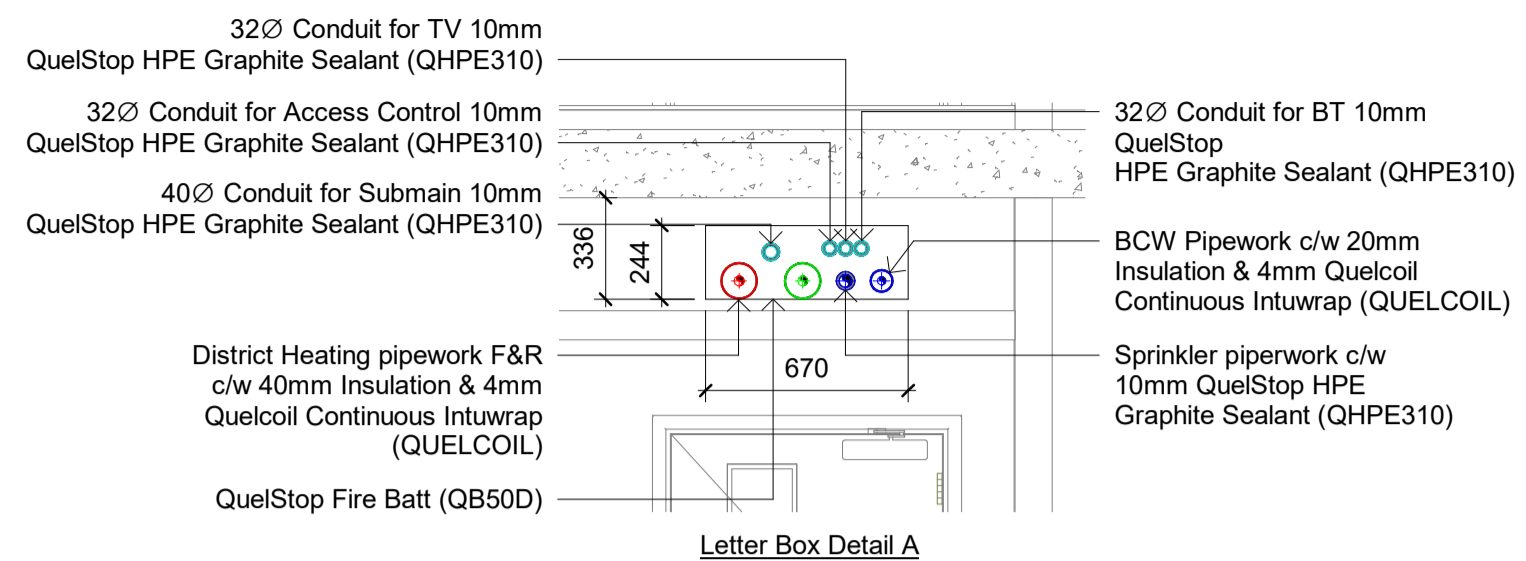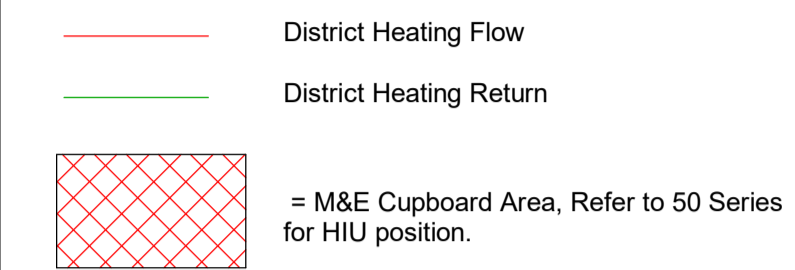

Sheet Notes:



This drawing is the property of Designbrook Ltd and as such may not be copied or communicated to a third party without written authorisation.

This drawing conveys design intent and is provided to assist the contractor in the development of their working drawings. **THE CONTRACTOR SHALL NOT INSTALL TO THIS DRAWING.**

PLEASE DO NOT SCALE FROM THIS DRAWING.

Block D/E - Key Plan

True North
0.00°

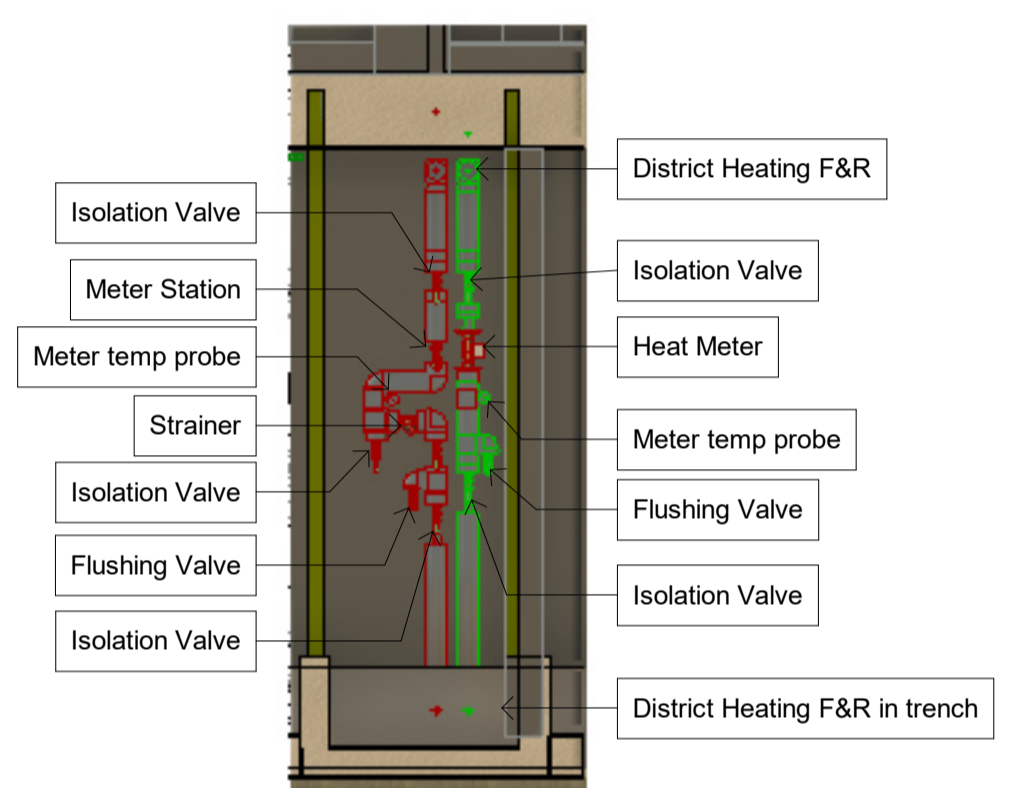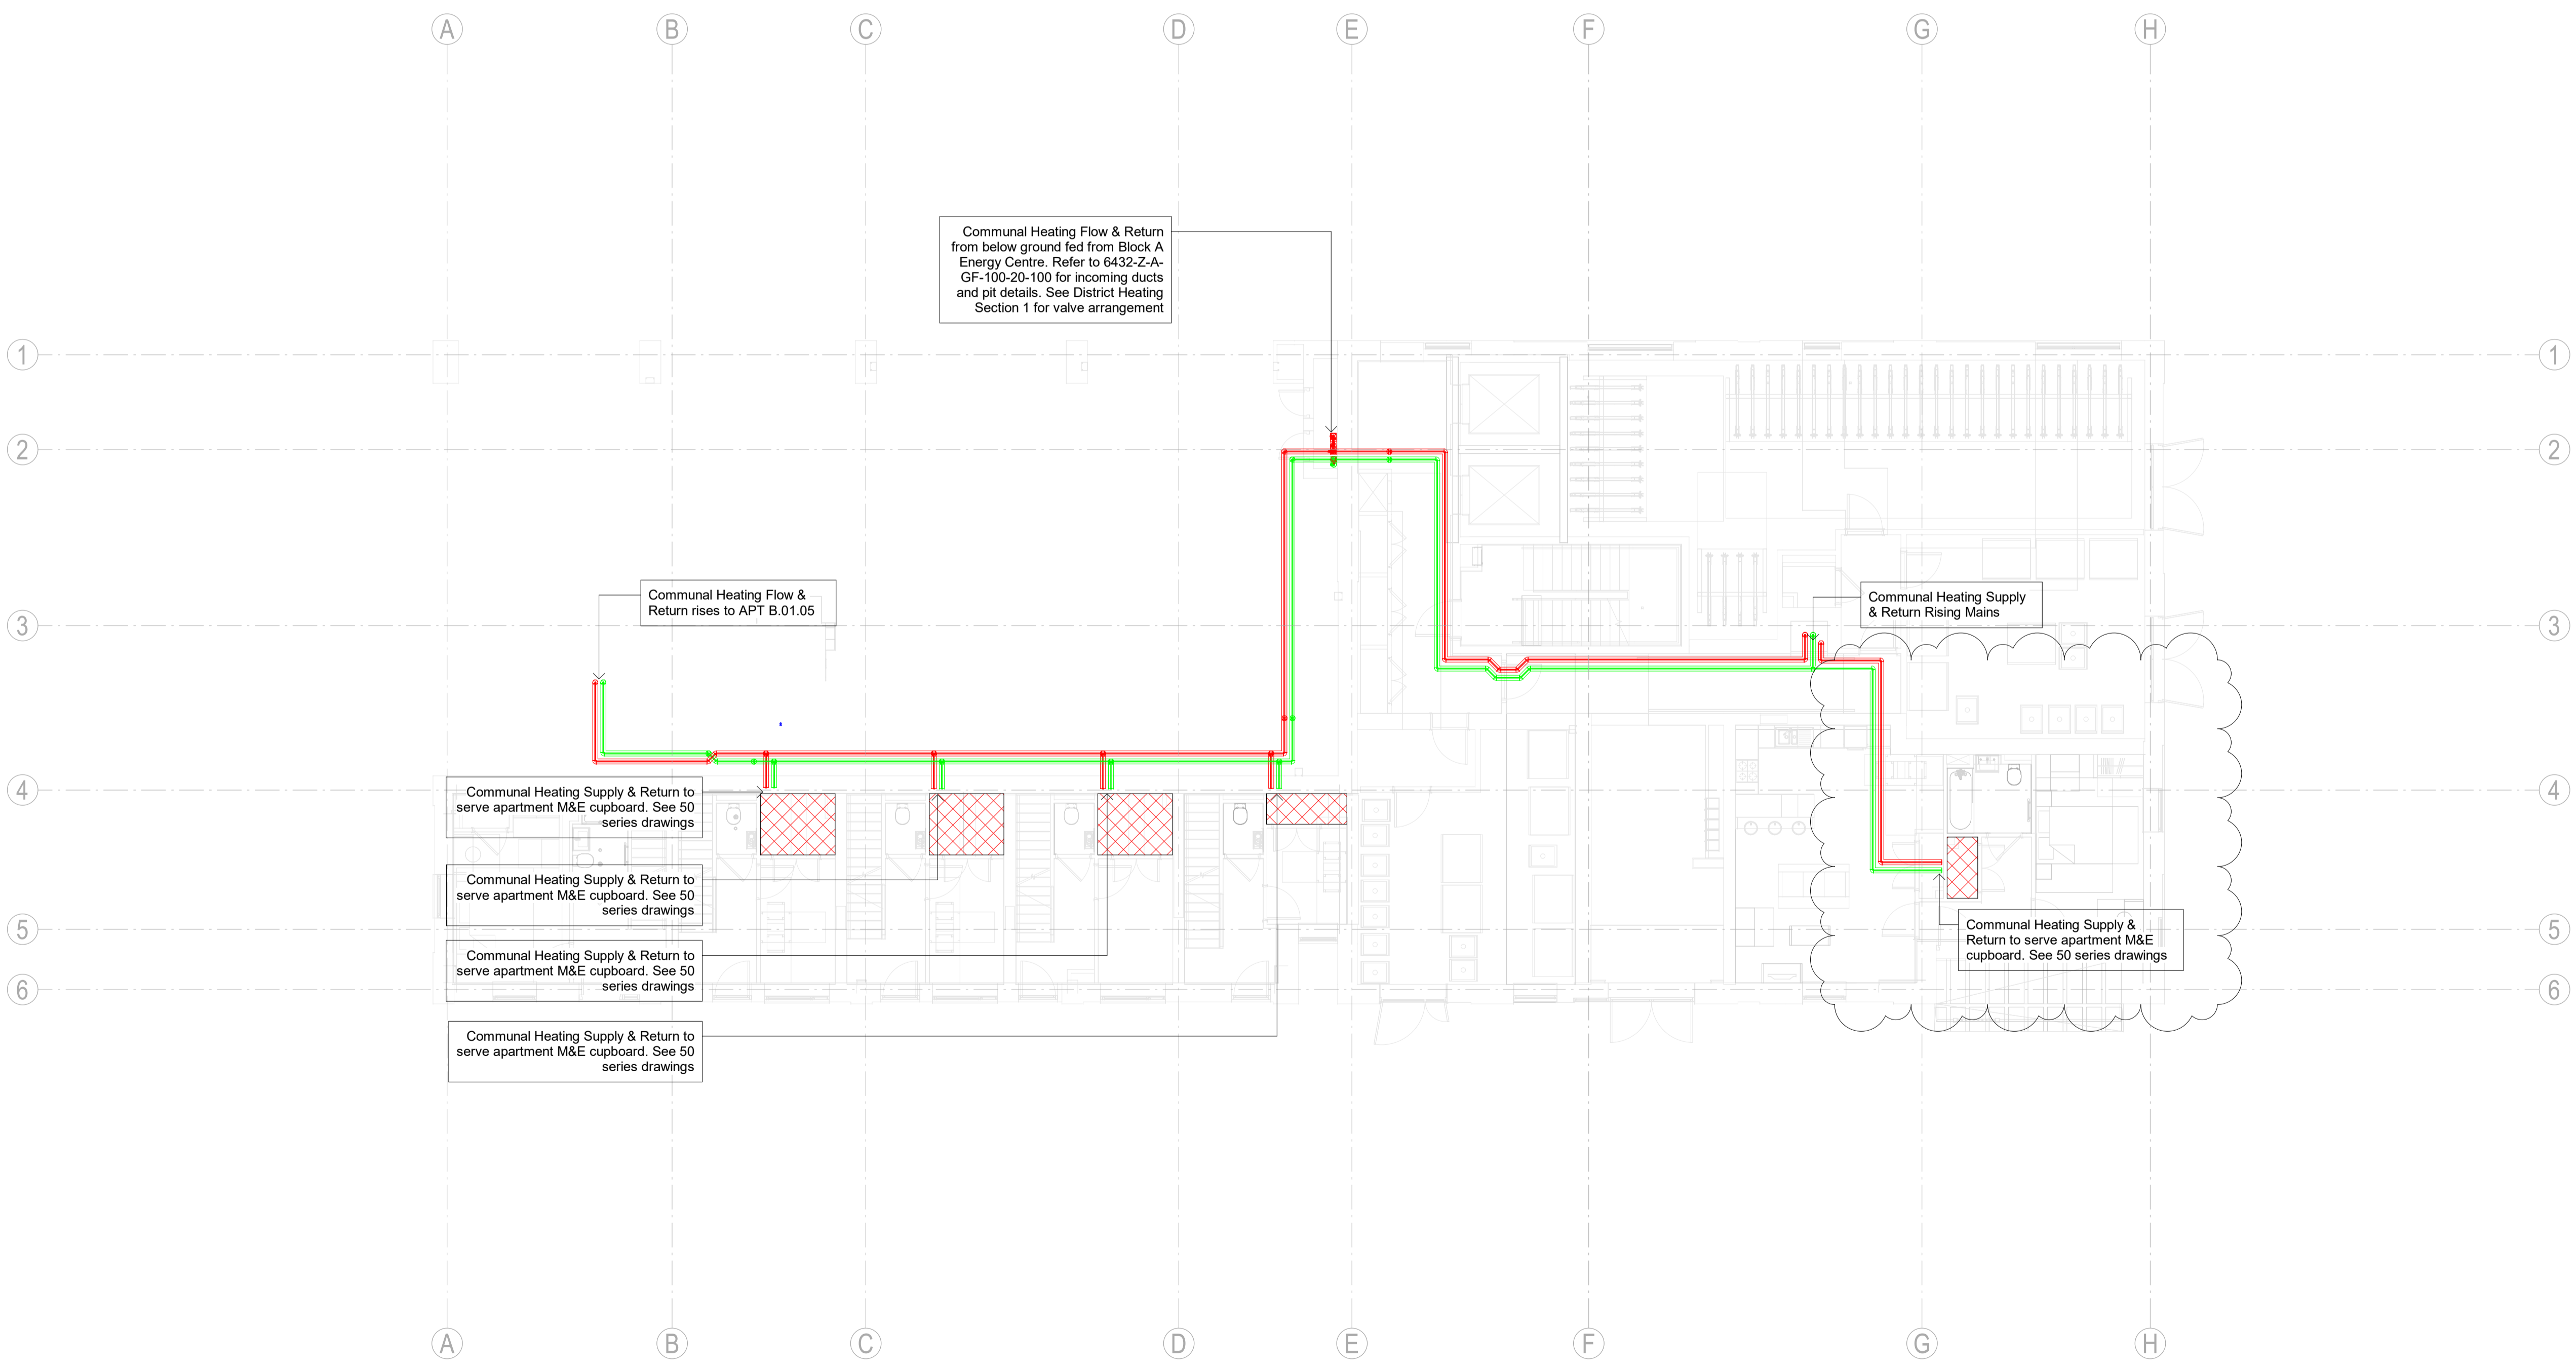

2 District Heating Section 1
 1 : 50

1 D/E - L00 - Communal Heating Services Layout
 1 : 100

REVISION	DRAWN BY	CHECKED BY	DATE	DESCRIPTION
C3	SJL	AE	19/10/23	District Heating route amended to avoid Bin store.
C2	SJL	AE	26/06/23	Containment Route amended to avoid corridor door Krauf fittings as per meeting 22.06.23
C1	SJL	AE	11/04/23	Construction Issue
T2	JE	AE	20/09/22	Updated to latest ER's received & comments from design team
T1	SJL	AE	15/06/22	T1 Issue
P01	JE	AE	25/04/22	Preliminary Issue

CLIENT

LONDON SQUARE
 HEAD OFFICE,
 ONE YORK ROAD,
 UXBRIDGE,
 UXB8 1RN
 WWW.LONDONSQUARE.CO.UK

Designbrook Ltd.
 Unit J2, The Granary,
 Bridge Farm,
 Reading Road,
 Arborfield,
 Berkshire, RG2 9HT
 Tel: 0118 9 773 011
 E-mail: admin@designbrook.co.uk

PROJECT TITLE
The Hyde, Colindale, Phase 1

DRAWING ISSUE
Construction Issue

DRAWING TITLE
Block D/E- Ground floor , Communal Heating Primary Service Routes

SCALE	1:100@A1	DRAWN	JE
DATE	23/06/2022	CHECKED	AJE
DBR Project No.		J6432	

Identification Drawing Number 6432-M-DE-00-100-56-110

Sheet Number Rev. C3

