



This drawing shall be read in conjunction with all other drawings and specifications

For Notes, Details refer to the following drawings:
 6432-M-Z-M-000-50-900
 6432-M-Z-M-000-50-901





For Communal Heating Schematics refer to the following drawings:
 6432-M-A-M-700-56-700
 6432-M-A-M-700-56-701
 6432-M-BC-M-700-56-702
 6432-M-DE-M-700-56-703
 6432-M-FG-M-700-56-704

For Communal Heating Equipment Schedules refer to the following:
 6432-M-A-ZZ-600-07-130


For Communal Heating Plantroom & Roof Layout refer to drg:
 6432-M-A-01-100-56-100
 6432-M-A-16-100-56-100

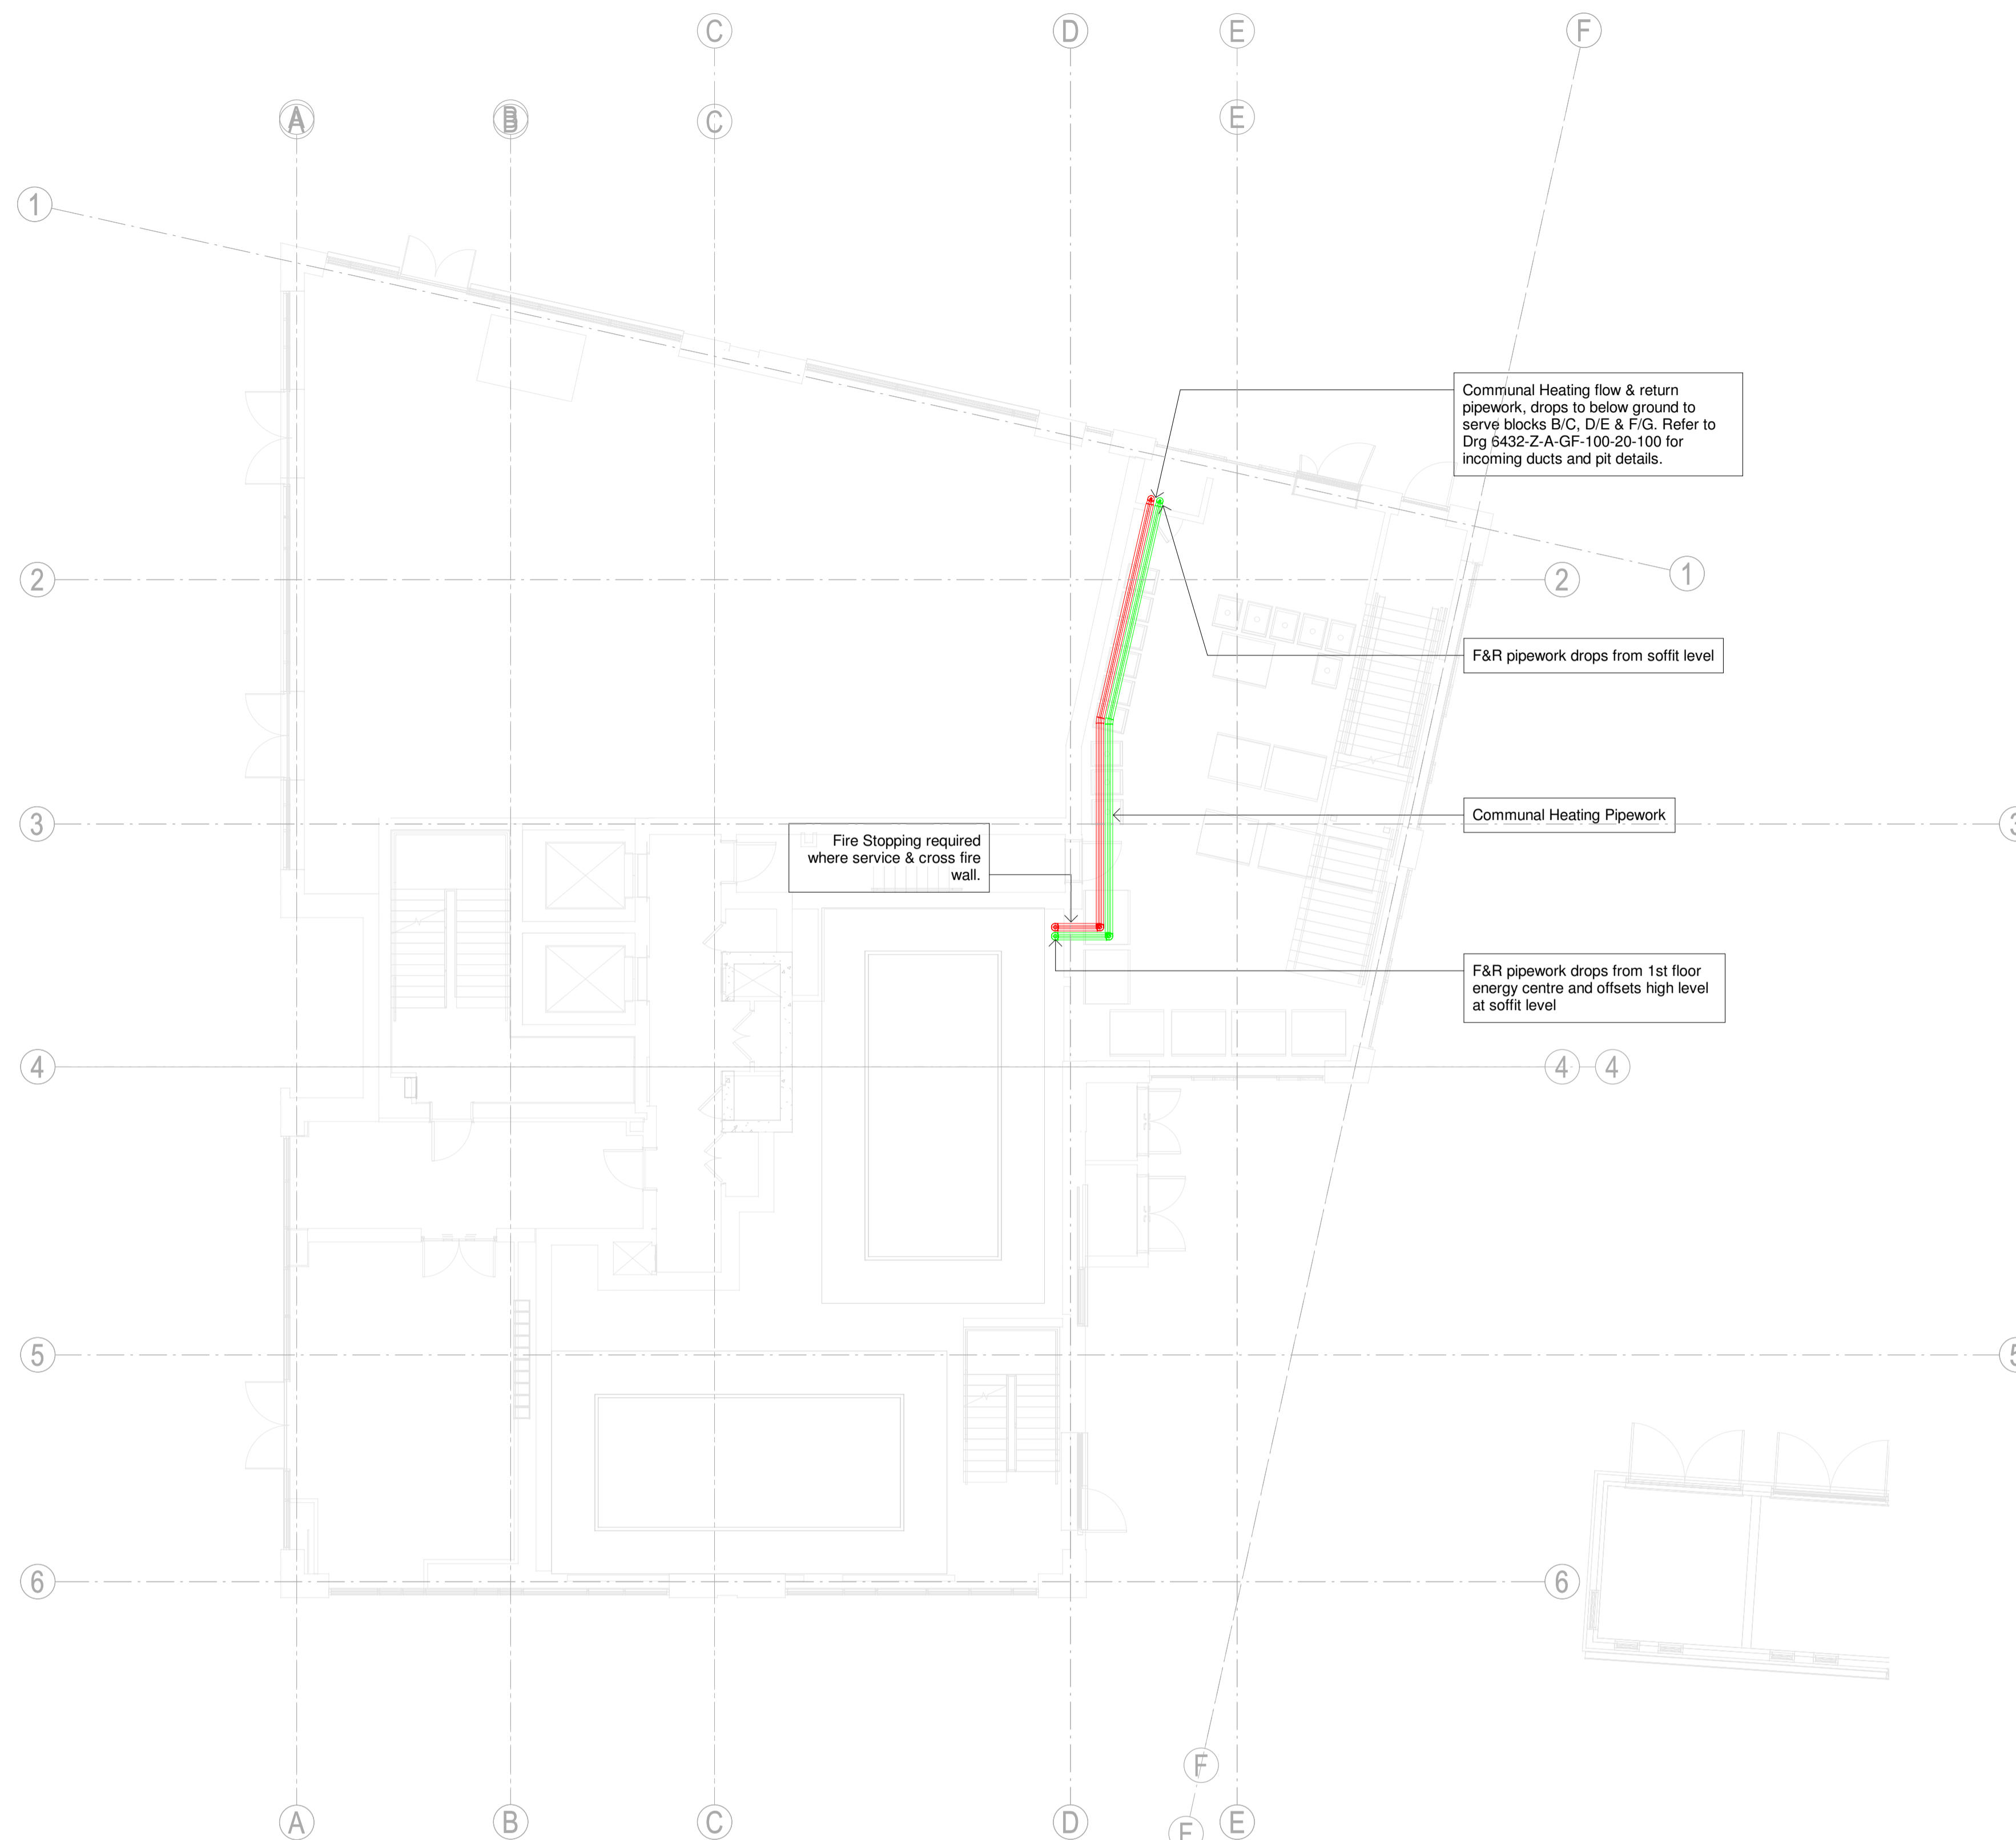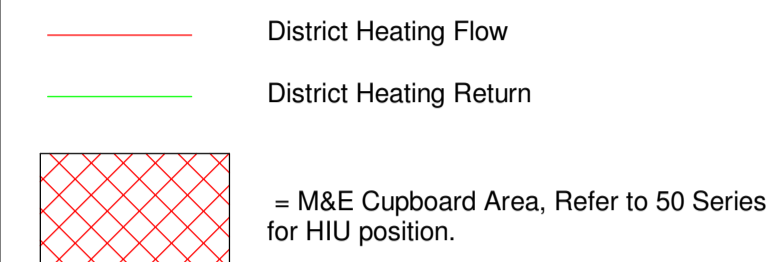

1 L00 - Communal Heating Services Layout
 1 : 100

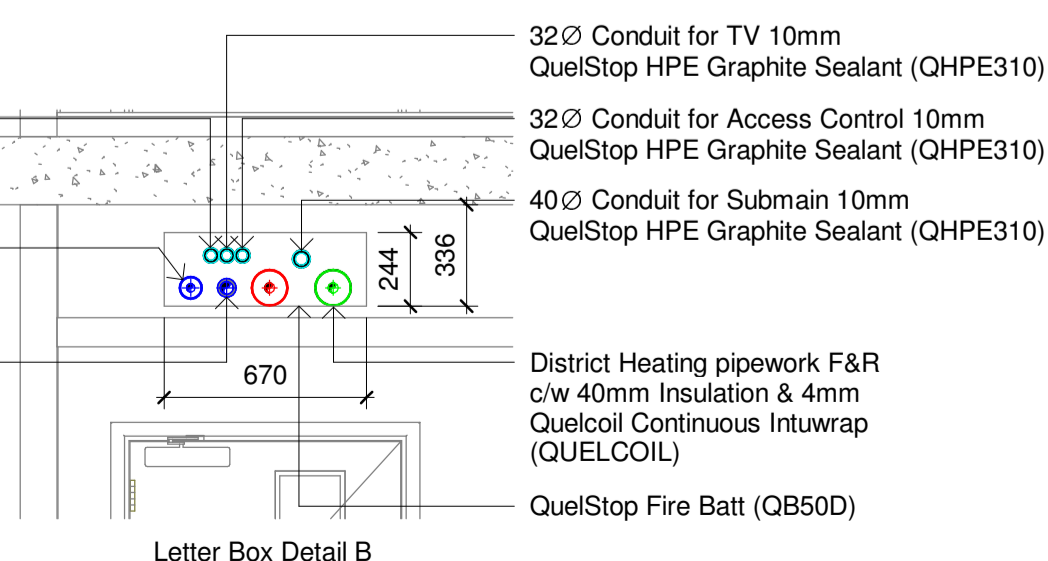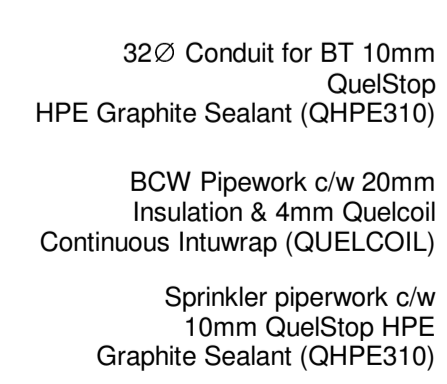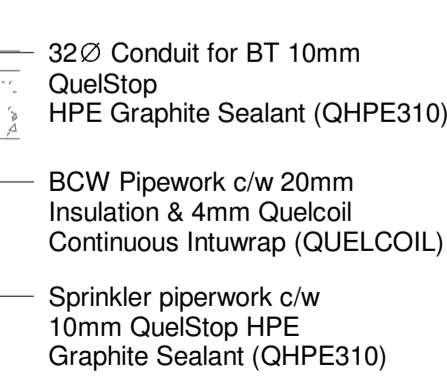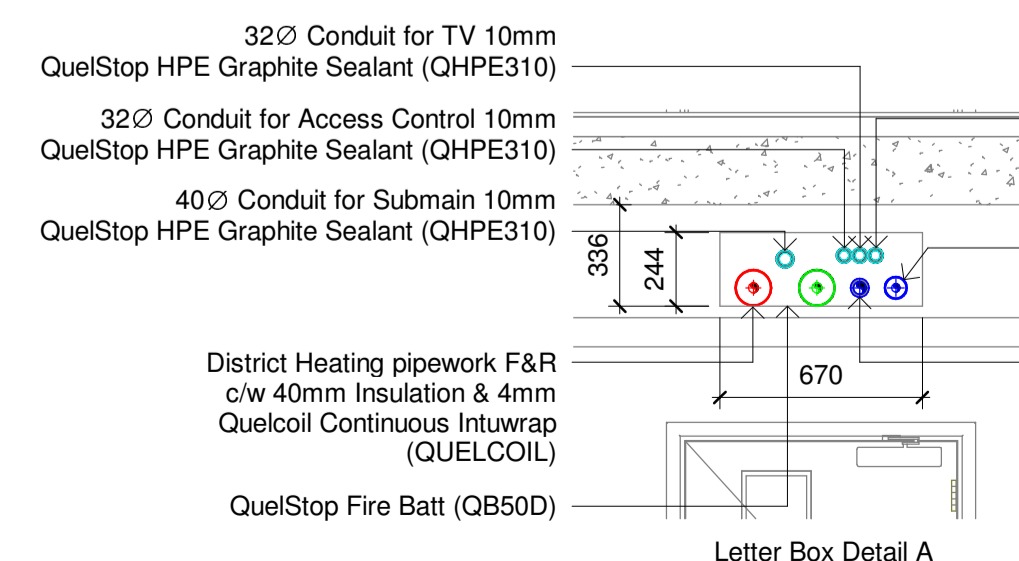

Sheet Notes:
 This drawing is the property of Designbrook Ltd and as such may not be copied or communicated to a third party without written authorisation.
 This drawing conveys design intent and is provided to assist the contractor in the development of their working drawings. **THE CONTRACTOR SHALL NOT INSTALL TO THIS DRAWING.**
PLEASE DO NOT SCALE FROM THIS DRAWING.

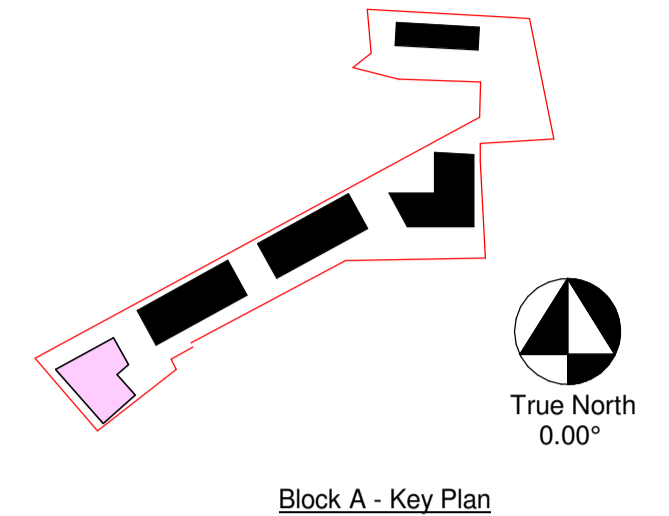

REVISION	DATE	BY	DESCRIPTION
C1	AG AE 11/04/23		Construction Issue
T2	JE AE 20/09/22		Updated to latest EIT's received & comments from design team
T1	SJL AE 15/06/22		T1 Issue
P01	JE AE 25/04/22		Preliminary Issue

CLIENT
LONDON SQUARE
 HEAD OFFICE,
 ONE YORK ROAD,
 UXBRIDGE,
 UES 15RN
 WWW.LONDONSQUARE.CO.UK

Designbrook Ltd,
 Unit J2, The Granary,
 Bridge Farm,
 Reading Road,
 Arborfield,
 Berkshire, RG2 9HT
 Tel: 0118 9 773 011
 E-mail: admin@designbrook.co.uk

PROJECT TITLE
The Hyde, Colindale, Phase 1
 DRAWING ISSUE
Construction Issue
 DRAWING TITLE
Block A - Ground Floor, Communal Heating Primary Service Routes

SCALE	DRAWN
1:100@A1	JE
DATE	CHECKED
25/04/2022	AJE

Identification	Sheet Number
Drawing Number	Rev.
6432-M-A-00-100-56-100	C1

