



Communal Heating Notes  
 This drawing shall be read in conjunction with all other drawings and specifications

For Notes, Details refer to the following drawings:  
 6432-M-Z-M-000-50-900  
 6432-M-Z-M-000-50-901

For Communal Heating Schematics refer to the following drawings:  
 6432-M-A-M-700-56-700  
 6432-M-A-M-700-56-701  
 6432-M-BC-M-700-56-702  
 6432-M-DE-M-700-56-703  
 6432-M-FG-M-700-56-704





For Communal Heating Equipment Schedules refer to the following:  
 6432-M-A-ZZ-600-07-130

For Communal Heating Plantroom & Roof Layout refer to drg:  
 6432-M-A-01-100-56-100  
 6432-M-A-16-100-56-100

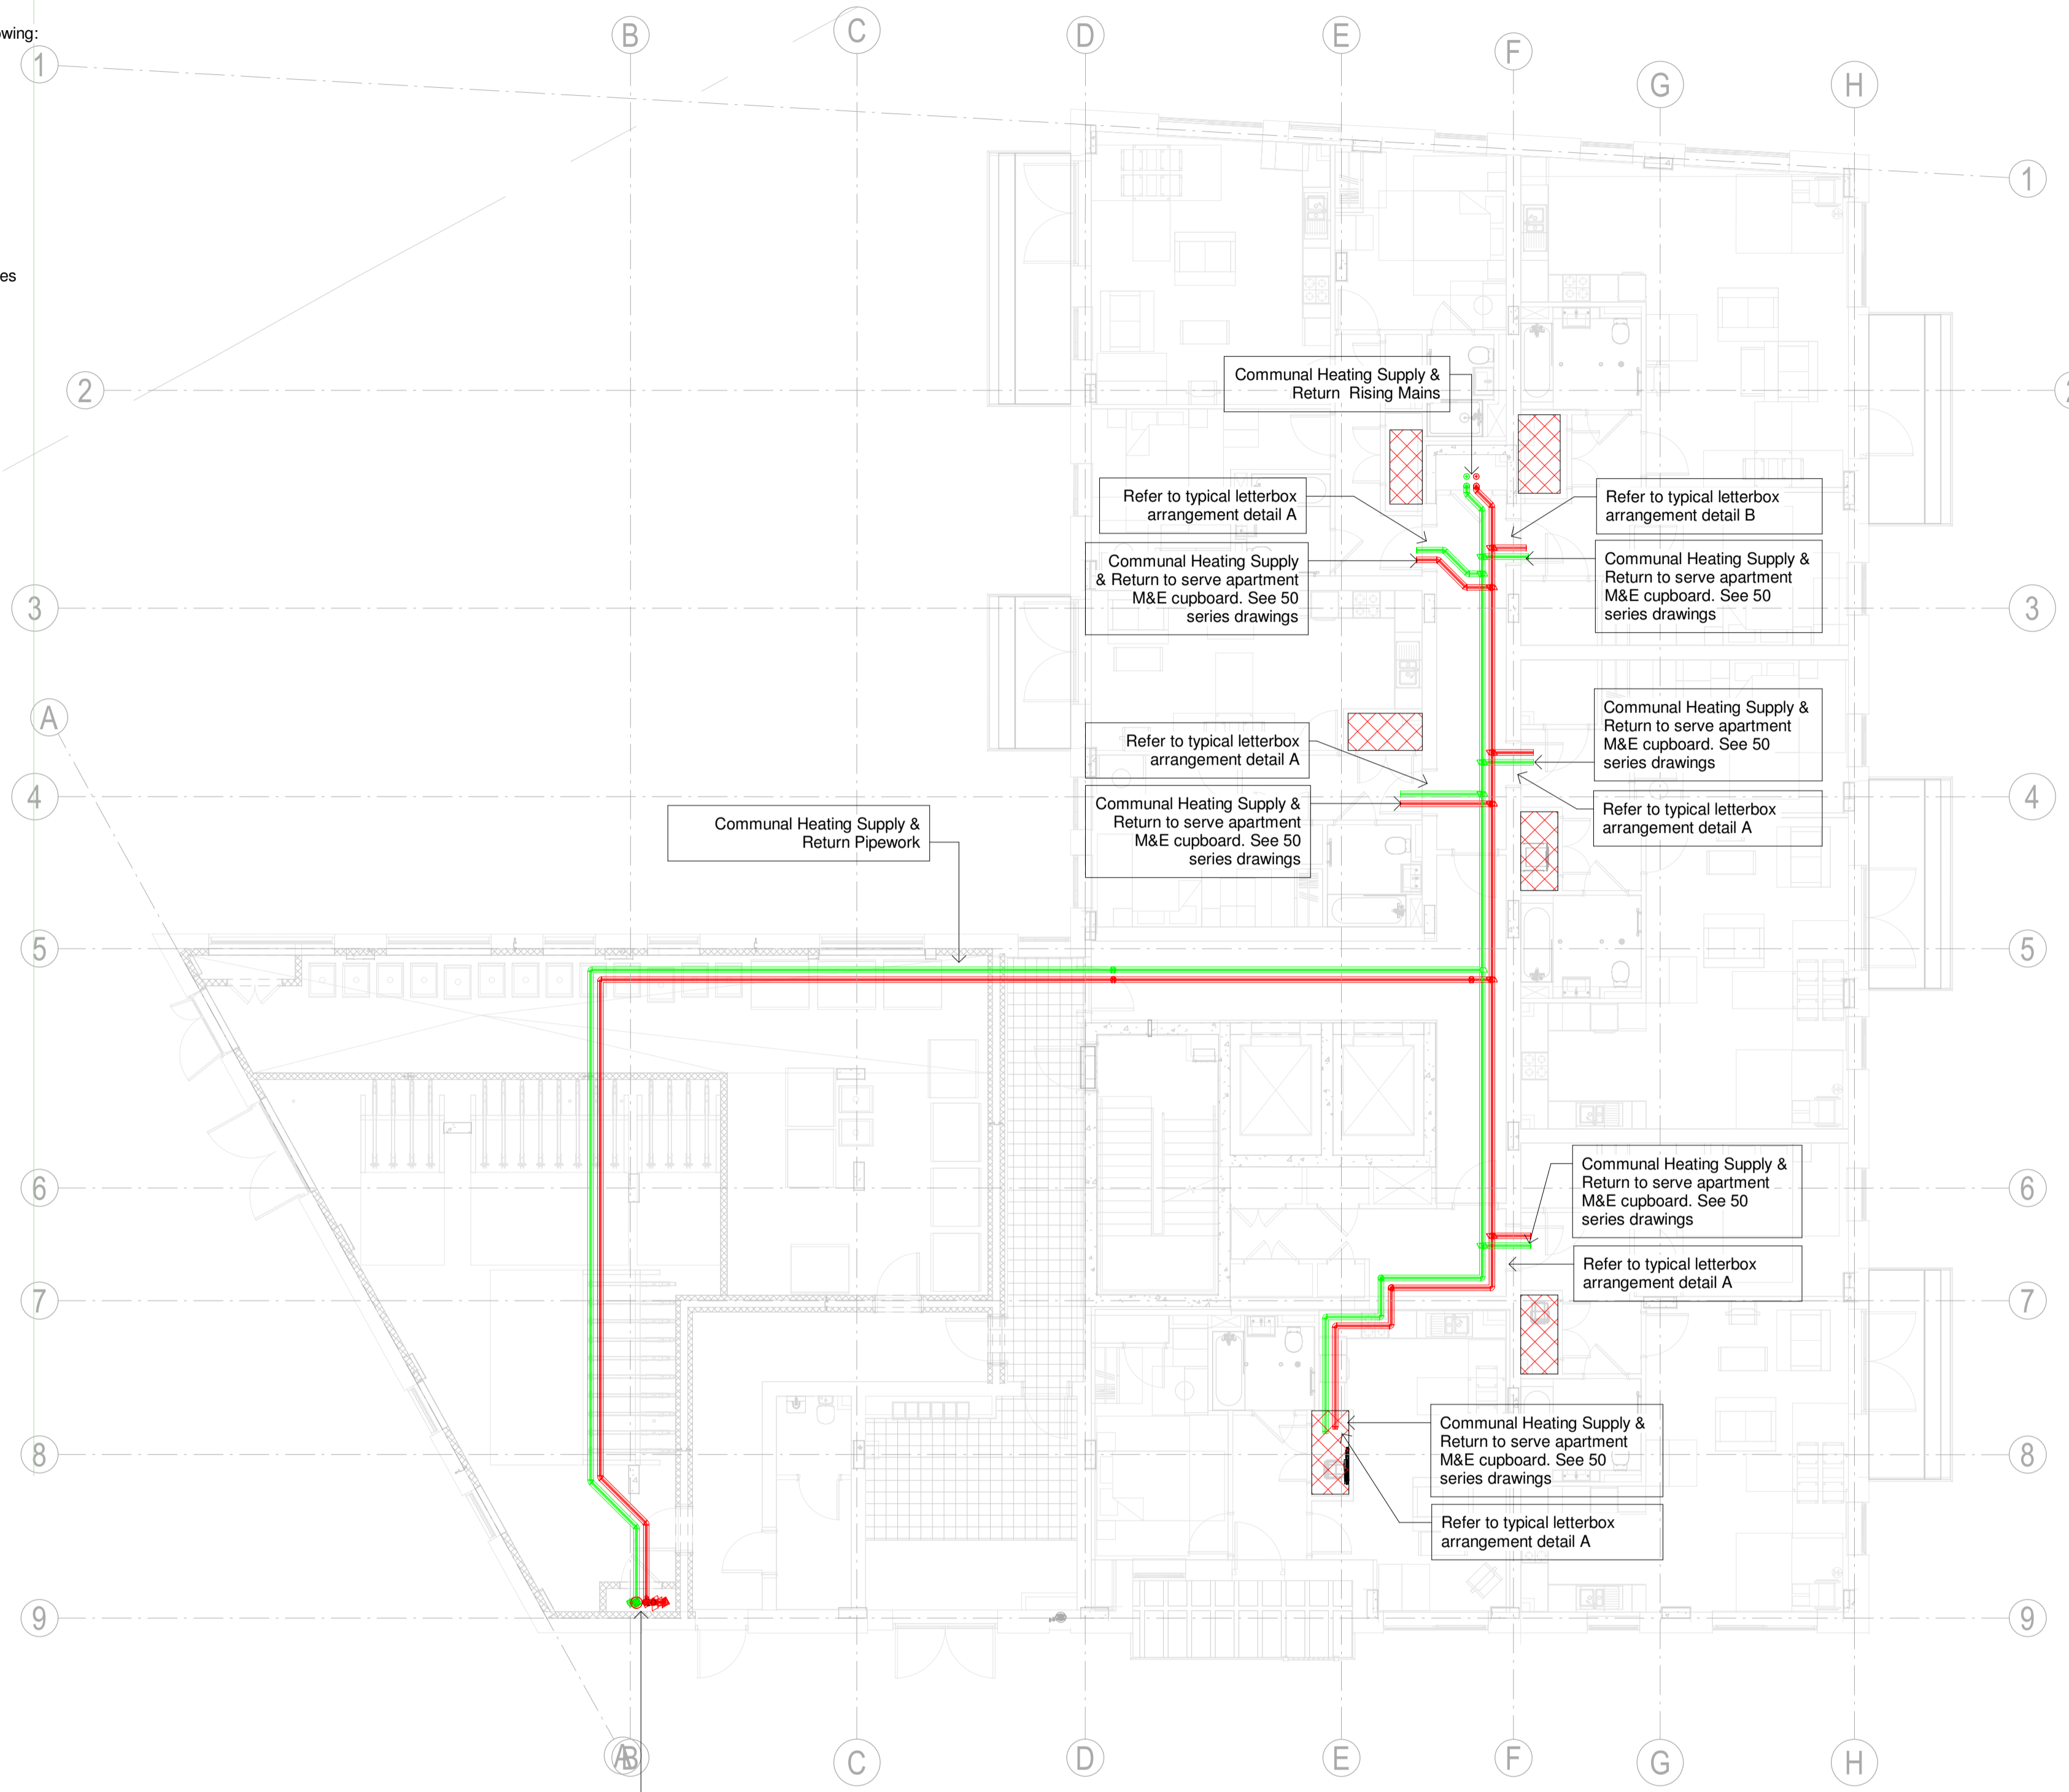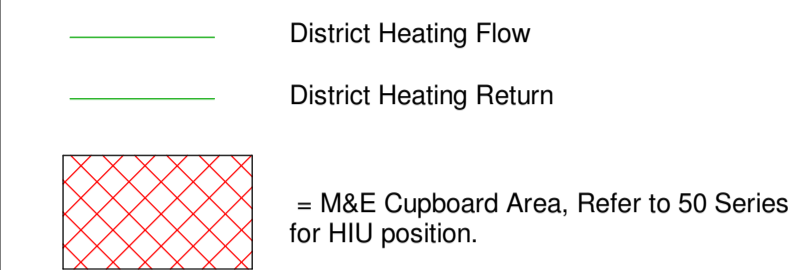

**1 L00 - Communal Heating Services Layout**  
 1 : 100

Sheet Notes:  
 This drawing is the property of Designbrook Ltd and as such may not be copied or communicated to a third party without written authorisation.  
 This drawing conveys design intent and is provided to assist the contractor in the development of their working drawings. **THE CONTRACTOR SHALL NOT INSTALL TO THIS DRAWING.**  
**PLEASE DO NOT SCALE FROM THIS DRAWING.**

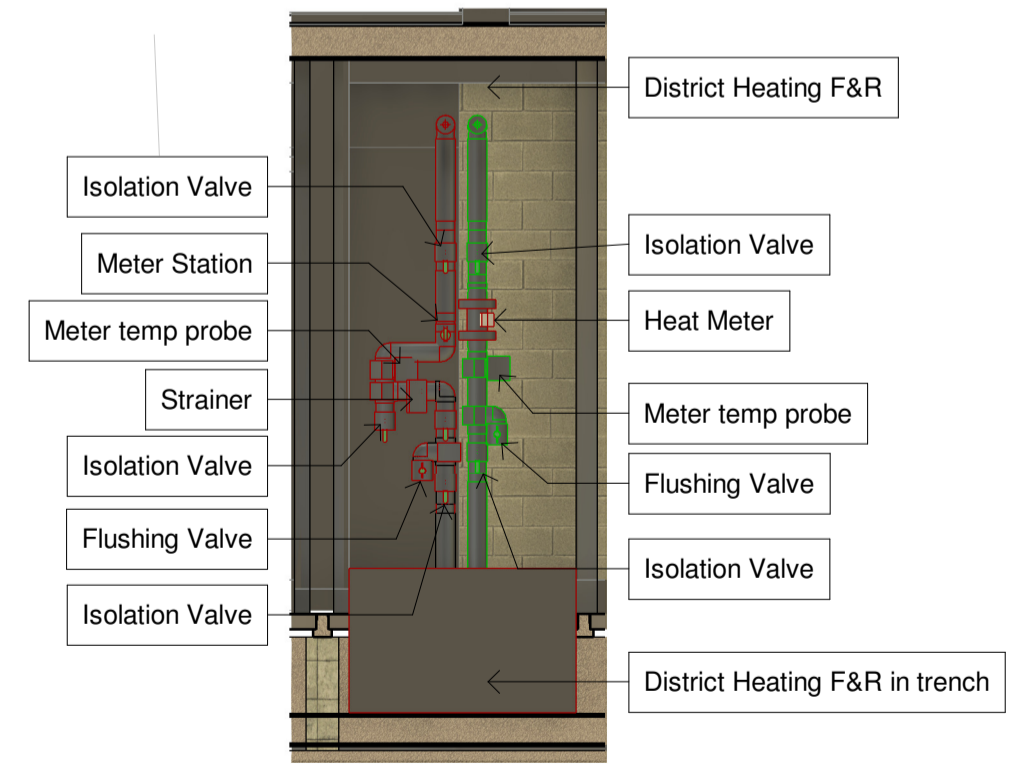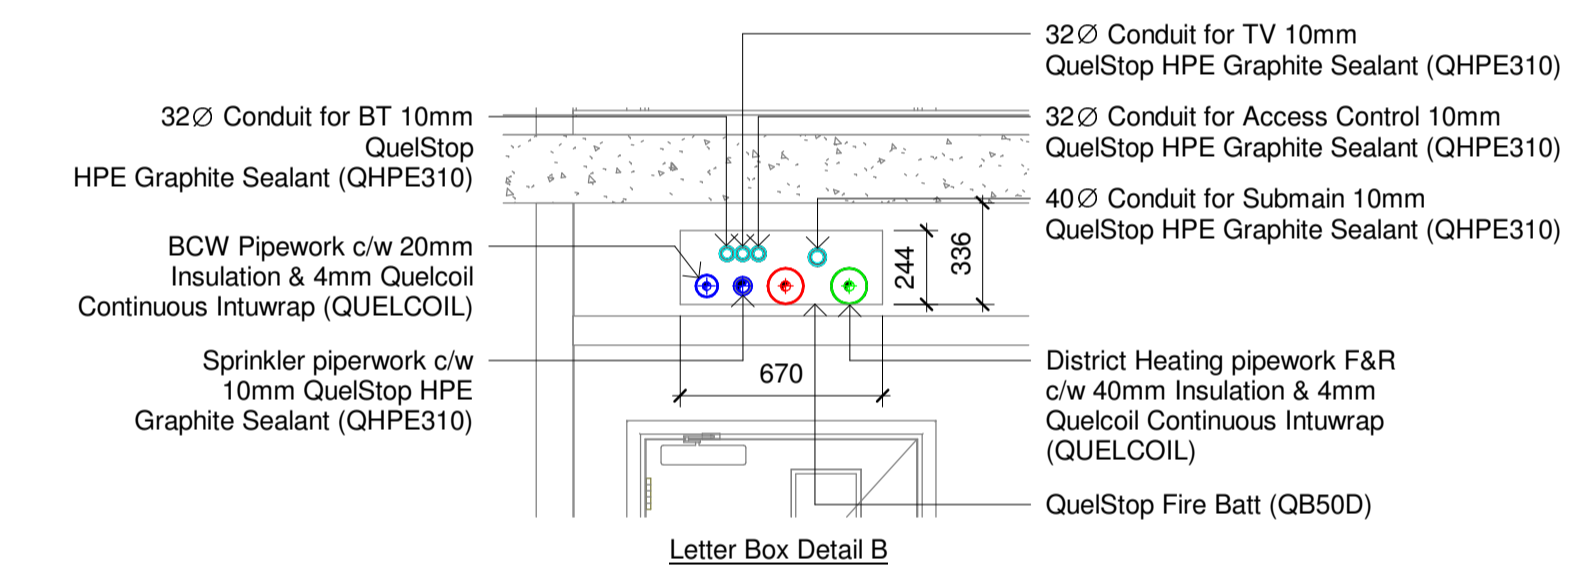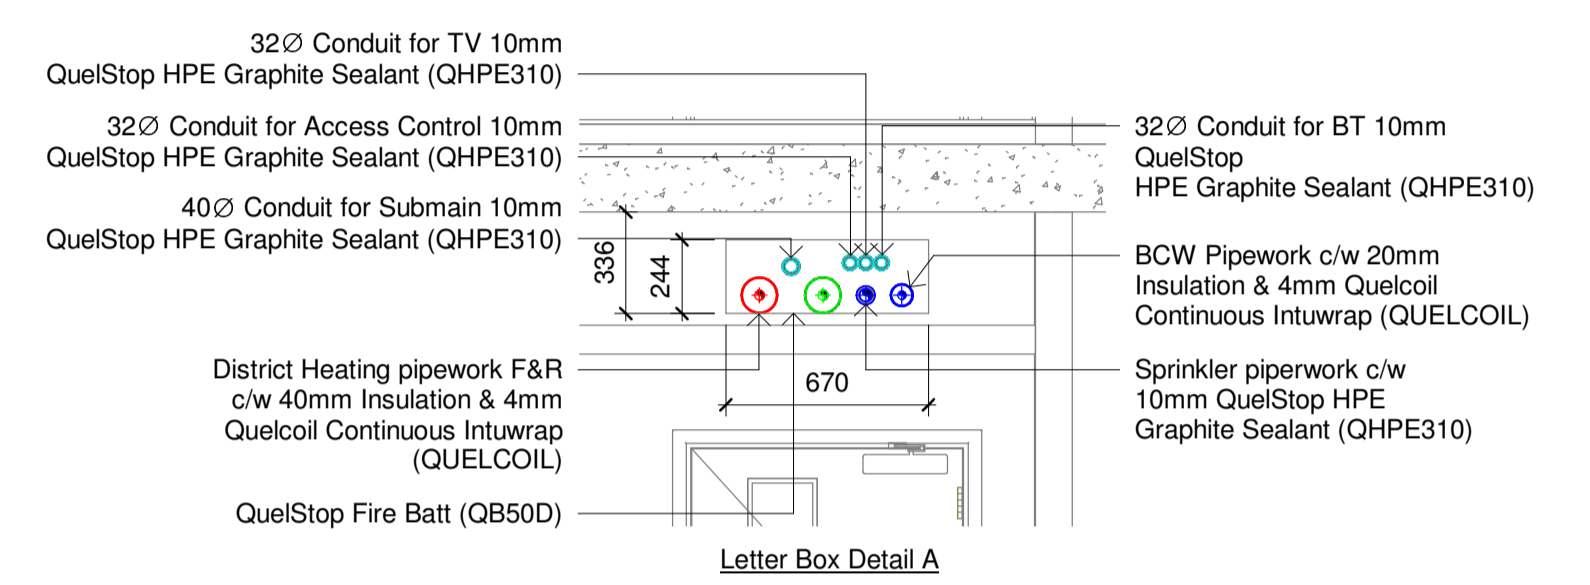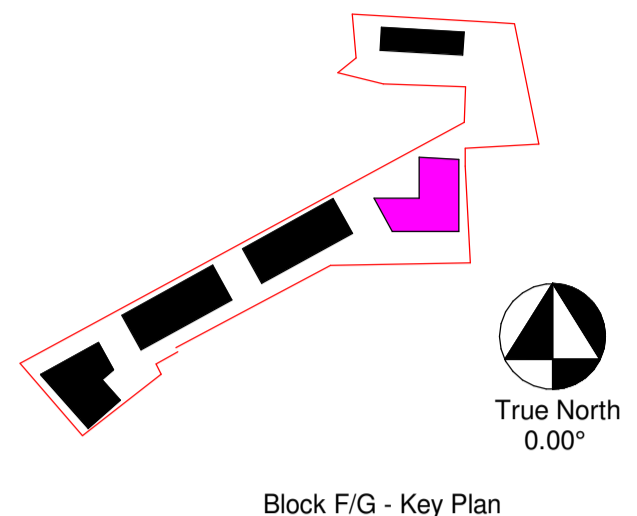

**2 District Heating Section 1**  
 1 : 50

C1	AG	AE	11/04/23	Construction Issue
T2	JE	AE	20/09/22	Updated to latest ER's received & comments from design team
T1	SJL	AE	15/06/22	T1 Issue
P01	JE	AE	25/04/22	Preliminary Issue

REVISION	DRAWN BY	CHECKED BY	DATE	DESCRIPTION

CLIENT  
**LONDON SQUARE**  
 HEAD OFFICE,  
 ONE YORK ROAD,  
 UXBRIDGE,  
 UES 12N  
 WWW.LONDONSQUARE.CO.UK

Designbrook Ltd,  
 Unit J2, The Granary,  
 Bridge Farm,  
 Reading Road,  
 Arborfield,  
 Berkshire, RG2 9HT  
 Tel: 0118 9 773 011  
 E-mail: admin@designbrook.co.uk

PROJECT TITLE  
 The Hyde, Colindale, Phase 1  
 DRAWING ISSUE  
**Construction Issue**  
 DRAWING TITLE  
 Block F/G - Ground Floor, Communal Heating Primary Service Routes

SCALE	1:100@A1	DRAWN	JE
DATE	23/06/2022	CHECKED	AE
D&R Project No.		J6432	

Identification	Sheet Number
Drawing Number	Rev.
6432-M-FG-00-100-56-130	C1

