

Communal Heating Notes

This drawing shall be read in conjunction with all other drawings and specifications


For Notes, Details refer to the following drawings:
 6432-M-Z-M-000-50-900
 6432-M-Z-M-000-50-901

For Communal Heating Schematics refer to the following drawings:
 6432-M-A-M-700-56-700
 6432-M-A-M-700-56-701
 6432-M-BC-M-700-56-702
 6432-M-DE-M-700-56-703
 6432-M-FG-M-700-56-704




For Communal Heating Equipment Schedules refer to the following:
 6432-M-A-ZZ-600-07-130

For Communal Heating Plantroom & Roof Layout refer to drg:
 6432-M-A-01-100-56-100
 6432-M-A-16-100-56-100


- District Heating Flow
- District Heating Return
- = M&E Cupboard Area, Refer to 50 Series for HIU position.

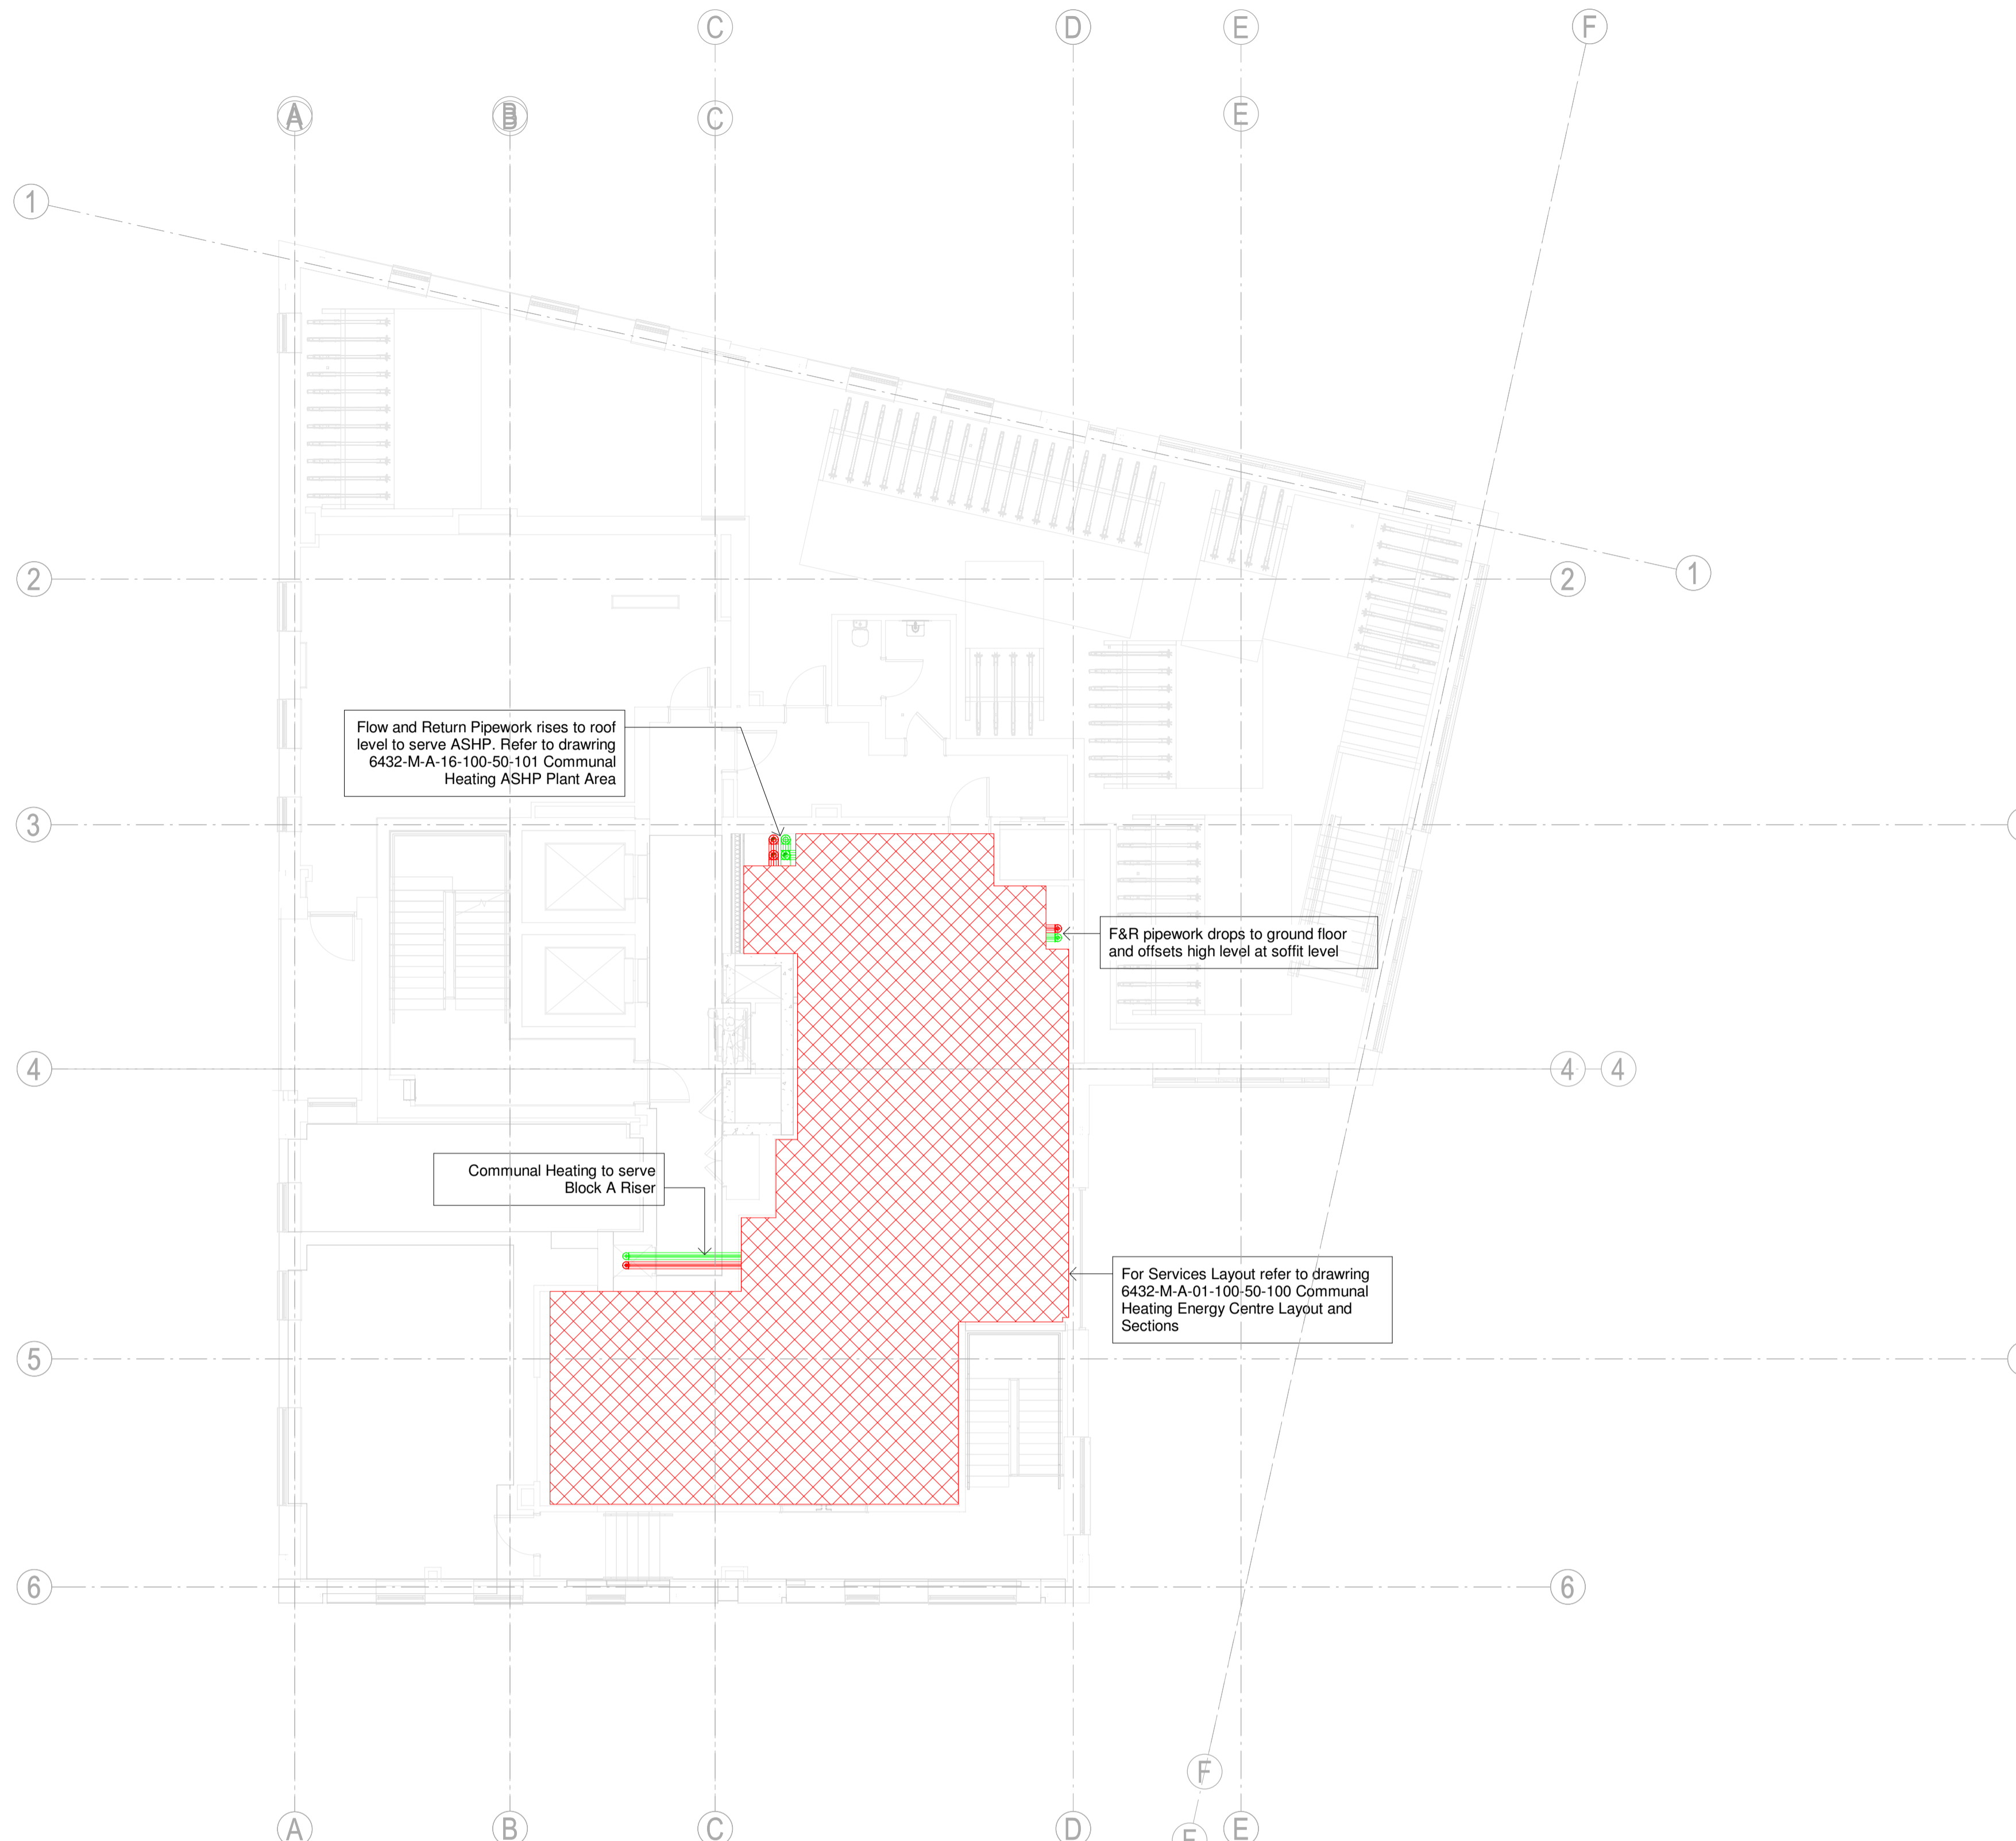

1 L01 - Communal Heating Services Layout
 1 : 100

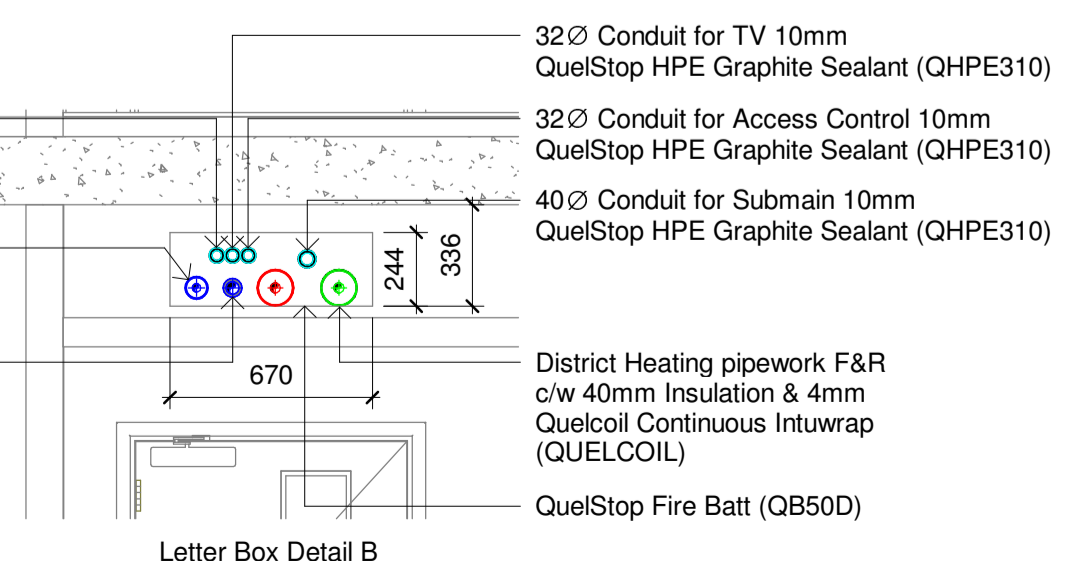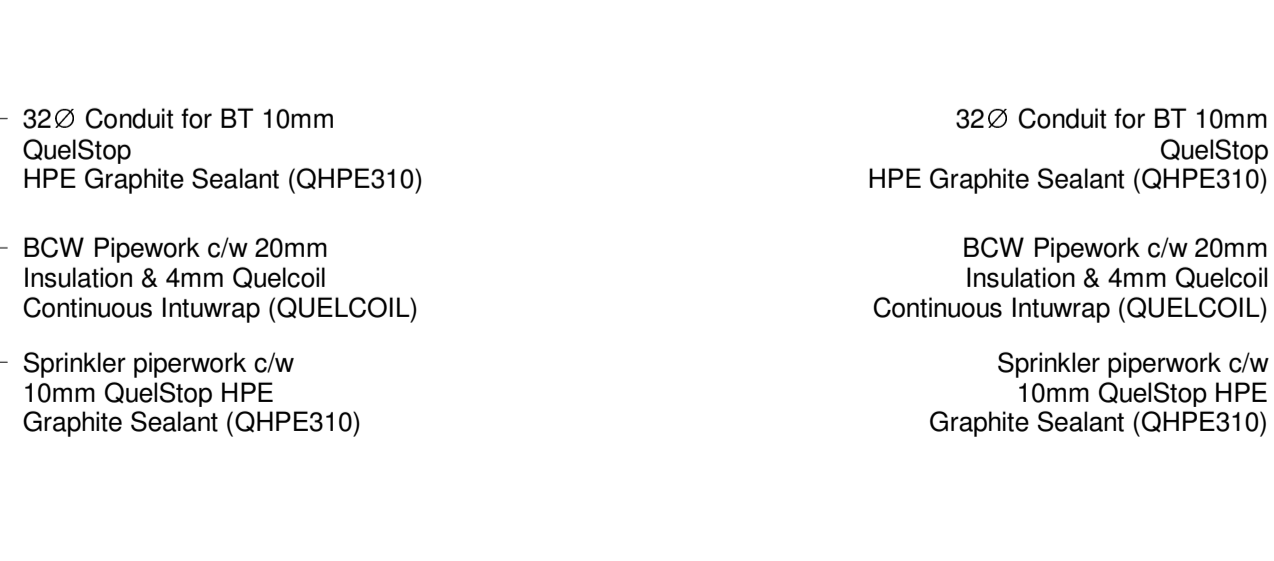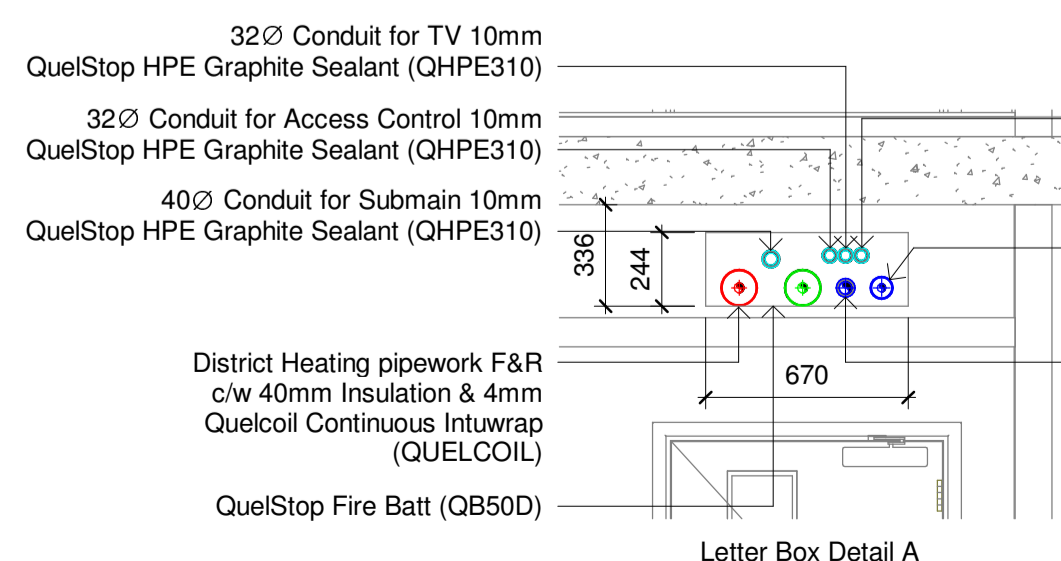

Sheet Notes:
 This drawing is the property of Designbrook Ltd and as such may not be copied or communicated to a third party without written authorisation.
 This drawing conveys design intent and is provided to assist the contractor in the development of their working drawings. THE CONTRACTOR SHALL NOT INSTALL TO THIS DRAWING.
 PLEASE DO NOT SCALE FROM THIS DRAWING.

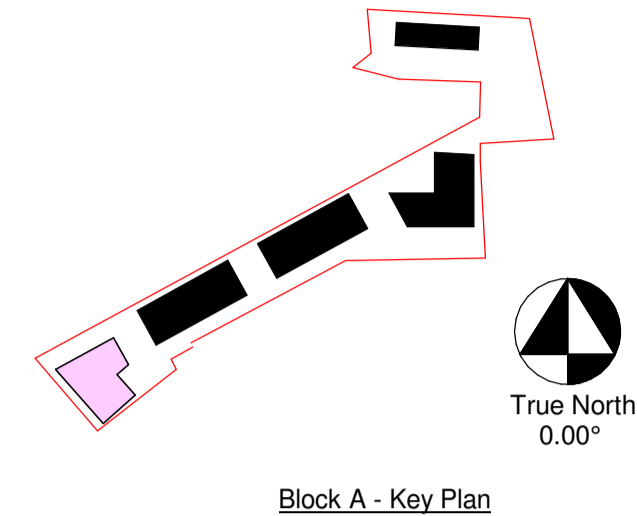

REVISION	DESIGNED BY	CHECKED BY	DATE	DESCRIPTION
C1	AG	AE	11/04/23	Construction Issue
T2	JE	AE	20/09/22	Updated to latest ERFs received & comments from design team
T1	SJL	AE	15/06/22	T1 Issue
P01	JE	AE	25/04/22	Preliminary Issue

CLIENT
LONDON SQUARE
 HEAD OFFICE,
 ONE YORK ROAD,
 UXBRIDGE,
 UES 15RN
 WWW.LONDONSQUARE.CO.UK

Designbrook Ltd.
 Unit J2, The Granary,
 Bridge Farm,
 Reading Road,
 Arborfield,
 Berkshire, RG2 9HT
 Tel: 0118 9 773 011
 E-mail: admin@designbrook.co.uk

PROJECT TITLE
 The Hyde, Colindale, Phase 1
DRAWING ISSUE
 Construction Issue
DRAWING TITLE
 Block A - First Floor, Communal Heating Primary Service Routes

SCALE	1:100@A1	DRAWN	JE
DATE	25/04/2022	CHECKED	AJE
D&R Project No.		J6432	
Identification	Sheet Number		
Drawing Number	Rev.		

6432-M-A-01-100-56-101 C1

