
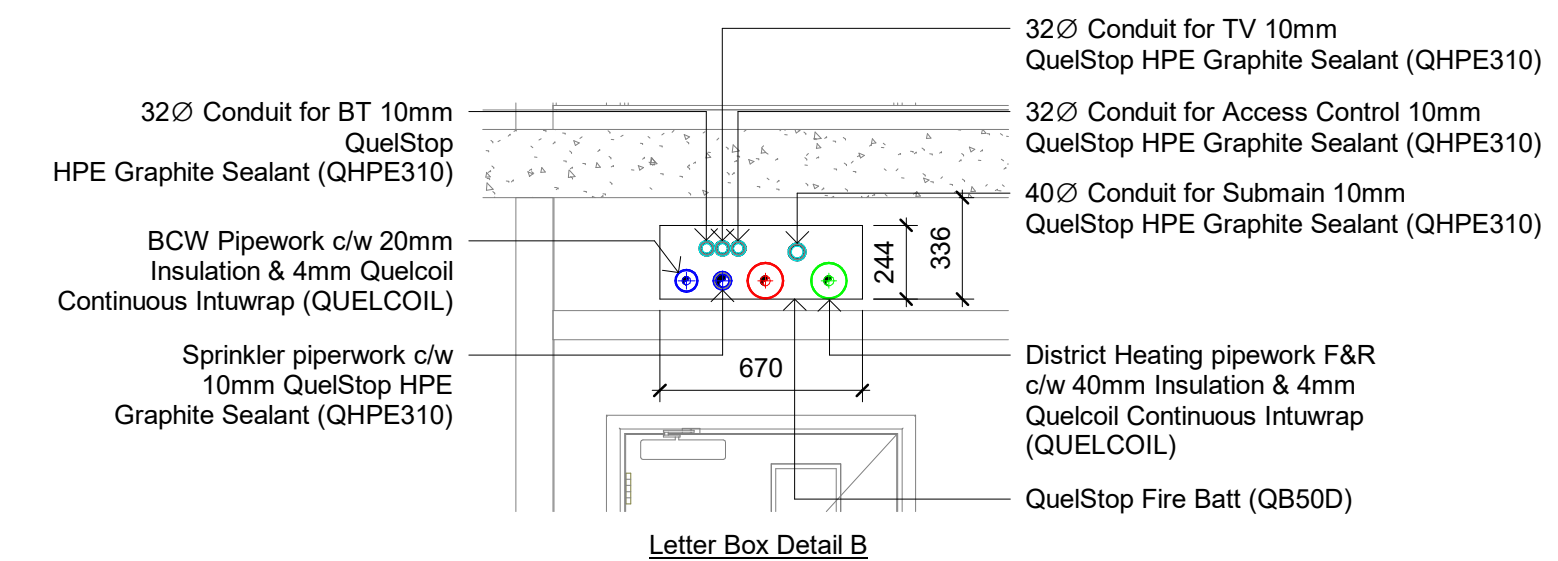
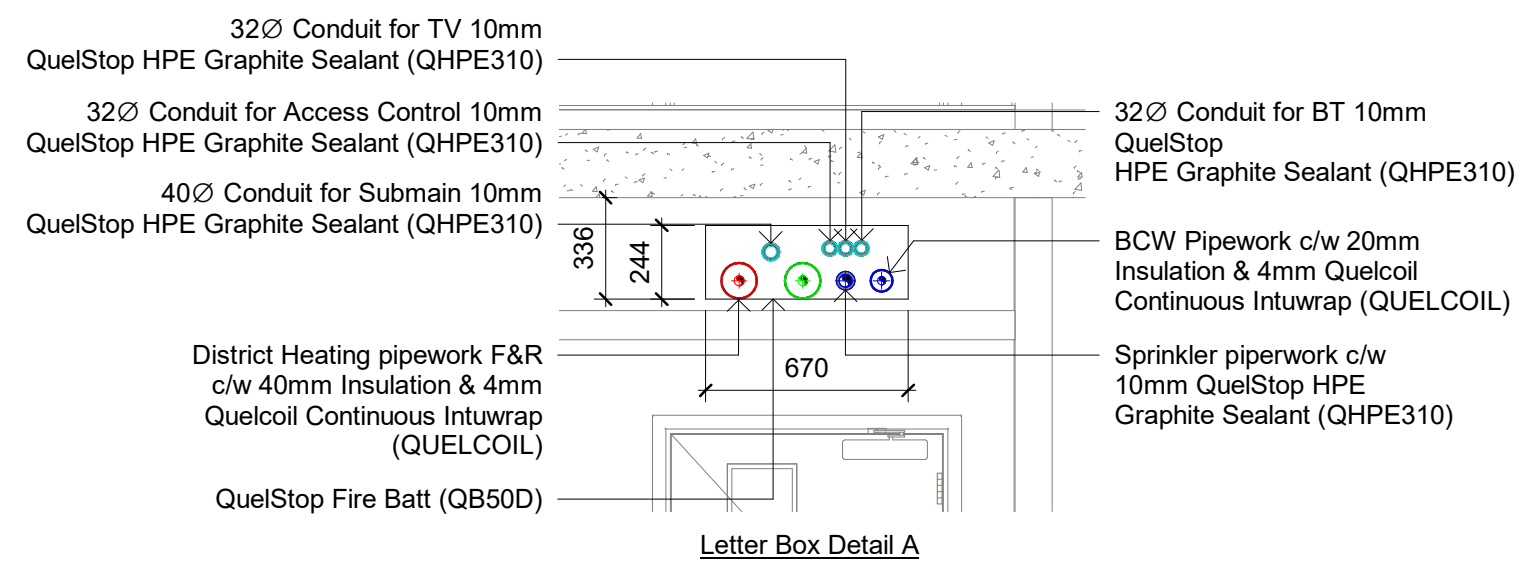


For Notes. Details refer to the following drawings:  
 6432-M-Z-M-000-50-900  
 6432-M-Z-M-000-50-901

For Communal Heating Schematics refer to the following drawings:  
 6432-M-A-M-700-56-700  
 6432-M-A-M-700-56-701  
 6432-M-BC-M-700-56-702  
 6432-M-DE-M-700-56-703  
 6432-M-FG-M-700-56-704

For Communal Heating Equipment Schedules refer to the following:  
 6432-M-A-ZZ-600-07-130


For Communal Heating Plantroom & Roof Layout refer to drg:  
 6432-M-A-01-100-56-100  
 6432-M-A-16-100-56-100

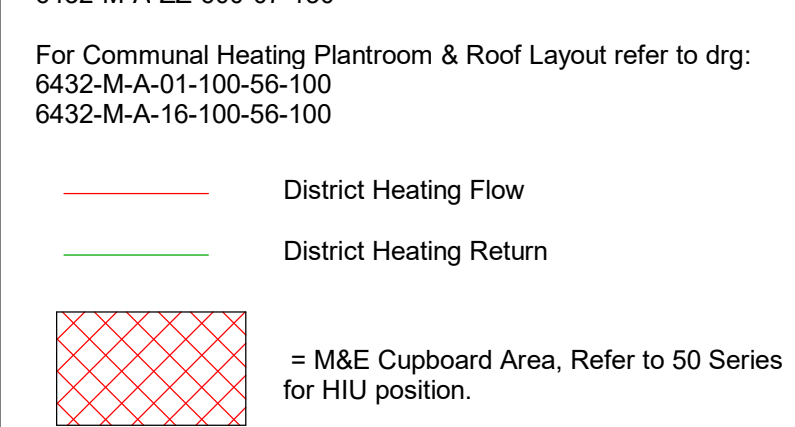


**Sheet Notes:**  
 This drawing is the property of Designbrook Ltd and as such may not be copied or communicated to a third party without written authorisation.  
 This drawing conveys design intent and is provided to assist the contractor in the development of their working drawings. **THE CONTRACTOR SHALL NOT INSTALL TO THIS DRAWING.**  
**PLEASE DO NOT SCALE FROM THIS DRAWING.**

True North 0.00°

Block B/C - Key Plan

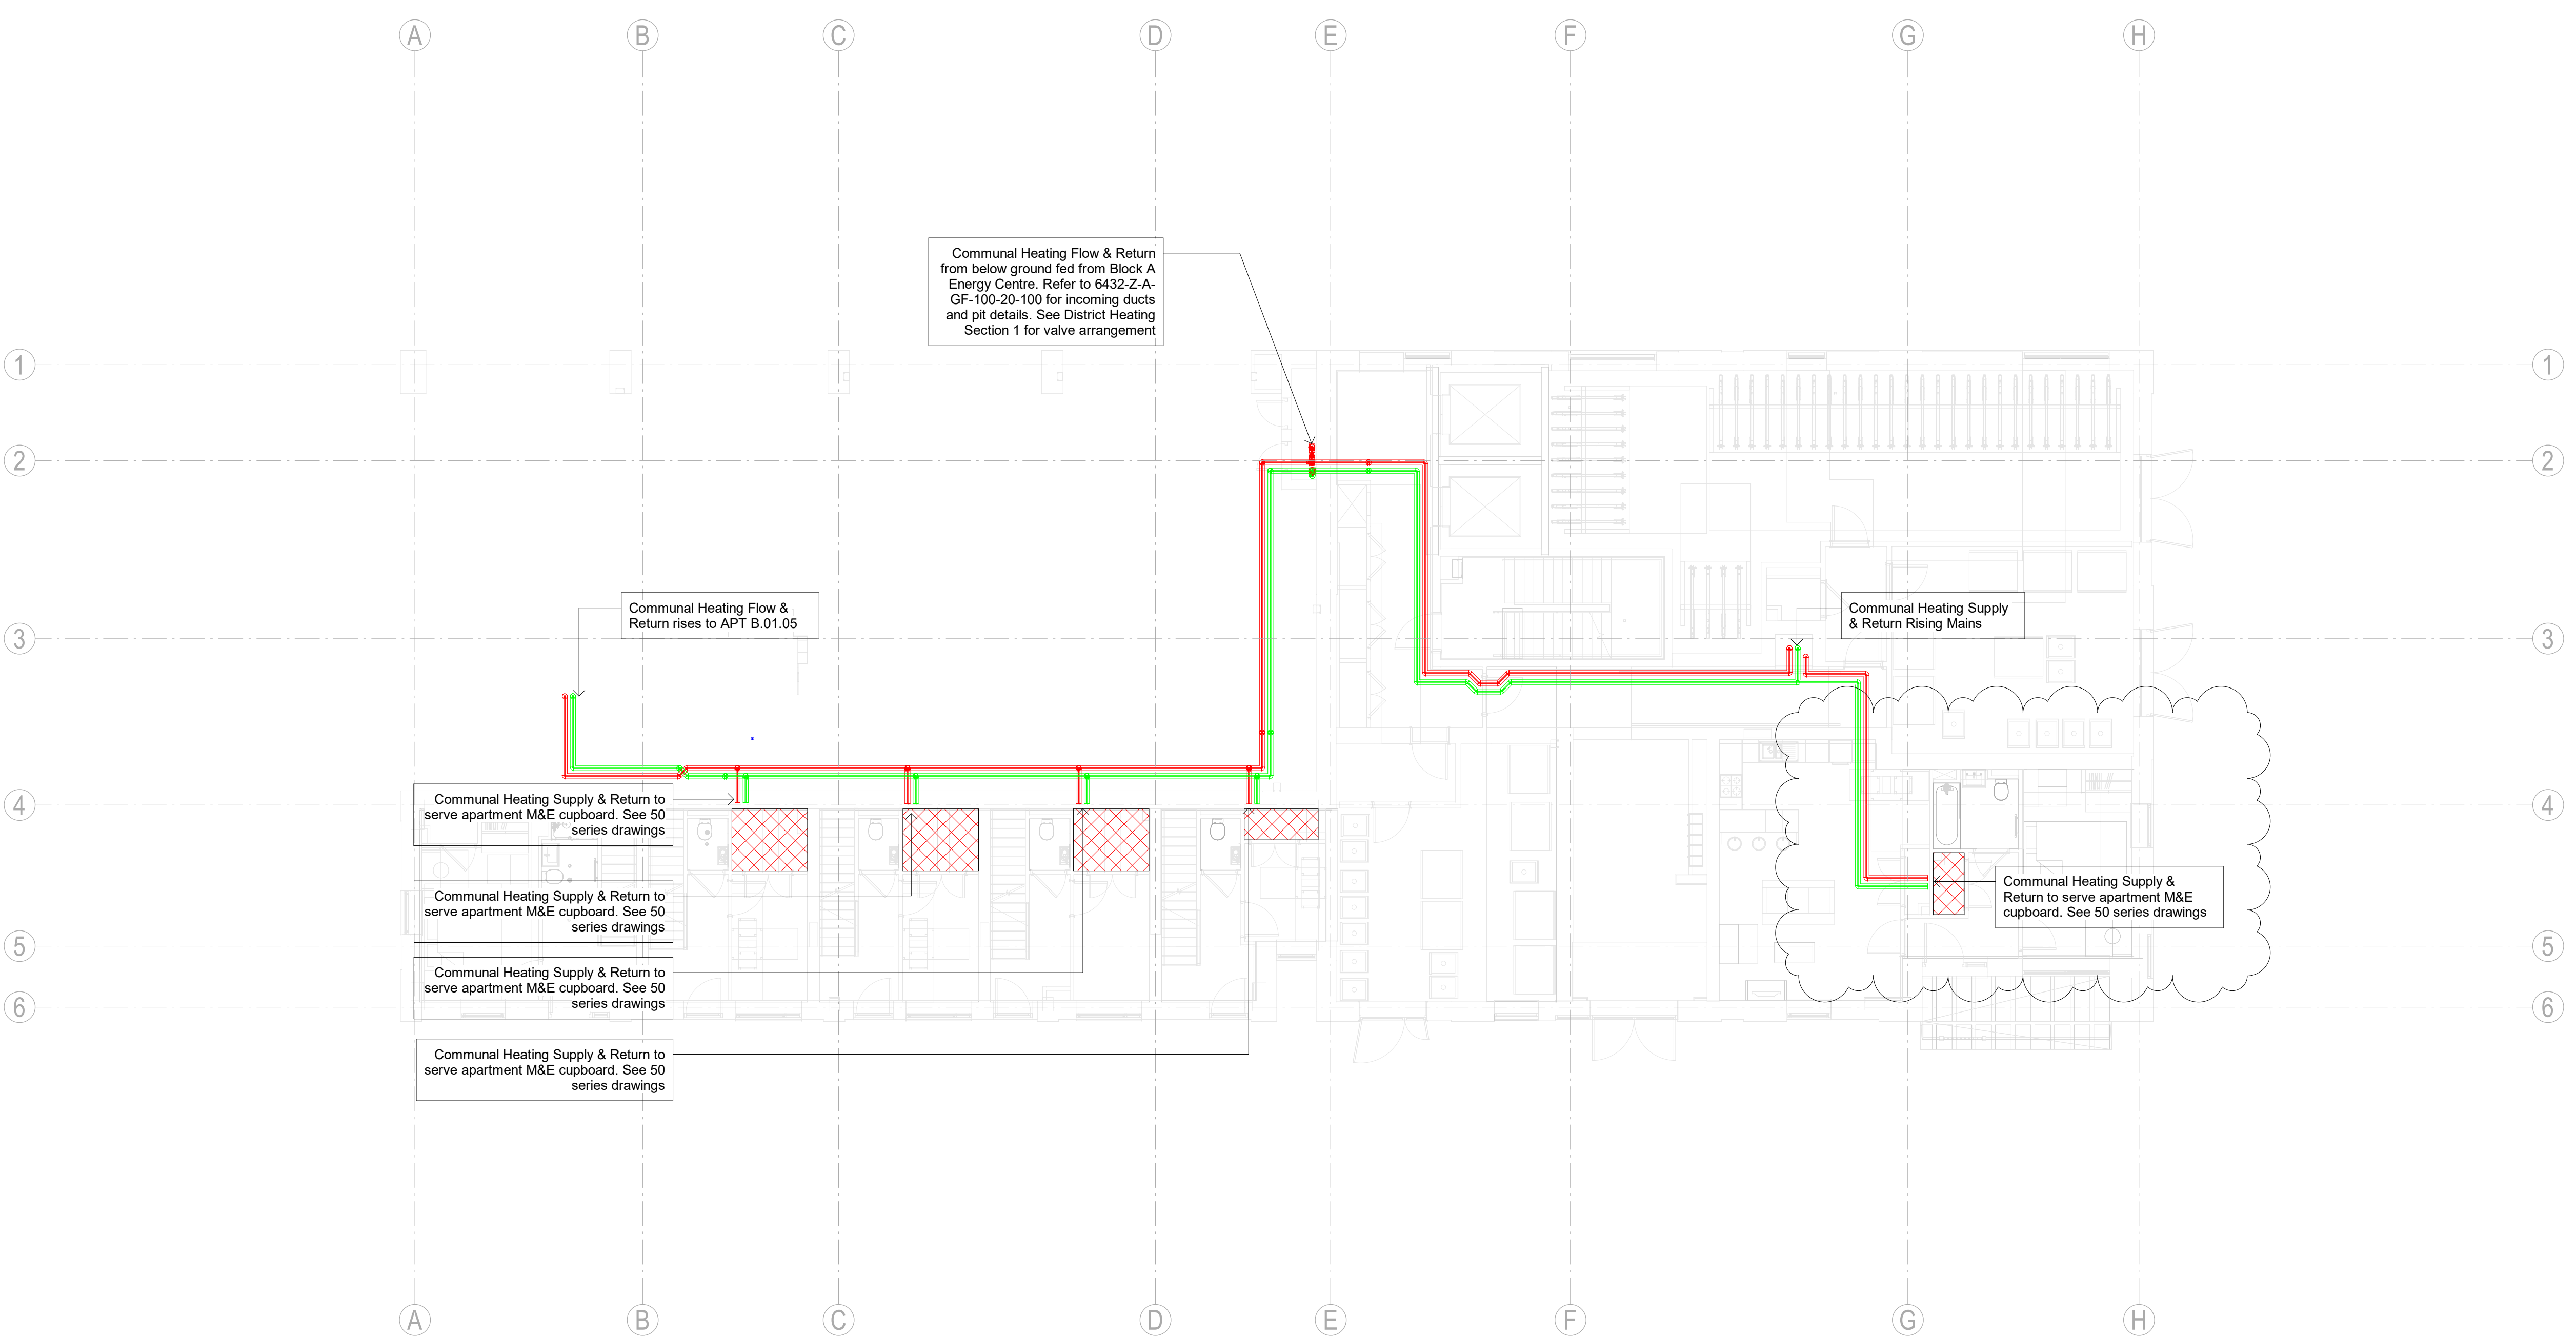

**1 B/C - L00 - Communal Heating Services Layout**  
 1 : 100

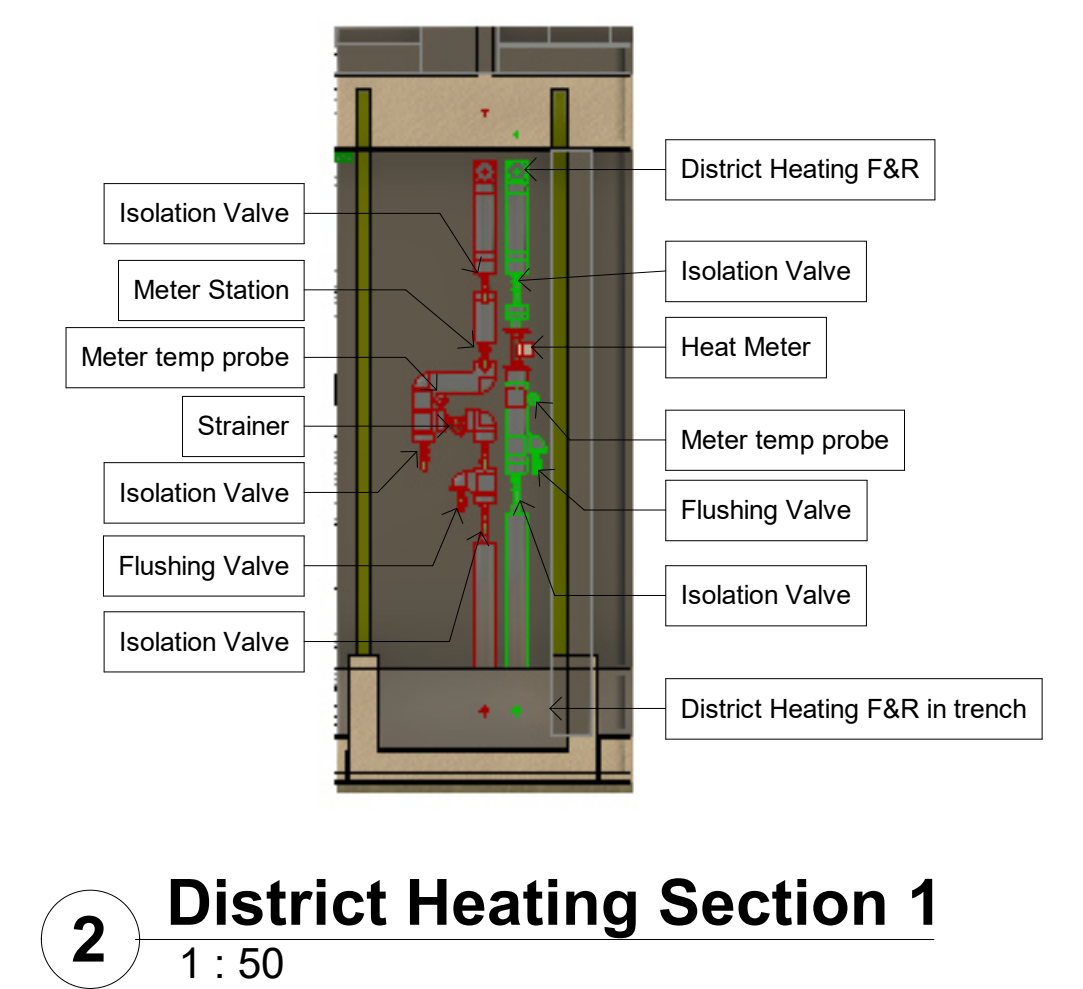

REVISION	DRAWN BY	CHECKED BY	DATE	DESCRIPTION
C3	SJL	AE	19/10/23	District Heating route amended to avoid Bin store.
C2	SJL	AE	26/06/23	Containment Route amended to avoid corridor door Knauf fixings as per meeting 22.06.23
C1	SJL	AE	11/04/23	Construction Issue
T2	JE	AE	20/09/22	Updated to latest ER's received & comments from design team
T1	SJL	AE	15/05/22	T1 Issue
P01	JE	AE	25/04/22	Preliminary Issue

**CLIENT**  
 LONDON SQUARE  
 HEAD OFFICE:  
 ONE YORK ROAD,  
 UXBRIDGE,  
 UBS 15N  
 WWW.LONDONSQUARE.CO.UK

**Designbrook Ltd.**  
 Unit J2, The Granary,  
 Bridge Farm,  
 Reading Road,  
 Arborfield,  
 Berkshire, RG2 9HT  
 Tel: 0118 9 773 011  
 E-mail: admin@designbrook.co.uk

**PROJECT TITLE**  
 The Hyde, Colindale, Phase 1  
**DRAWING ISSUE**  
 Construction Issue  
**DRAWING TITLE**  
 Block B/C- Ground floor , Communal Heating Primary Service Routes

SCALE	1:100@A1	DRAWN	JE
DATE	23/06/2022	CHECKED	AJE
DBR Project No.		J6432	

Identification	Sheet Number
Drawing Number	Rev.
6432-M-BC-00-100-56-110	C3

