


EXISTING SITE PLAN

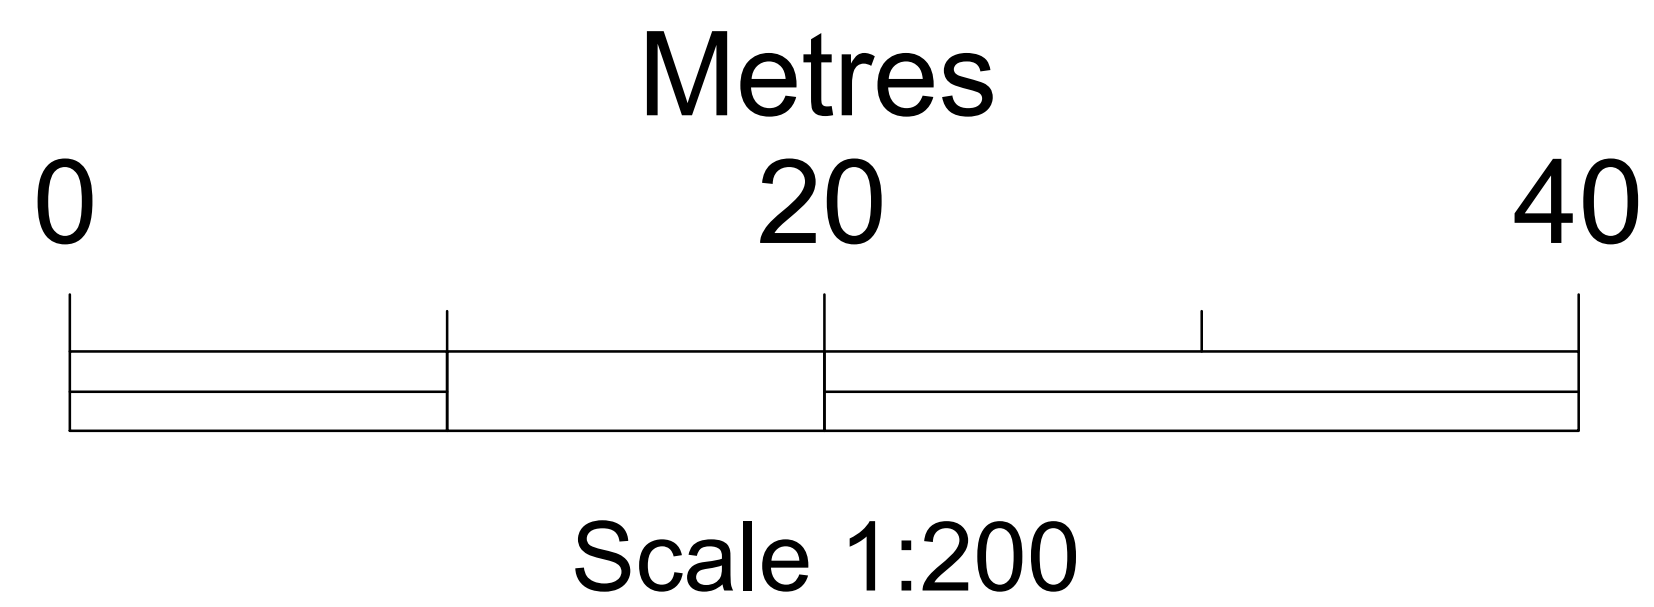

DRAWING NOTES:

1. IF IN DOUBT ASK.
2. EXISTING PV
3. NEW BUILD

01	PROPOSAL	LC	26/03/24
Rev	Description	Dwn	Date



UNIT 3, THE WESTERN CENTRE,
WESTERN ROAD,
BRACKNELL,
RG12 1RW
INFO@EESGROUP.CO.UK
01344 883 399

LEGAL DISCLAIMER
THIS DRAWING IS THE PROPERTY OF SMART ELECTRONIC DEVICES LTD. T/A ENERGY EFFICIENT SOLUTIONS GROUP. NO REPRODUCTION OR COPIES SHOULD BE MADE WITHOUT THE PRIOR WRITTEN AUTHORISATION BY THE CEO. DO NOT SCALE FROM THIS DRAWING. ONLY FIGURED DIMENSIONS ARE TO BE TAKEN FROM THIS DRAWING.

Status

PROPOSAL

Drawing title

SITE PLAN

System size	Client
252.03 kWp	OXFORD HIGH SCHOOL

No. of solar panels	Site Address
593	BELBROUGHTON ROAD OXFORD, OX2 6XA

Scale	Date	Drawn	Checked	Approved
1:200 @ A0	MAR 23	LC	MP	JO

Project no.	Dwg no.	Revision	Sheet No.
0861	E004	01	1 OF 2