

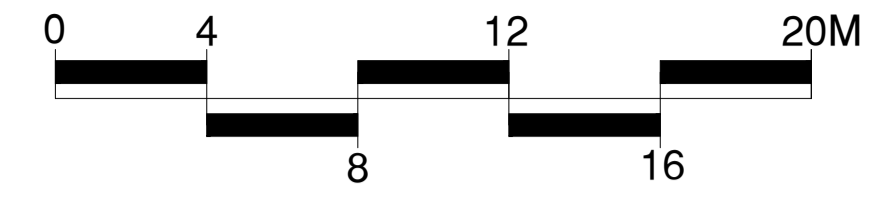


Royal Military Academy Sandhurst

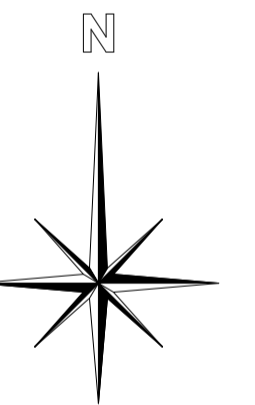

CONSULTANTS
SSL
 Surfacing Standards Limited
 Office 2, Enterprise House,
 Water Road, Coppland, LE19 9WY
 01535 400 017

1. DO NOT SCALE FROM DRAWING UNLESS FOR PLANNING PURPOSES
 ONLY. ALL DIMENSIONS TO BE CHECKED ON SITE PRIOR TO
 COMMENCEMENT OF WORKS
 2. THIS DRAWING IS COPYRIGHT TO SURFACING STANDARDS LTD
 ALL PERSONNEL SHOULD BE AWARE OF THE HEALTH AND SAFETY PLAN
 WHICH IS RETAINED IN THE SITE MANAGERS OFFICE

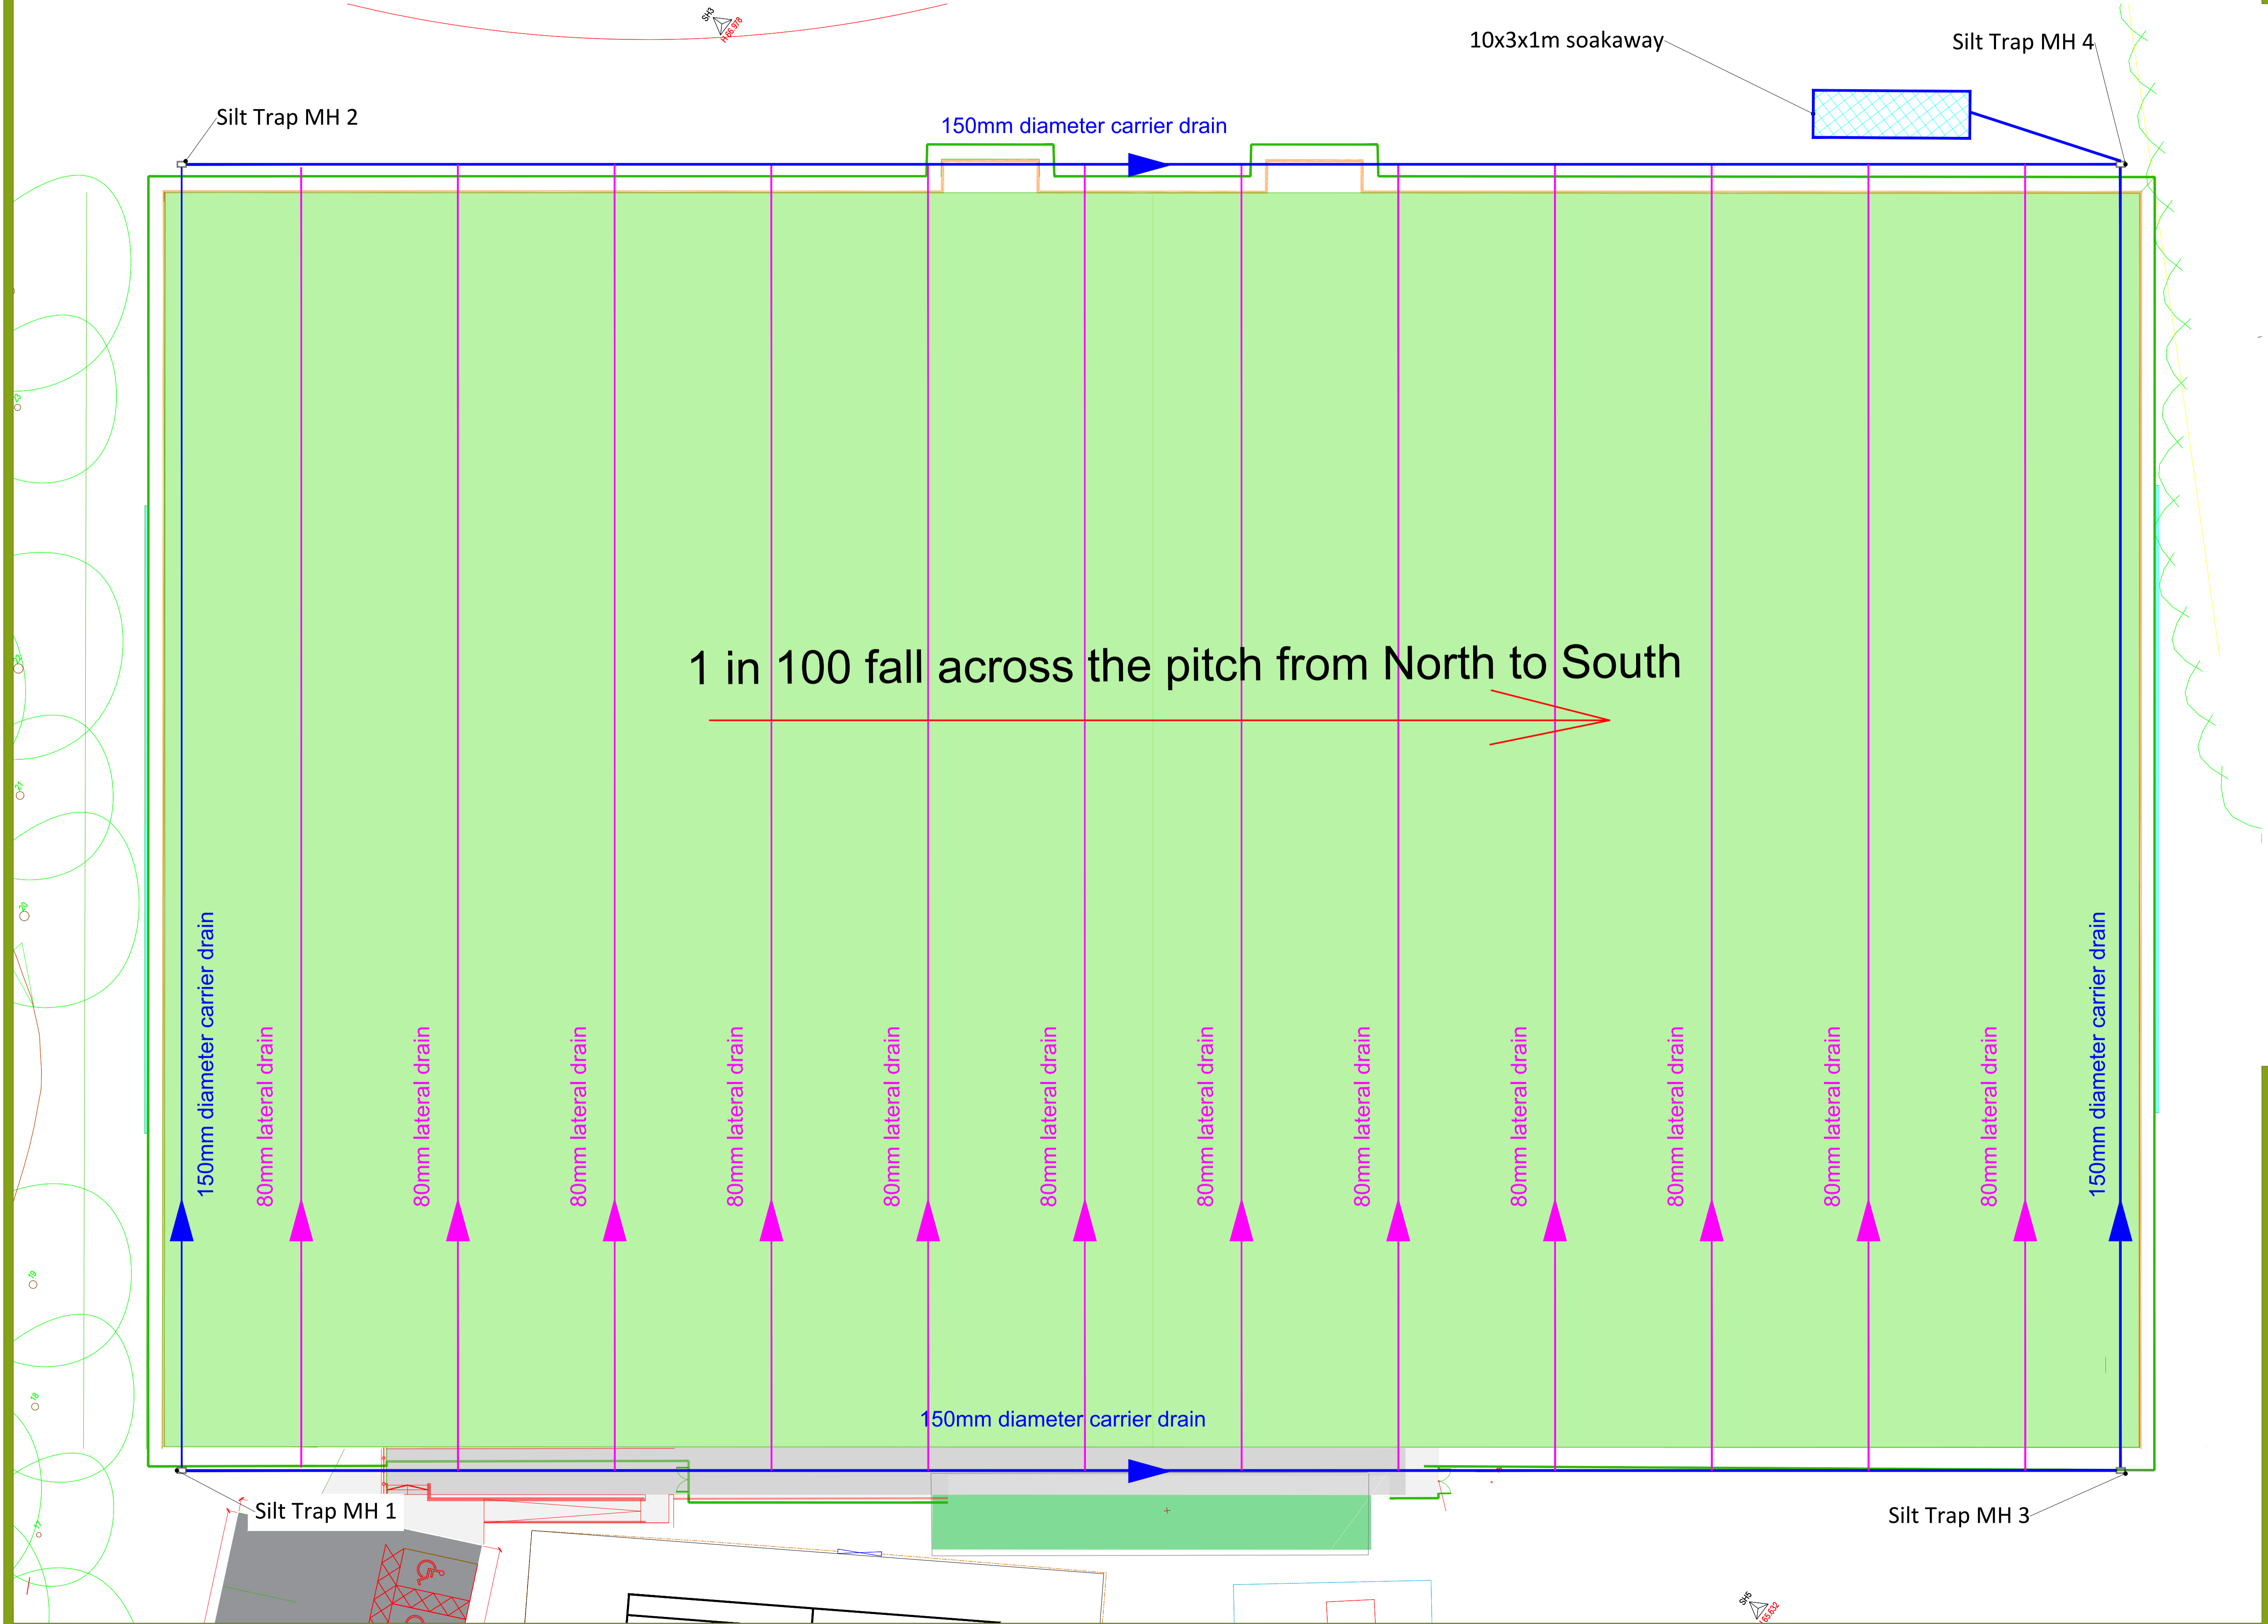

00	FEASIBILITY ISSUE	ME	WB	08.10.21
REV	DESCRIPTION	REV	CK	DATE
<p>SSL Surfacing Standards Limited SPORTS PITCH CONSULTANTS</p>				
AUTHOR ME				
TITLE Royal Military Academy Sandhurst Proposed Rugby Drainage Layout				
PROJECT	SSL3159	SCALE	1:200	SIZE A1
DRAWING No	03	REVISION	00	