




# Royal Military Academy

Sandhurst

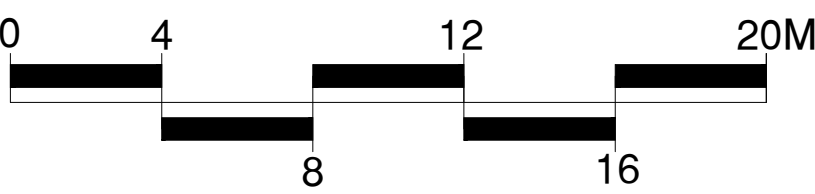

CONSULTANTS  
**SSL**  
Surfacing Standards Limited  
Office: 2, Eppingham House,  
Aston Road, Lippington, LE19 9WY  
01535 400172

1. DO NOT SCALE FROM DRAWING UNLESS FOR PLANNING PURPOSES  
ONLY. ALL DIMENSIONS TO BE CHECKED ON SITE PRIOR TO  
COMMENCEMENT OF WORKS  
2. THIS DRAWING IS COPYRIGHT TO SURFACING STANDARDS LTD  
3. ALL PERSONNEL SHOULD BE AWARE OF THE HEALTH AND SAFETY PLAN  
WHICH IS RETAINED IN THE SITE MANAGER'S OFFICE

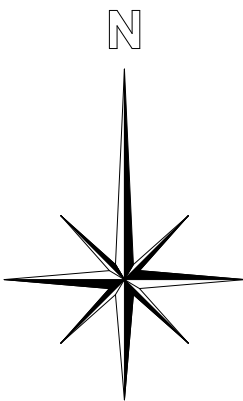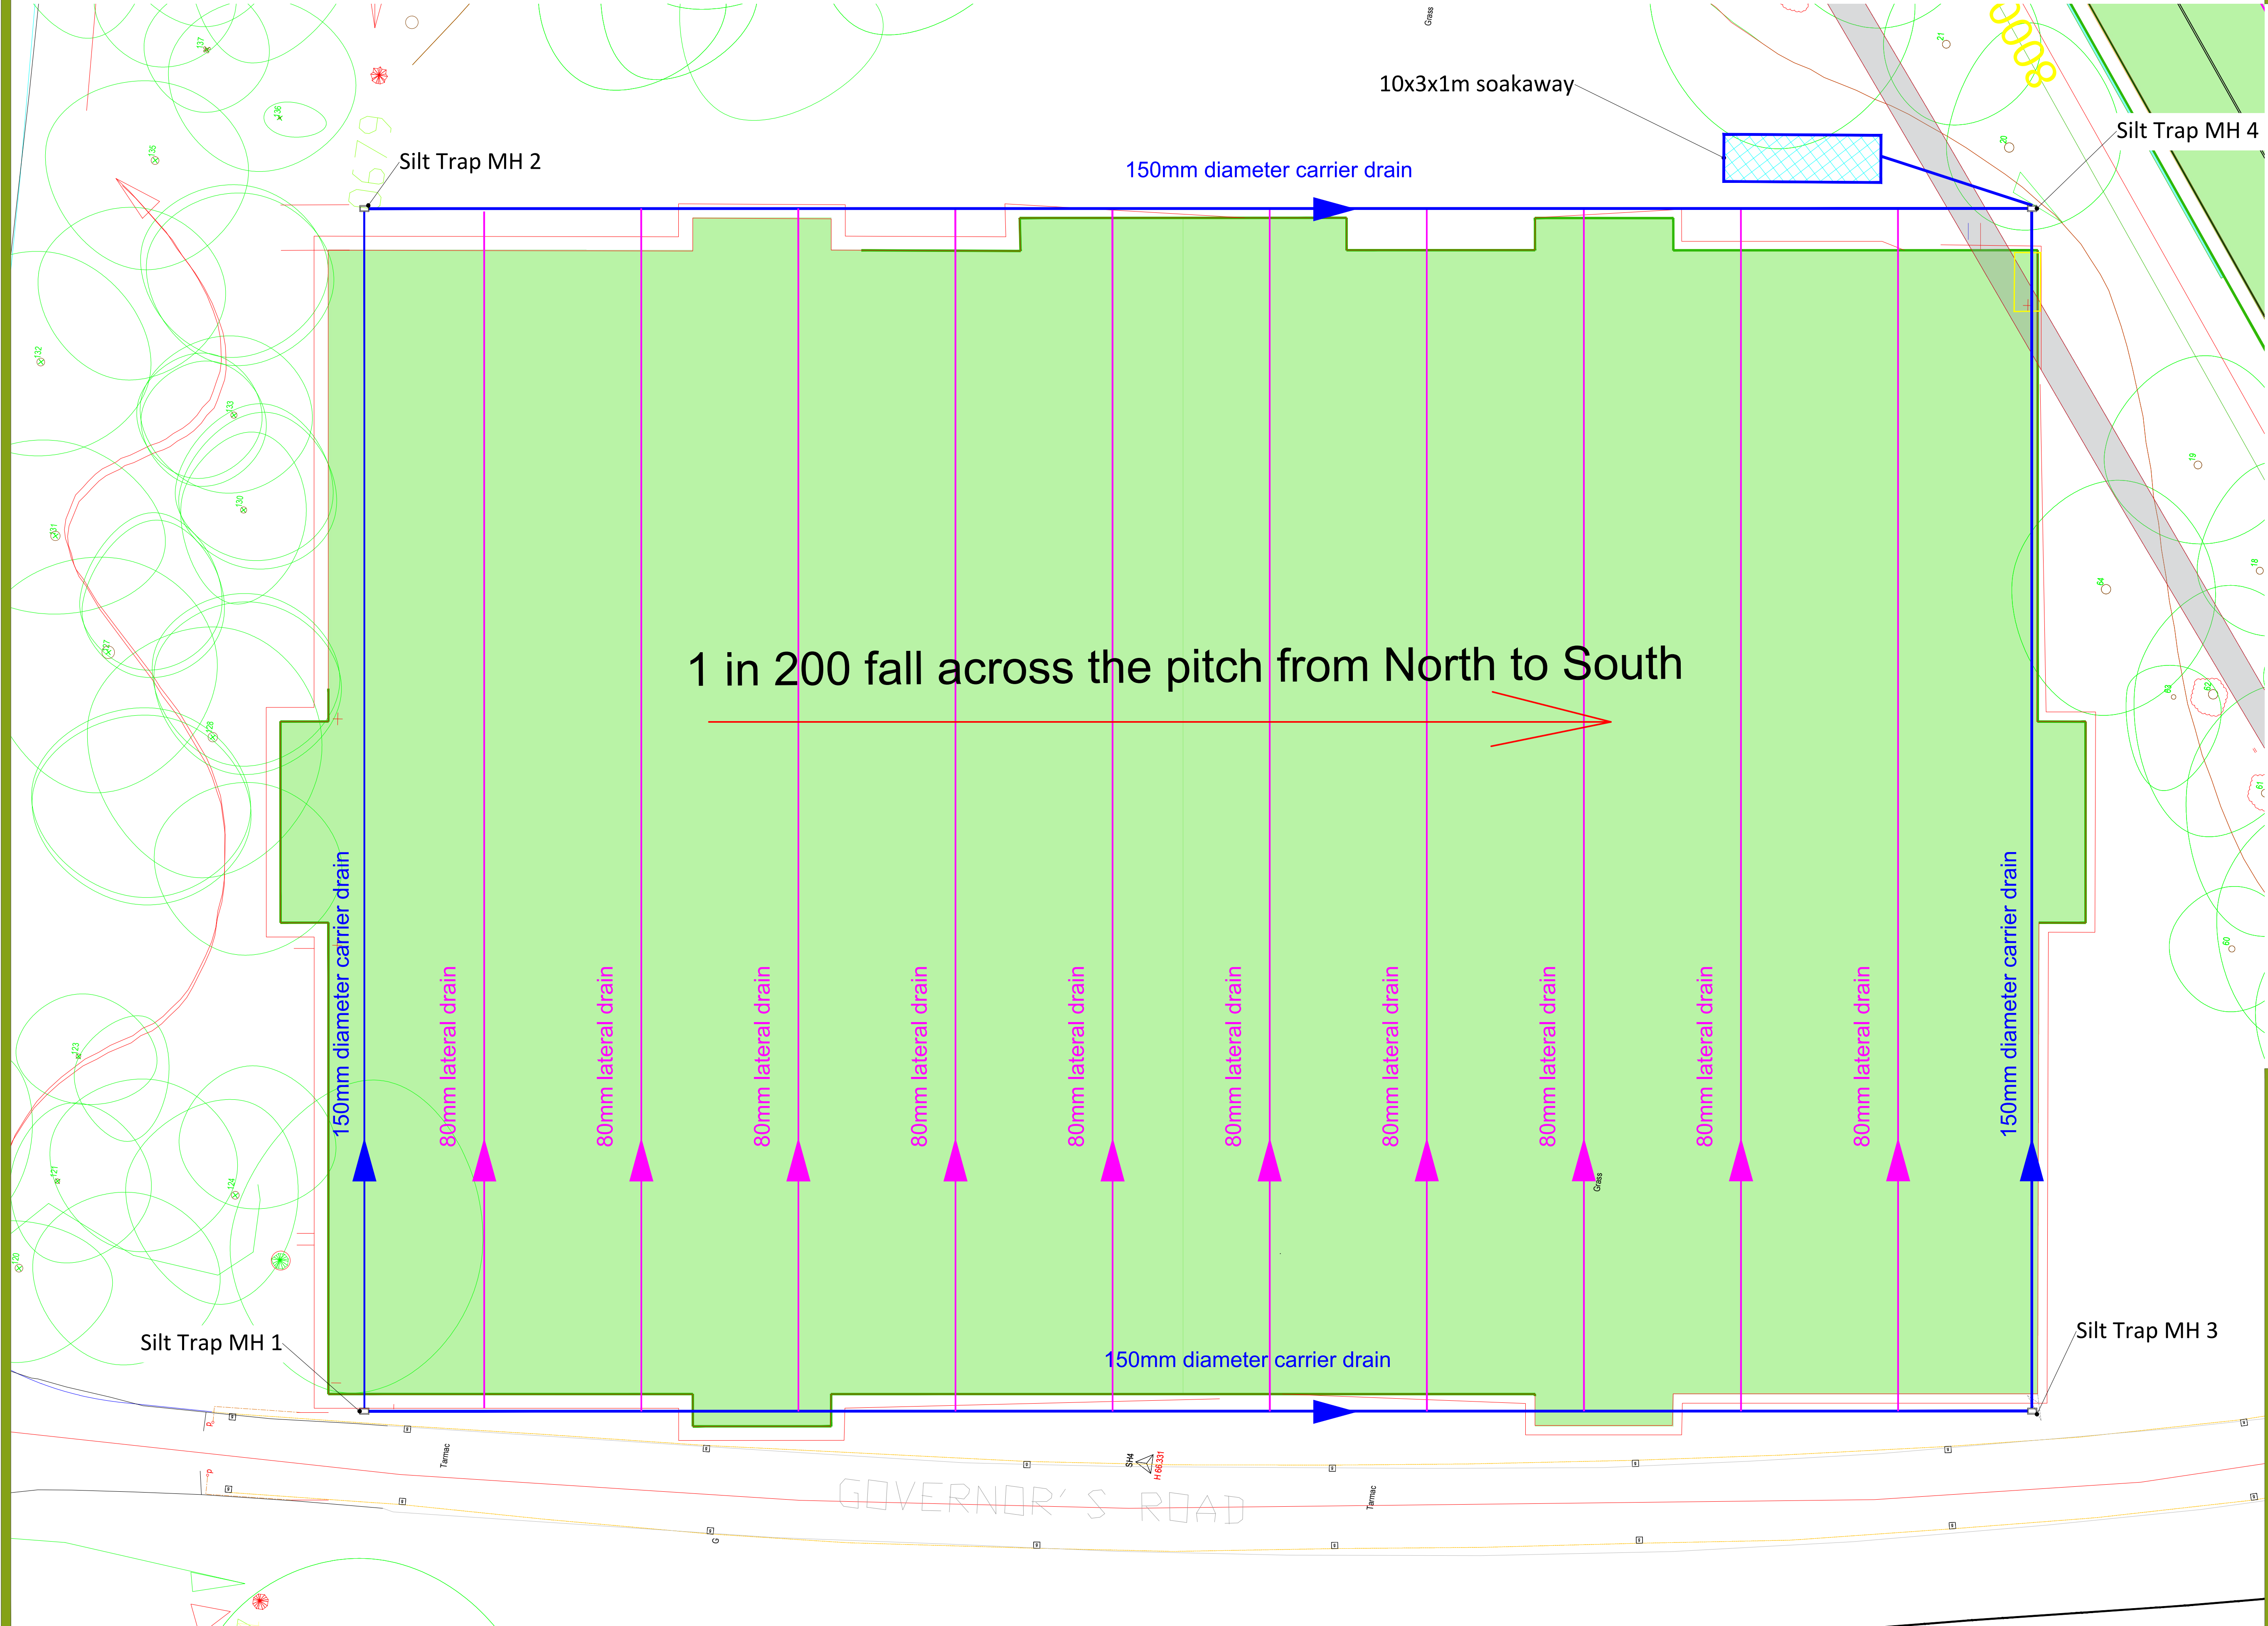

00	FEASIBILITY ISSUE	ME	WB	08.10.21
REV	DESCRIPTION	REV	CK	DATE



AUTHOR  
ME

TITLE  
Royal Military Academy  
Sandhurst  
Proposed Football Drainage Layout

PROJECT	SSL3159	SCALE	1:200	SIZE	A1
---------	---------	-------	-------	------	----

DRAWING No	01	REVISION	00
------------	----	----------	----